


PROJECT DESCRIPTION:


REMOVE EXISTING SCREEN ASSEMBLY, SIDING AND TRIM FROM ADDITION ON THE REAR OF THE HOUSE. ALSO REMOVE EXISTING EXTERIOR WOOD DECKING AND PRIVACY WALL. TEMPORARILY BRACE ADDITION ROOF AND REMOVE WALLS, CEILING, DOORS, FIXTURES, WINDOWS, INTERIOR DRYWALL, COLUMNS AND FLOORING.

REBUILD STRUCTURAL SUPPORT UNDER EXISTING ADDITION AND ENCLOSE THE ENTIRE FOOTPRINT OF THE EXISTING ADDITION WITH NEW INTERIOR ENTRY, BATHROOM AND PANTRY. THIS WILL INCLUDE NEW ROOFING, WALLS, SIDING, WINDOWS, TRIM, CEILING, INTERIOR DOORS AND FIXTURES AS DEPICTED IN DRAWINGS.

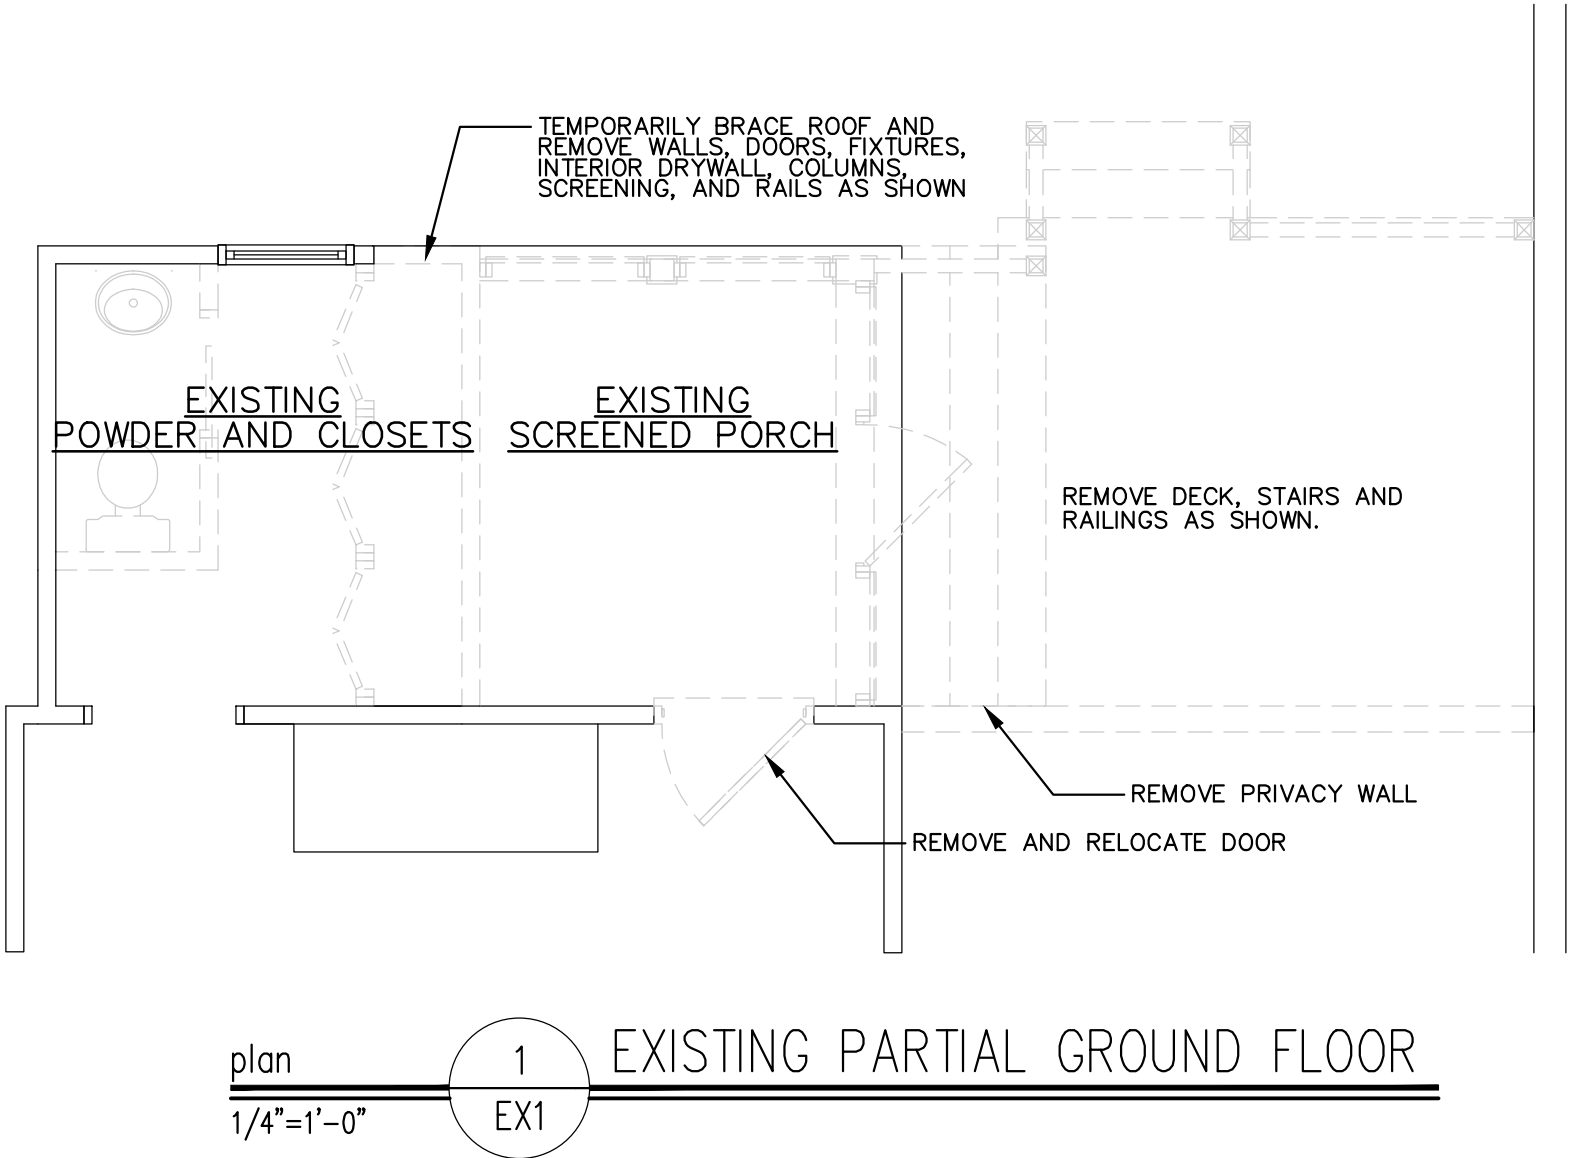


Renovations to:
Doerger Residence

114 West Bolton Street
Savannah, GA 31401

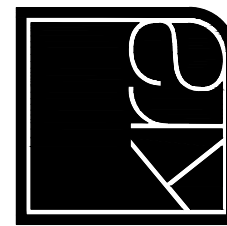

KRA architecture + design

KRA architecture + design
P O B O X 2 0 4 7
Bluffton, SC 29910

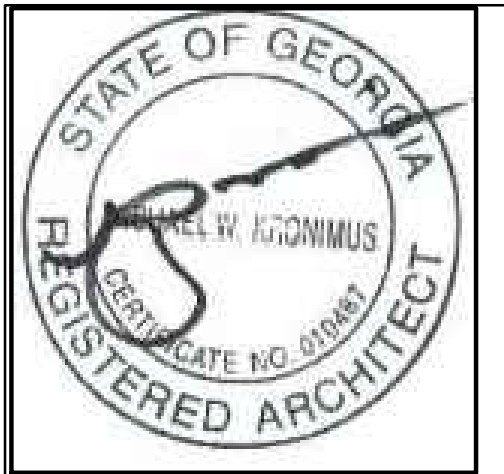

Stamped By: _____

Drawn By: _____

Checked By: _____

Date: 07.20.26

Revisions

No.	Description	By	Date

Project No: 26124

File Name: _____



Drawing Title: _____

EXISTING FLOOR
PLANS AND
ELEVATIONS

EX1


Sheet No. _____

Scale: _____

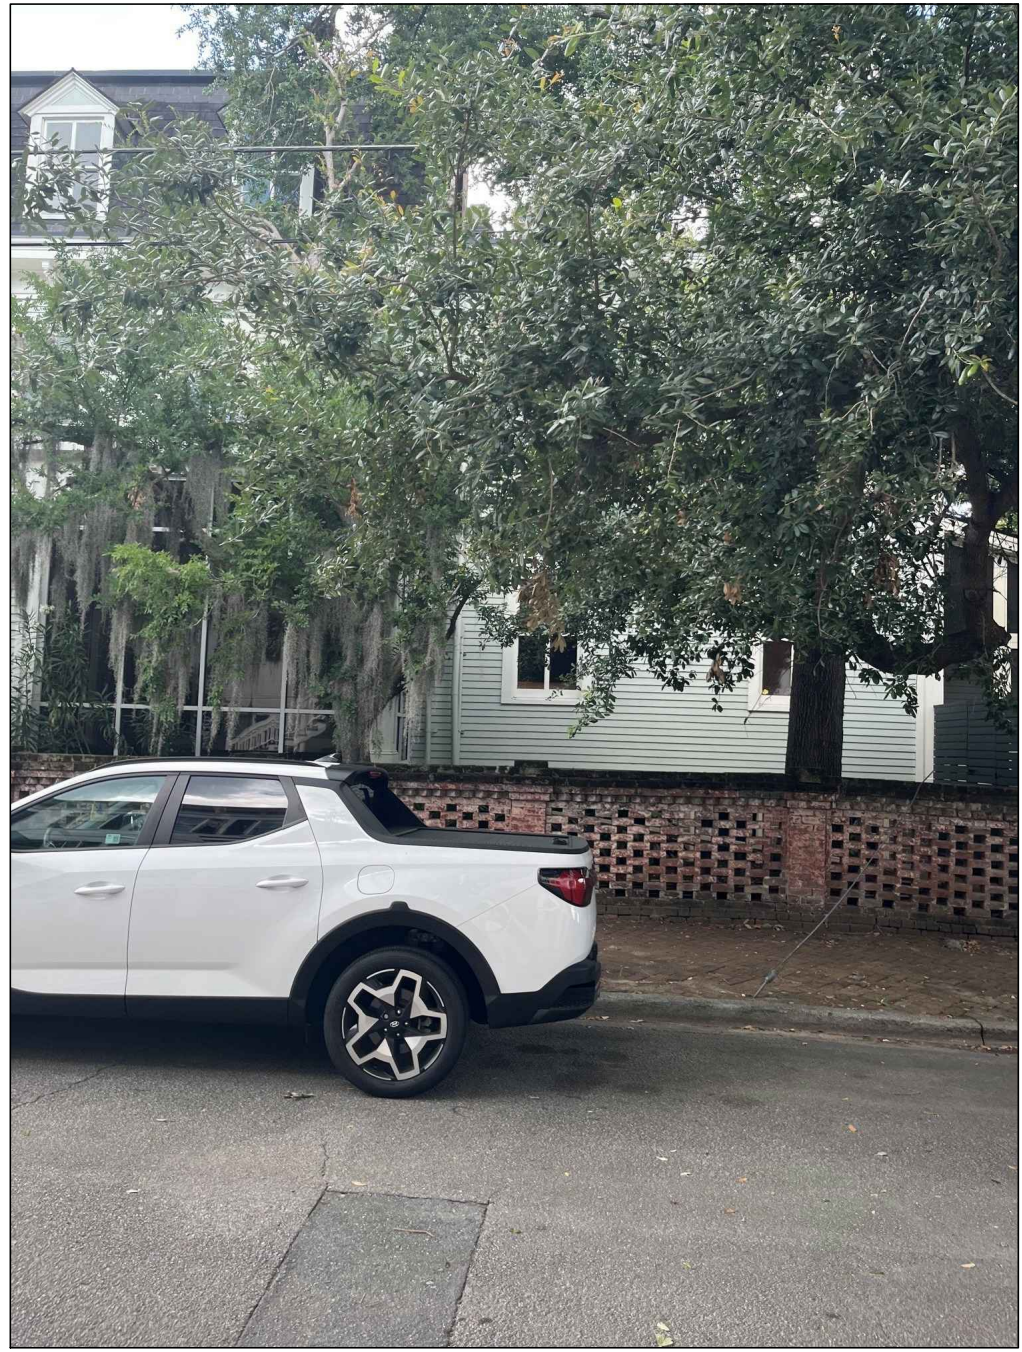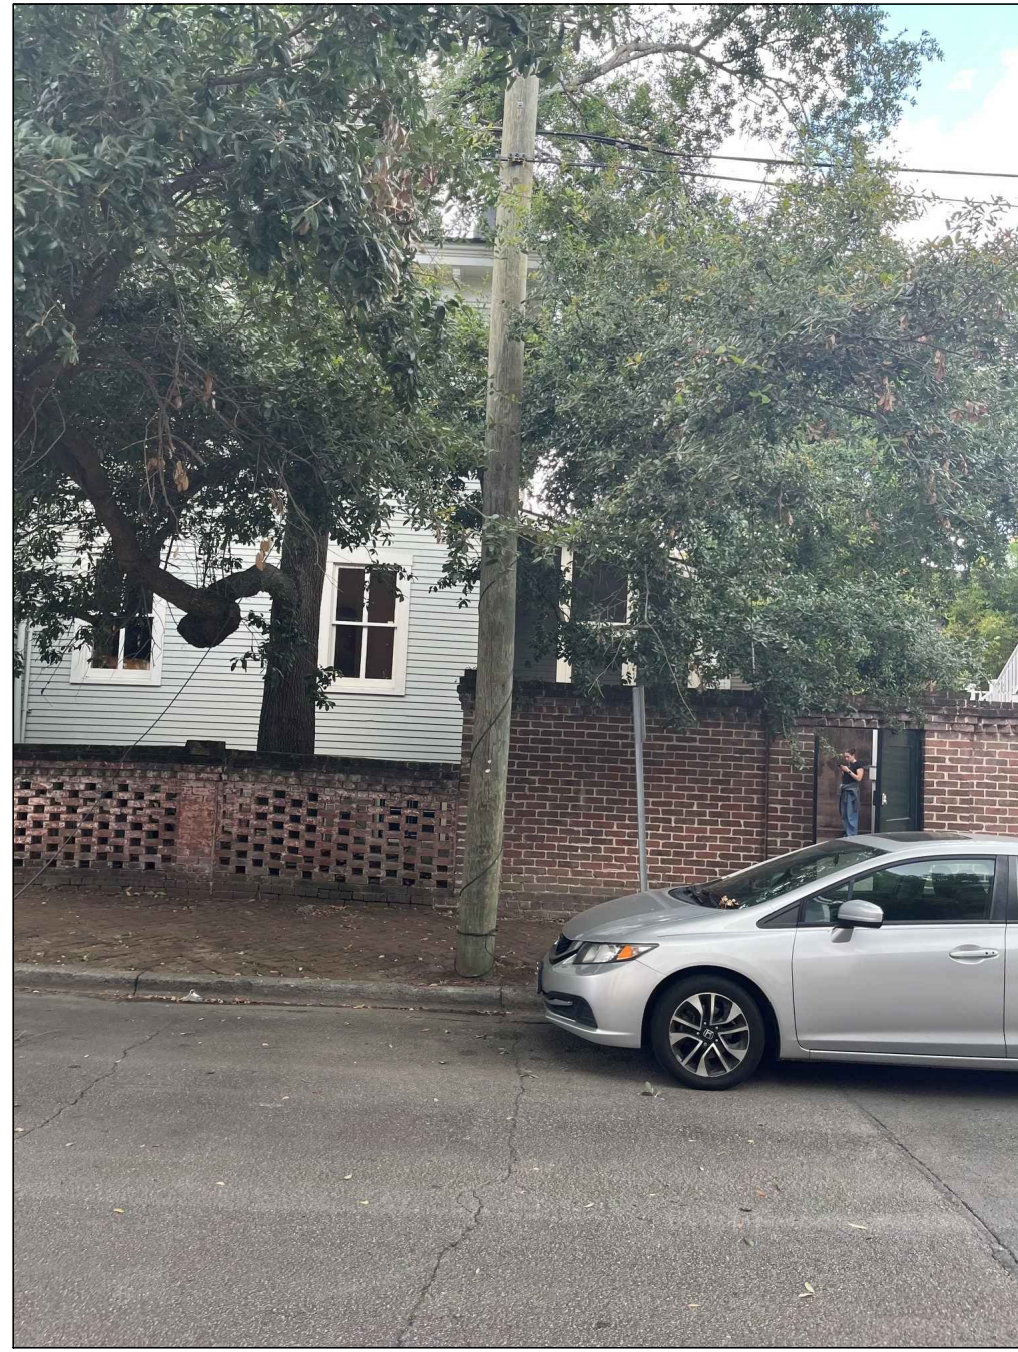

Renovations to: Doerger Residence

114 West Bolton Street
Savannah, GA 31401

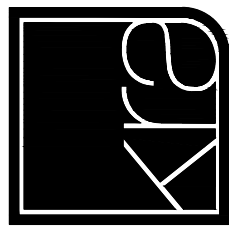

KRA architecture + design

KRA architecture + design
P O B O X 2 0 4 7
Bluffton, SC 29910
t. 843.815.2021
www.krasc.com



Stamped By:

Drawn By:

Checked By:

Date: 07.20.26

Revisions

Project No: 26124

File Name:

Drawing Title:

EXISTING PHOTOS

 
EP


Sheet No.

Scale:

Renovations to:
Doerger Residence

114 West Bolton Street
Savannah, GA 31401




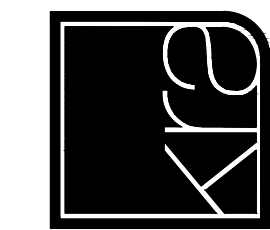

KRA architecture + design

KRA architecture + design
P O B O X 2 0 4 7
Bluffton, SC 29910

 t. 843.815.2021
www.krasc.com



Stamped By: _____

Drawn By: _____

Checked By: _____

Date: 07.20.26

Revisions

1	STAFF COMMENTS	08.06.26

Project No: 26124


File Name: _____

Drawing Title: _____

PROPOSED PLANS
AND ELEVATIONS


Sheet No. **A1.1**

Scale: _____

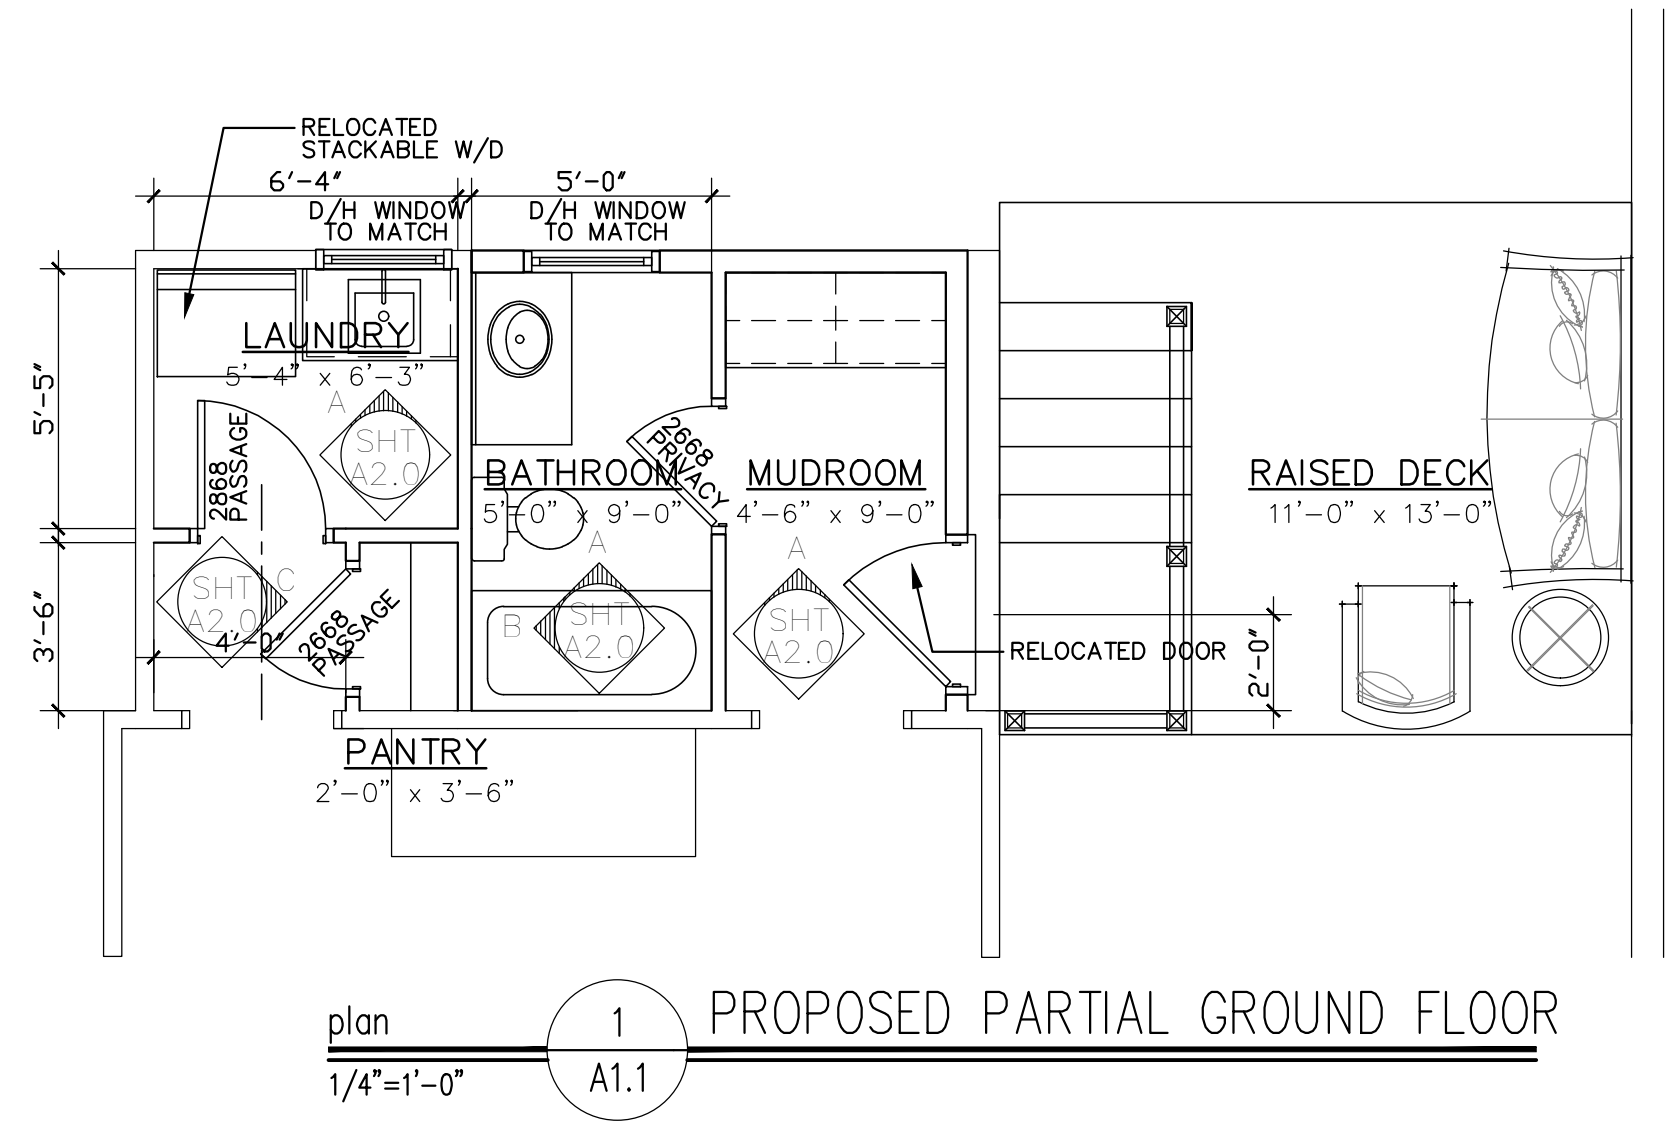

elevation 5 PROPOSED RIGHT ELEVATION

1/4"=1'-0" A1.1

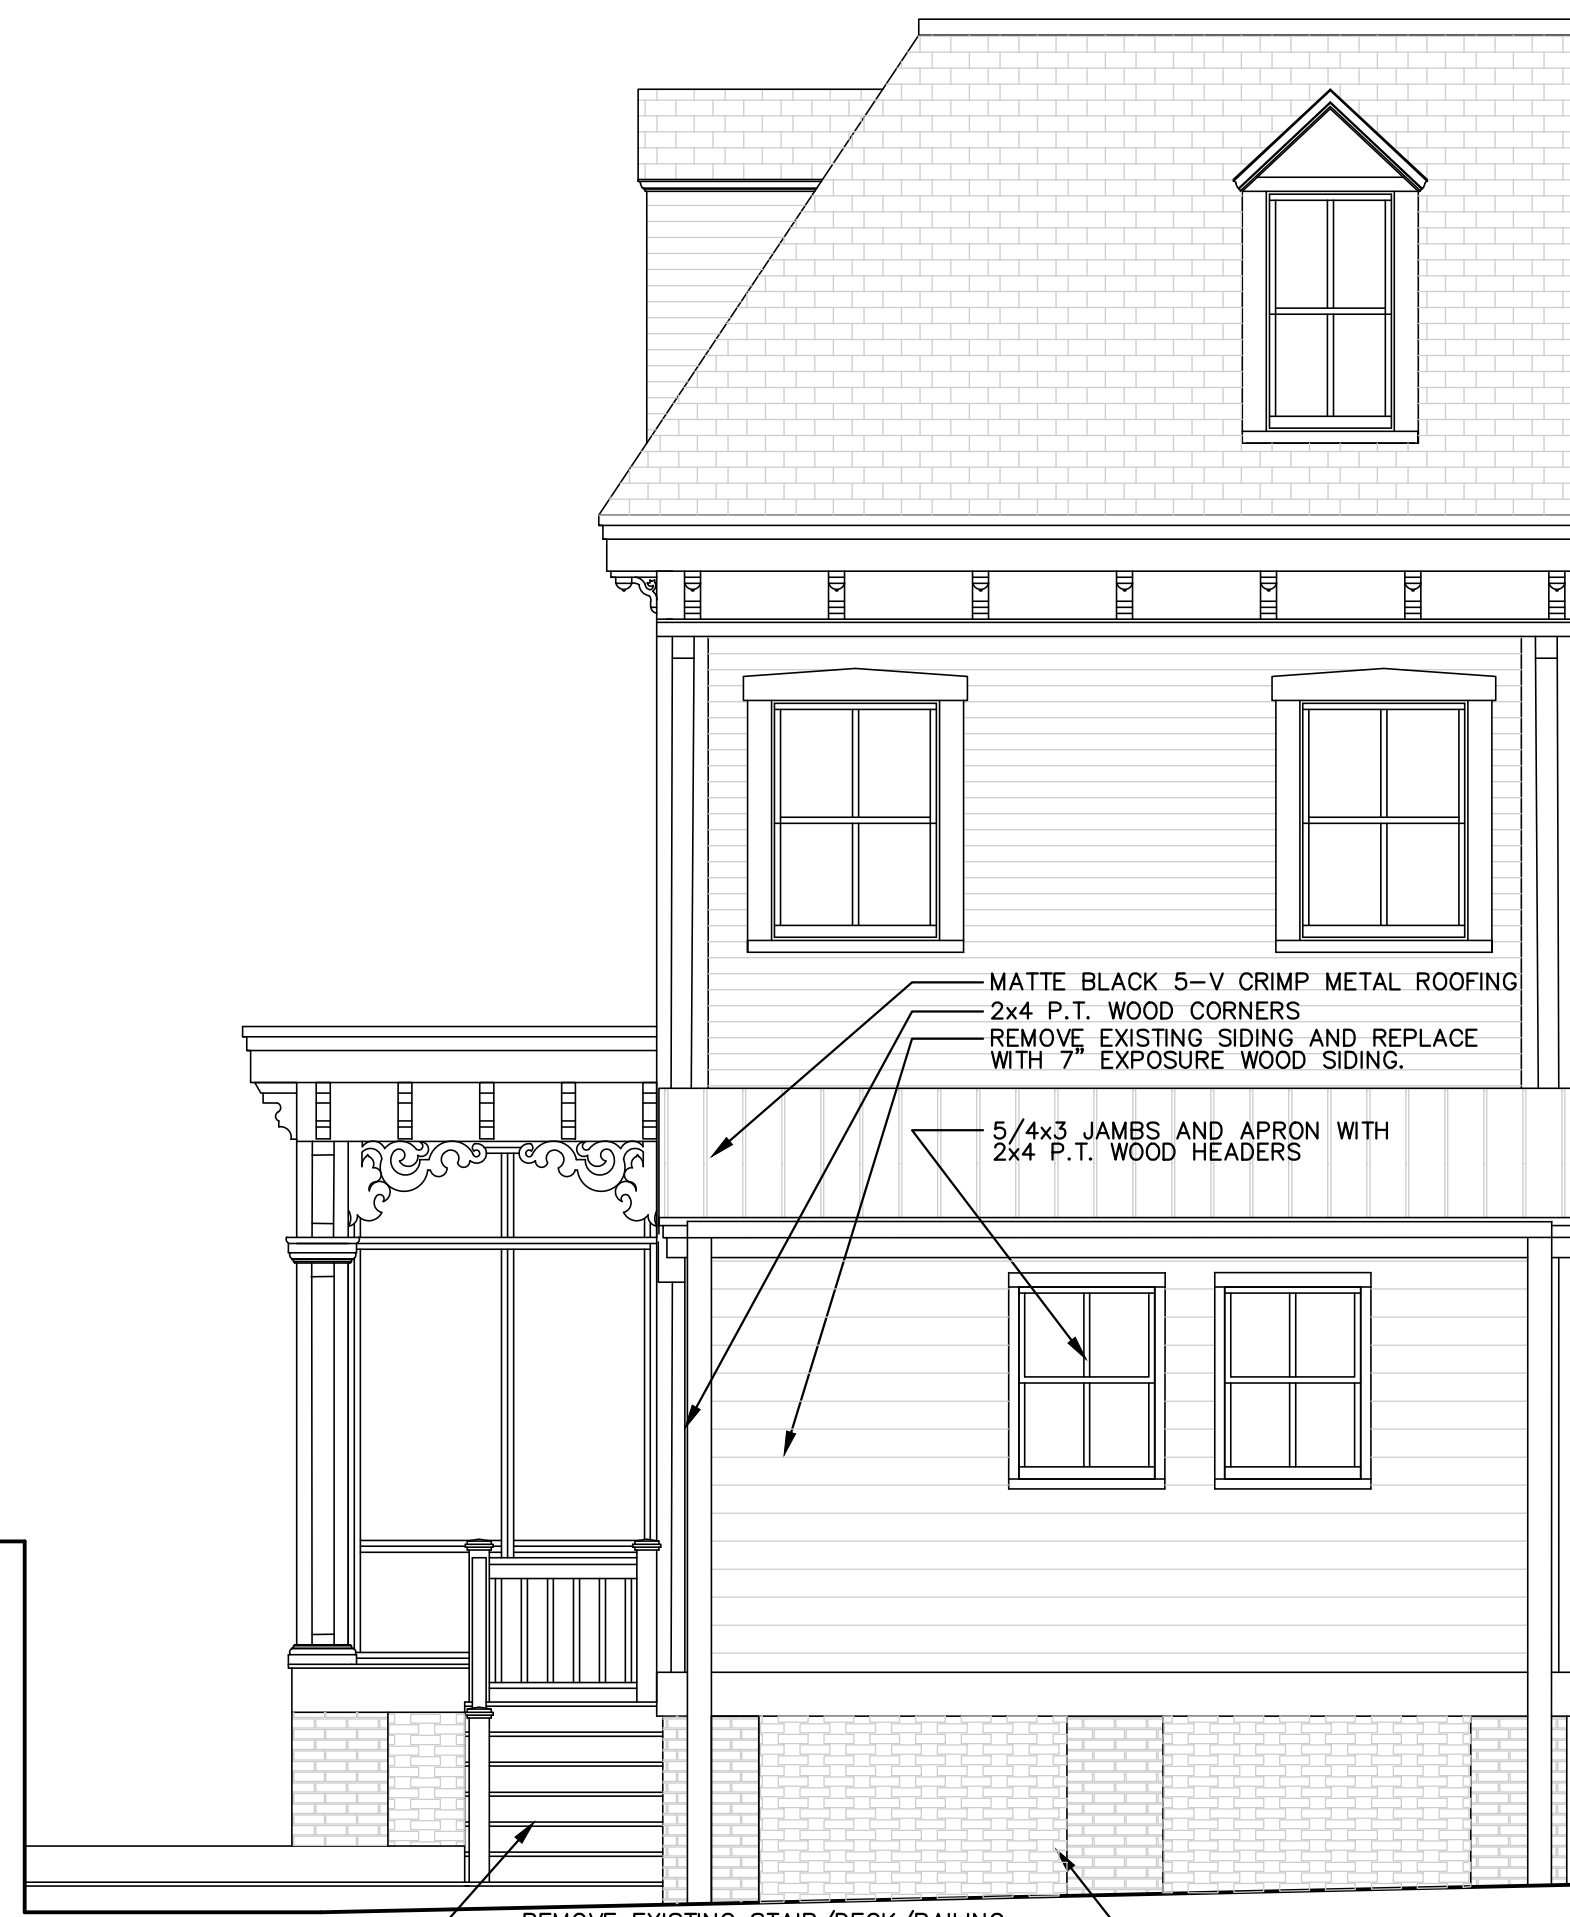



elevation 4 PROPOSED REAR ELEVATION

1/4"=1'-0" A1.1

Renovations to:
Doerger Residence

 114 West Bolton Street
Savannah, GA 31401




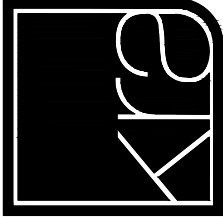

KRA architecture + design

KRA architecture + design
P O B O X 2 0 4 7
Bluffton, SC 29910

 t. 843.815.2021
www.krasc.com



Stamped By: _____

Drawn By: _____

Checked By: _____

Date: 07.20.26



Revisions




Project No. 26124

File Name: _____

Drawing Title:
**INTERIOR
ELEVATIONS**


Sheet No. **A2.0**
Scale: _____

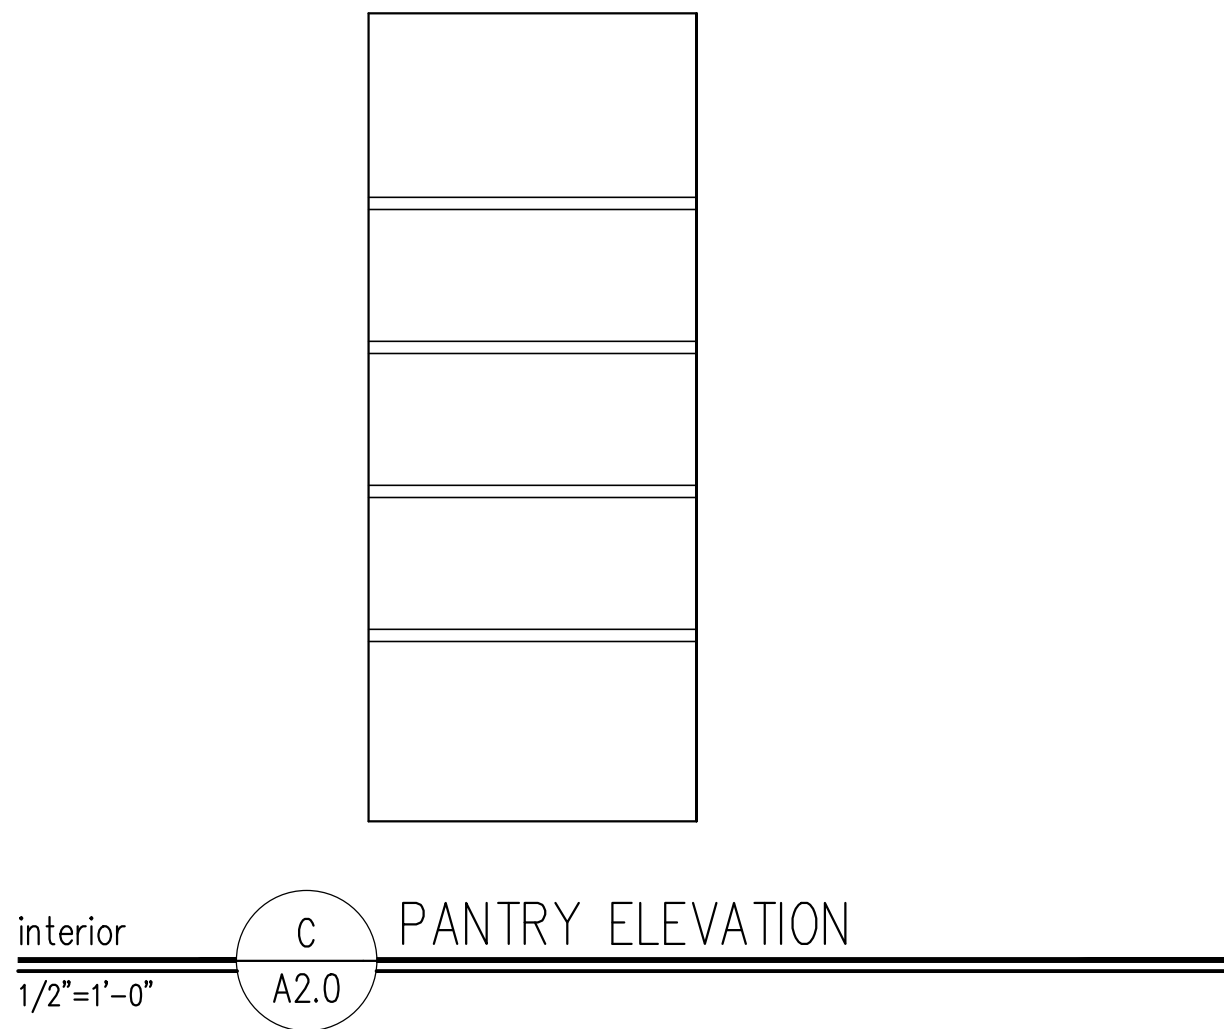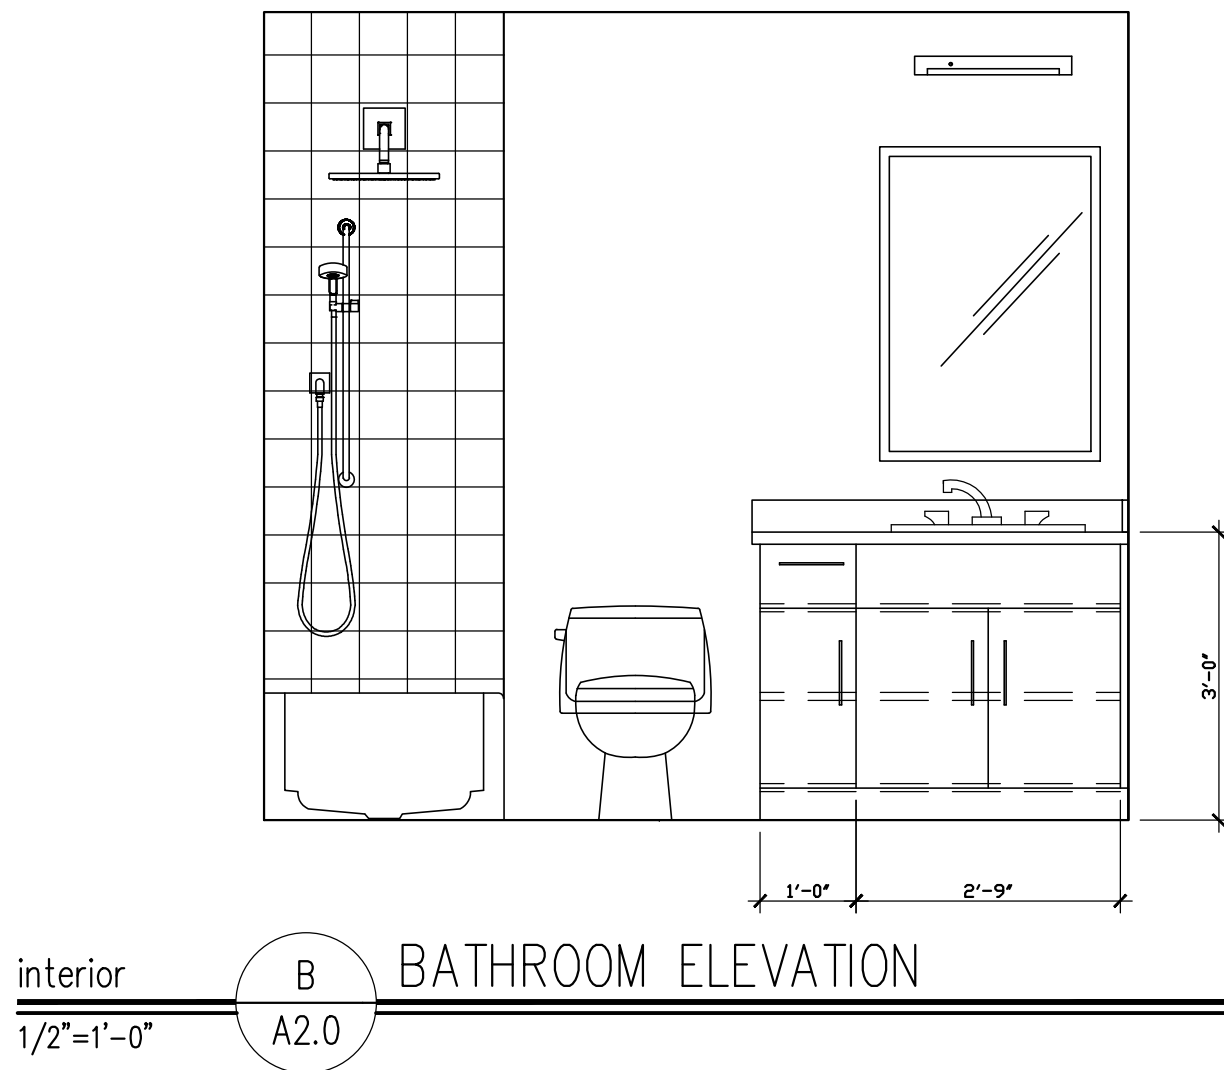

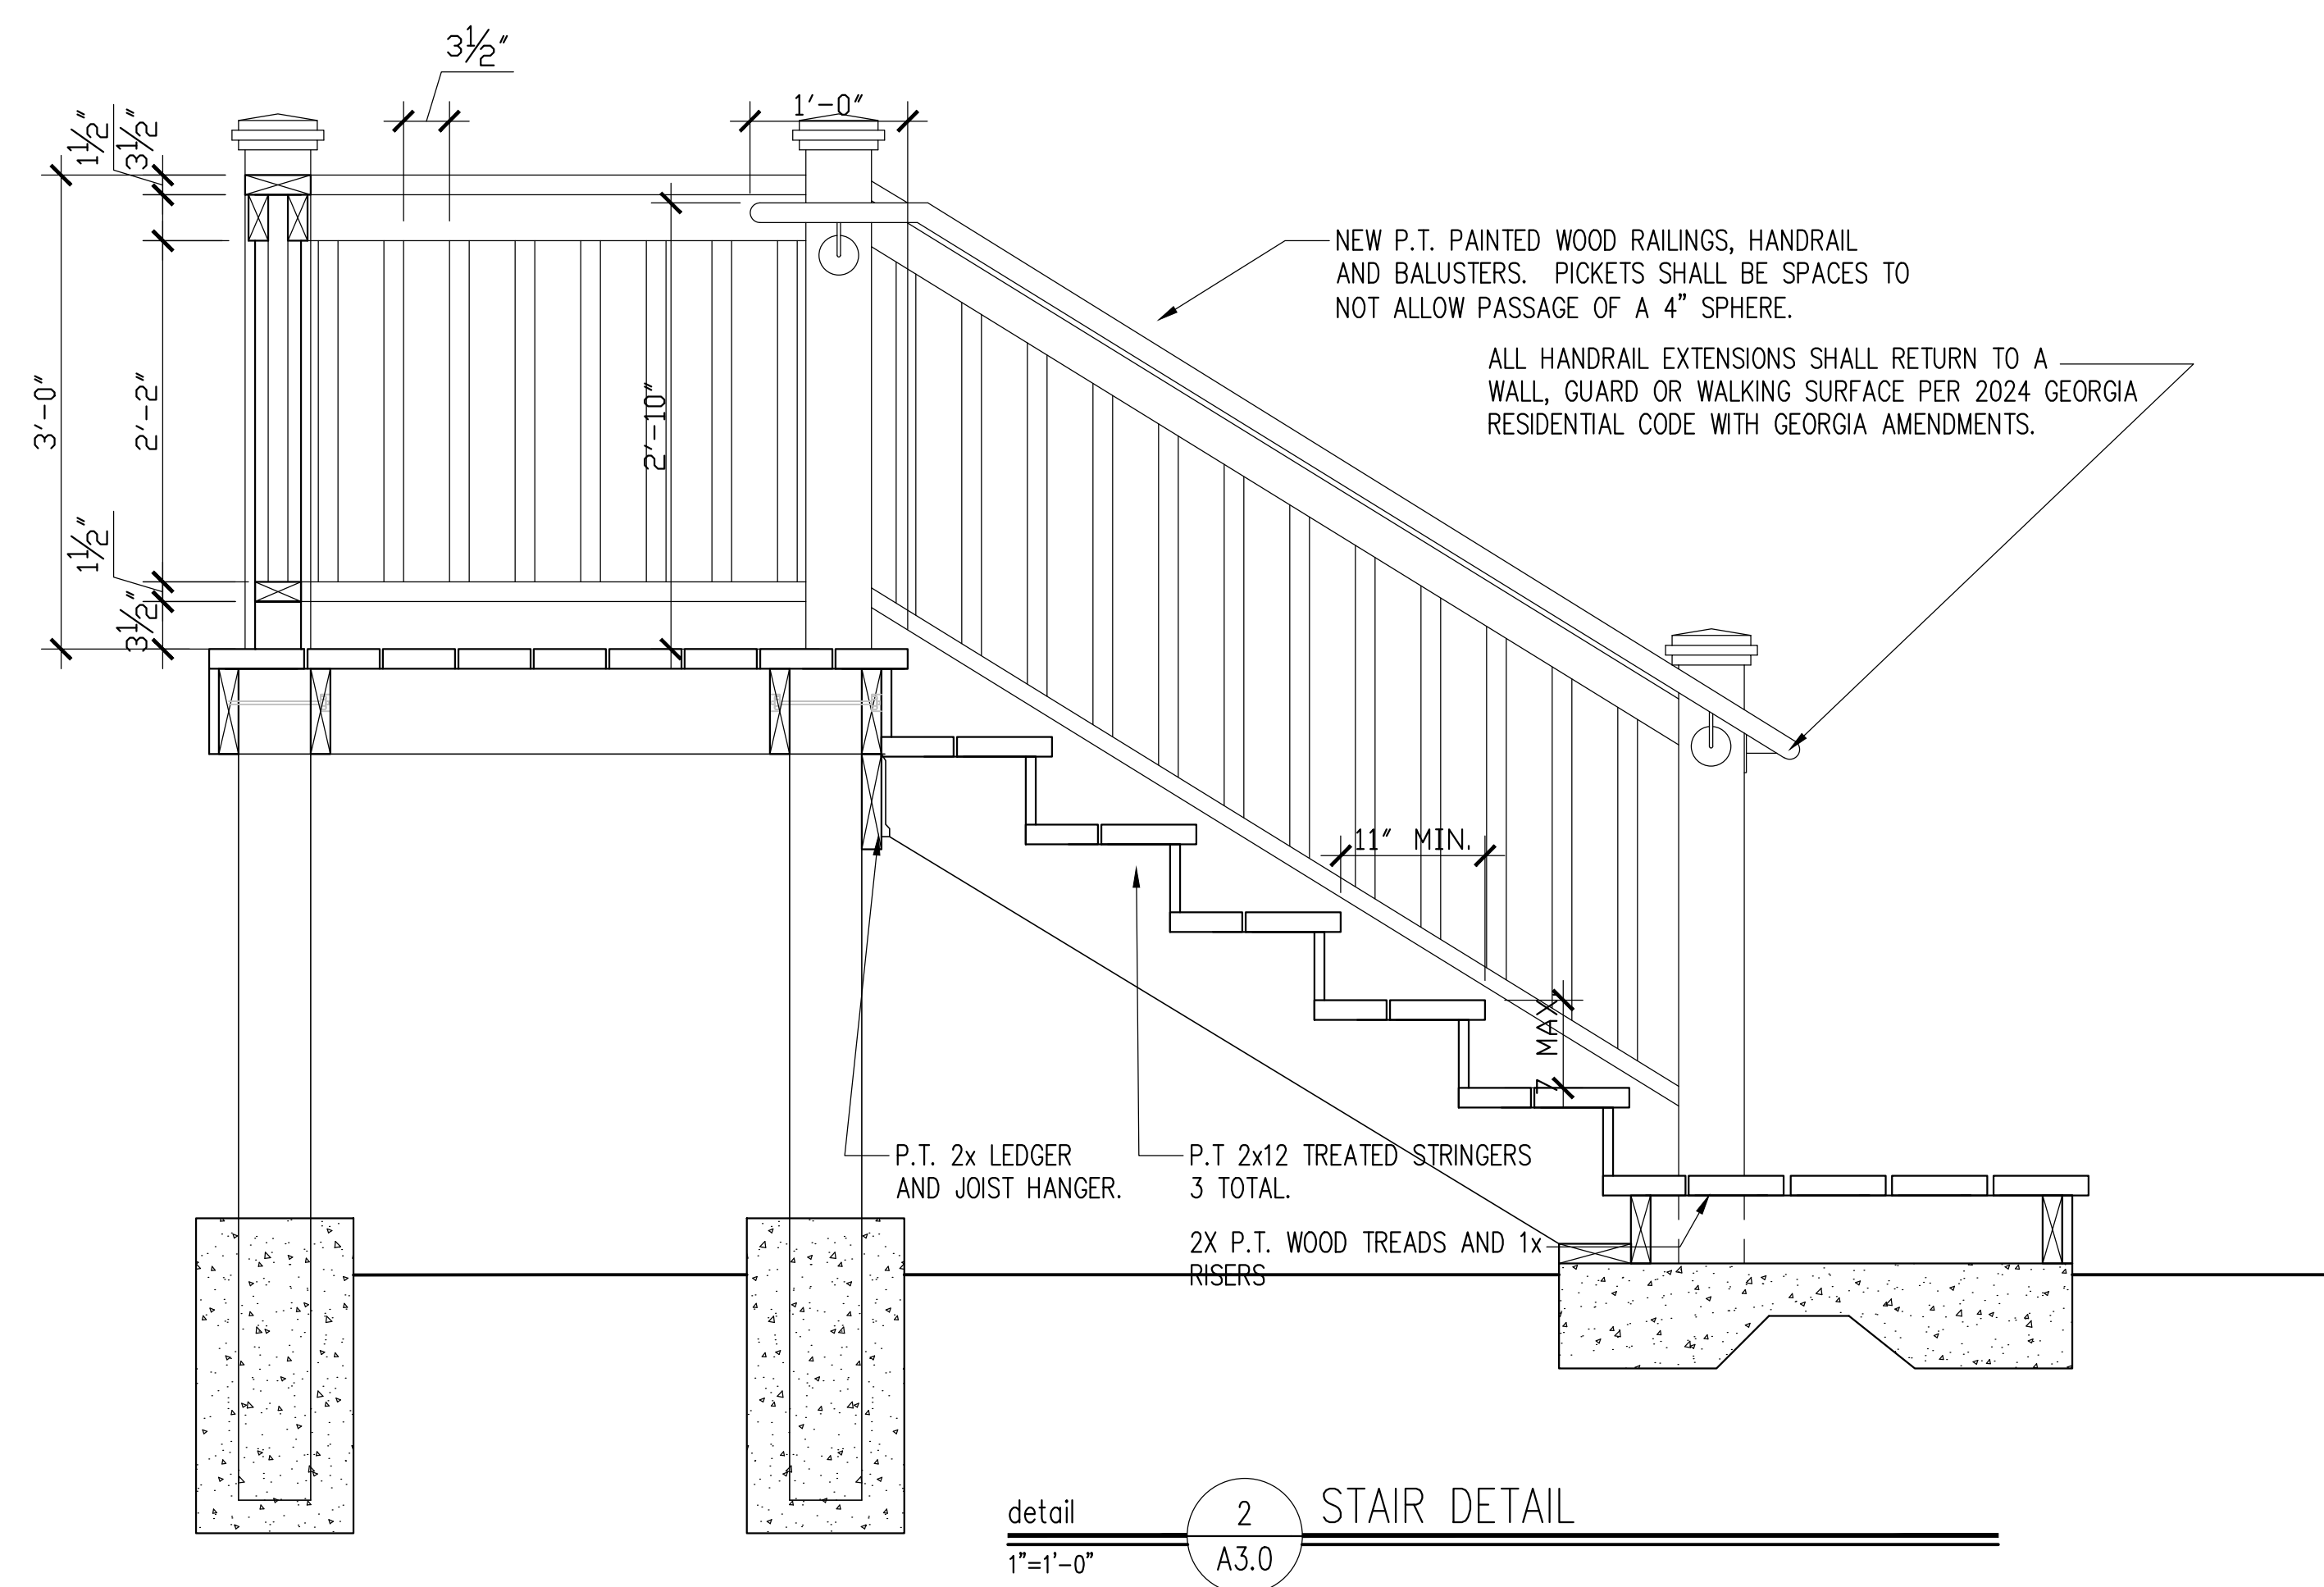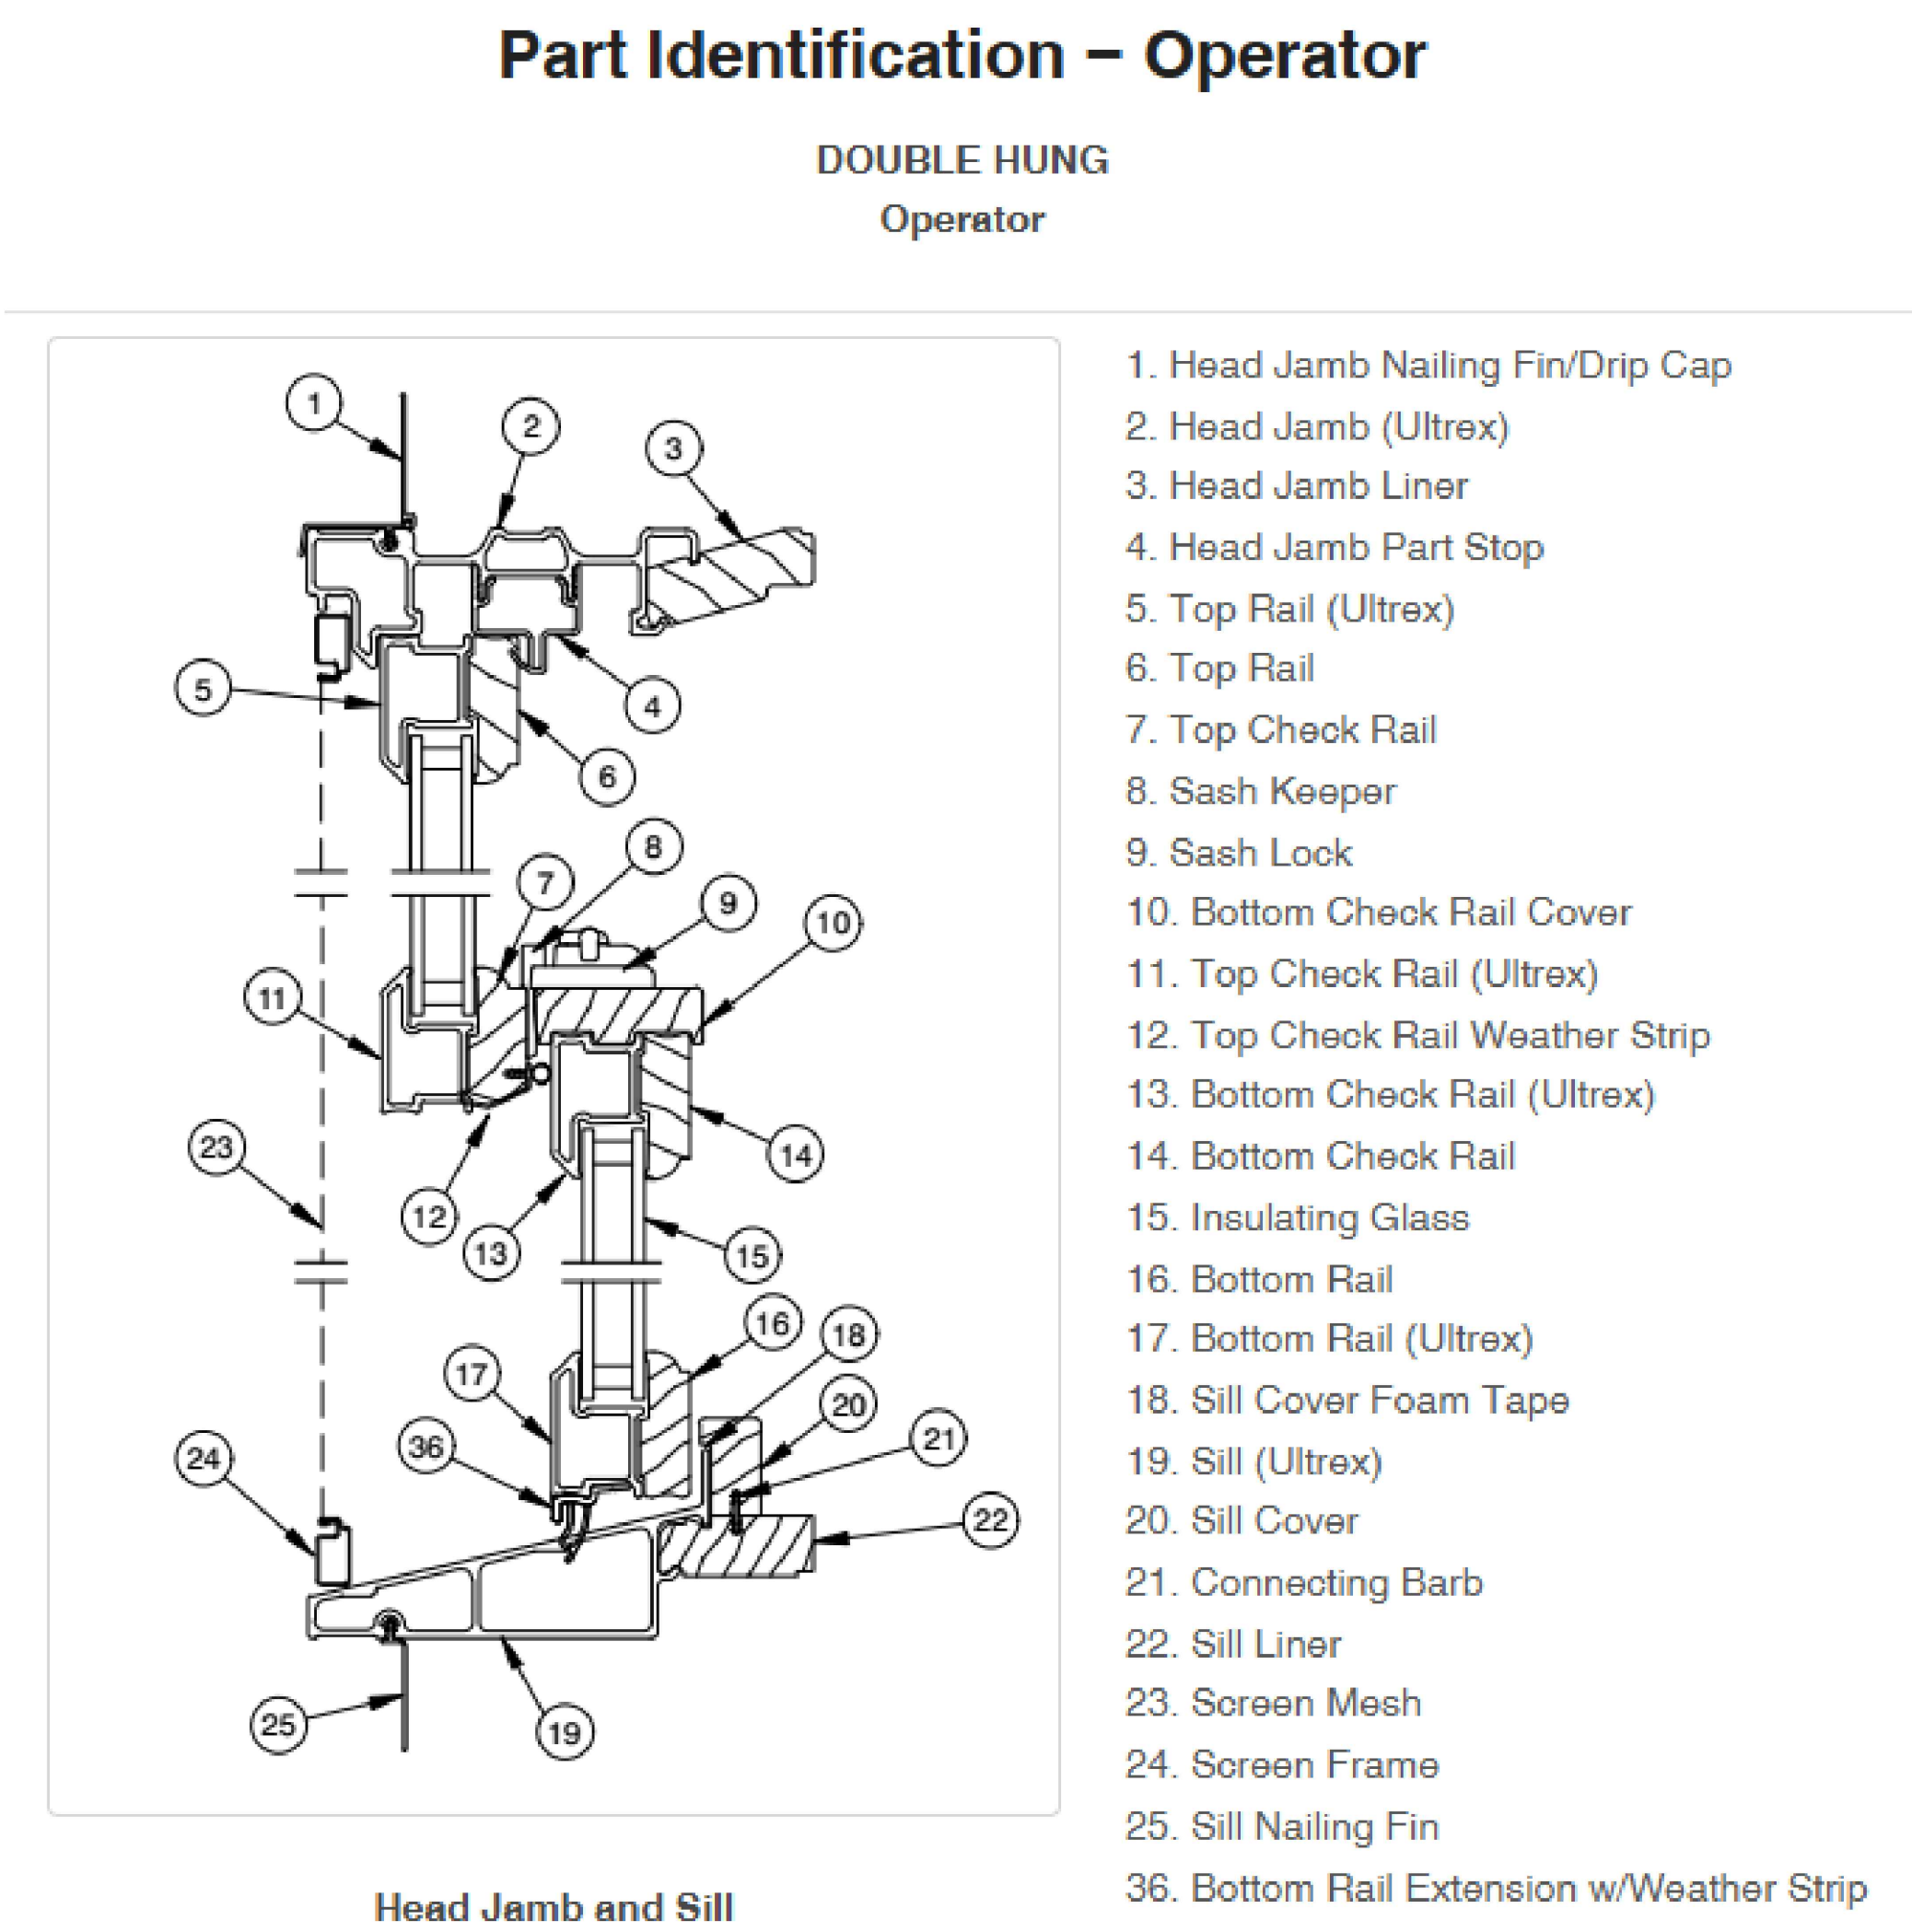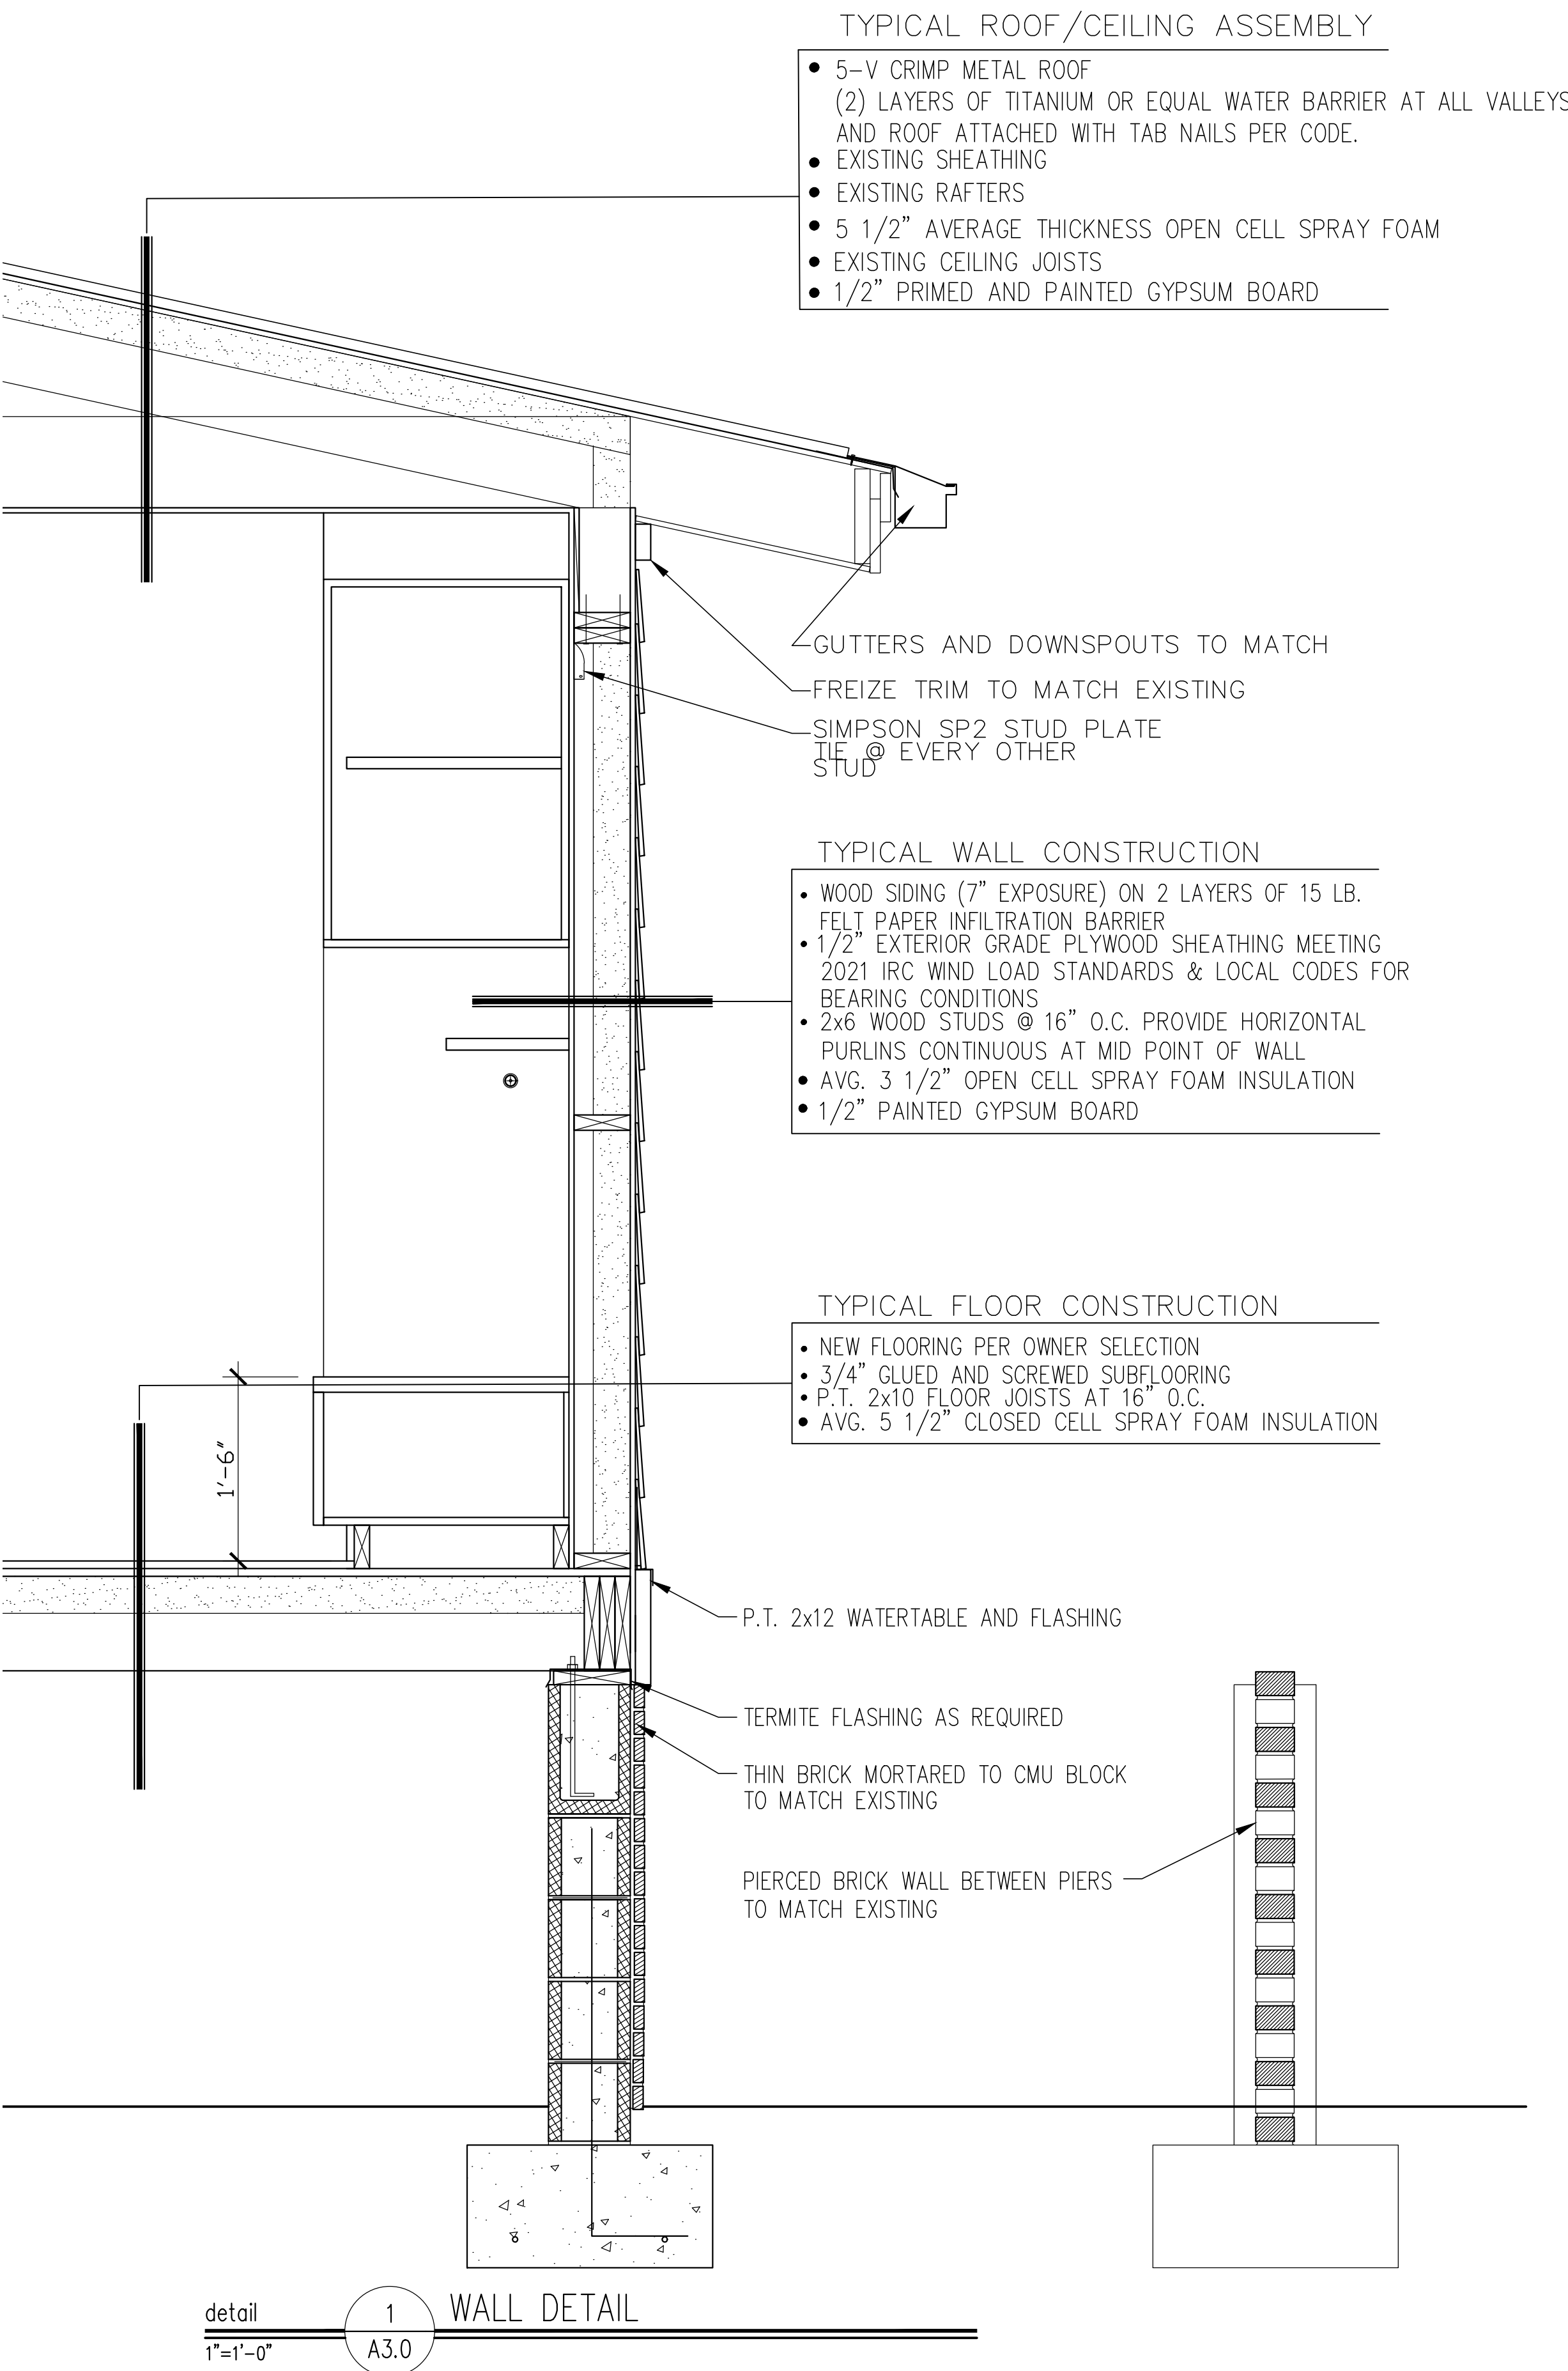

Renovations to:
Doerger Residence


114 West Bolton Street
Savannah, GA 31401

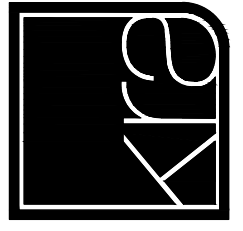

KRA architecture + design

KRA architecture + design
P.O. BOX 2047
Bluffton, SC 29910

t. 843.815.2021
www.krasc.com

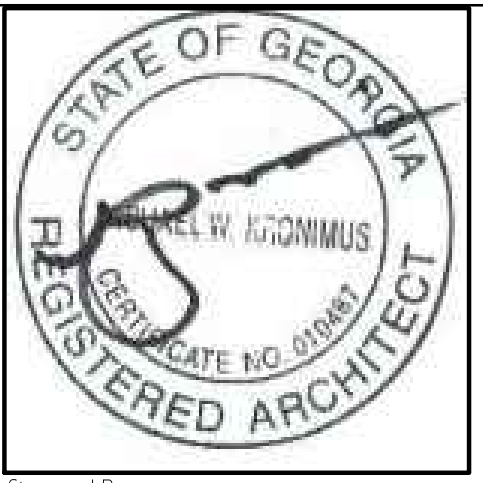

Stamped By: _____
Drawn By: _____
Checked By: _____
Date: 07.20.26

Revisions


NO.	REVISION	DATE
1	STAFF COMMENTS	08.06.26


Project No. 26124
File Name: _____
Drawing Title: _____

WALL DETAIL

Renovations to:
Doerger Residence

 114 West Bolton Street
Savannah, GA 31401




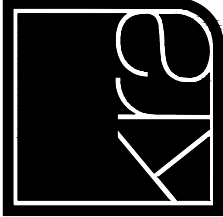

KRA architecture + design

KRA architecture + design
P O B O X 2 0 4 7
Bluffton, SC 29910

 t. 843.815.2021
www.krasc.com



Stamped By: _____

Drawn By: _____

Checked By: _____

Date: 07.20.26

Revisions

Project No: 26124

File Name: _____

Drawing Title: _____

ELECTRICAL
SCHMATICS

E1.1


Sheet No:

Scale:

ELECTRICAL SYMBOL LEGEND	
	CABLE OUTLET
	TELEPHONE/ ETHERNET OUTLET
	RECEPTACLE, ISA, 125V, 2 POLE 3 WIRE, GROUNDED, DUPLEX
	FLOOR DUPLEX RECEPTACLE
	GROUND-FAULT-CIRCUIT-INTERLIFT RECEPTACLE-USE SQUARE D QUICK GUARD FOR WP LOCATIONS
	RECEPTACLE, 50A, 220V, 2 POLE 3 WIRE, GROUNDED
	TOGGLE SWITCH, SINGLE POLE, 15A
	TOOGLE SWITCH, 3 WAY, 15A
	PUSH BUTTON (DOOR BELL/OHD)
	DOORBELL CHIME
	DIMMER SWITCH
	LIGHT FIXTURE, INCANDESCENT CEILING MOUNTED
	LIGHT FIXTURE, INCANDESCENT EXTERIOR FLOODS
	CEILING FAN W/ LIGHT- PROVIDE SEPERATE SWITCHES FOR F & L
	LIGHT FIXTURE - CHANDELIER W/ INCANDESCENT BULBS
	LED RECESSED LIGHT
	LIGHT FIXTURE - FLOURESCENT
	SMOKE ALARM - 110V ELEC. W/ CARBON MONOXIDE DETECTOR
	VANITY LIGHT
	VENT/LIGHT RECESSED CAN
	HEAT/VENT/LIGHT
	VENT/LIGHT ONLY
	SCONCE LIGHT
	ELECTRIC LANTERN

ELECTRICAL NOTES:

- MAIN FEED INTO HOUSE TO BE TRENCHED UNDERGROUND FROM SUPPLY POLE TO METER THEN MAIN DISCONNECT OUTSIDE.
- ALL SMOKE DETECTORS TO BE ELECTRIC POWERED WITH BATTERY BACKUP AND WIRED TO SET ALL ALARMS OFF IF ONE IS TRIPPED.
- ALL EXTERIOR, GARAGE, KITCHEN, LAUNDRY AND BATH OUTLETS TO BE GROUND FAULT CIRCUIT INTERRUPT EQUIPPED AND ON A SEPARATE CIRCUIT.
- ELECTRICAL DISCONNECTS ARE TO BE AT A/C UNIT, CONDENSING UNIT, AND WATER HEATER.
- HEAT VENT LIGHTS ARE TO BE ON A SEPARATE CIRCUIT.
- OUTLETS, INCLUDING PHONE AND CABLE, MAY BE ADDED OR CHANGED UPON OWNERS REQUEST.
- ELECTRICAL CONTRACTOR TO VERIFY EQUIPMENT TYPE AND SIZE.
- INSTALL LIGHTS IN ATTIC SPACE W/ SWITCH AT FOOT OF DISP. STAIRS
- ELECTRICAL SERVICE TO BE SIZED ACCORDINGLY BY THE ELECTRICAL SUB AND LOCATED IN THE FIELD
- A SUB-PANEL MAY NEED TO BE ADDED FOR ENOUGH CIRCUITS.
- HOUSE TO BE WIRED FOR A SECURITY SYSTEM.
- ALL KITCHEN OUTLETS ARE TO BE GFI EXCEPT APPLIANCE OUTLETS NOT EASILY ACCESSIBLE. NO POINT ALONG ANY WALL IS MORE THAN 24" FROM AN OUTLET (E3901.4.1)
- ARC FAULT BREAKERS ARE TO BE USED IN ALL BEDROOMS.
- IF GAS FIRED APPLIANCES ARE USED IN HOME, CARBON MONOXIDE ALARMS ARE NEEDED (IRC R315).
- A MAXIMUM OF 50W OR LED EQUIVALENT FOR EXTERIOR FIXTURES.

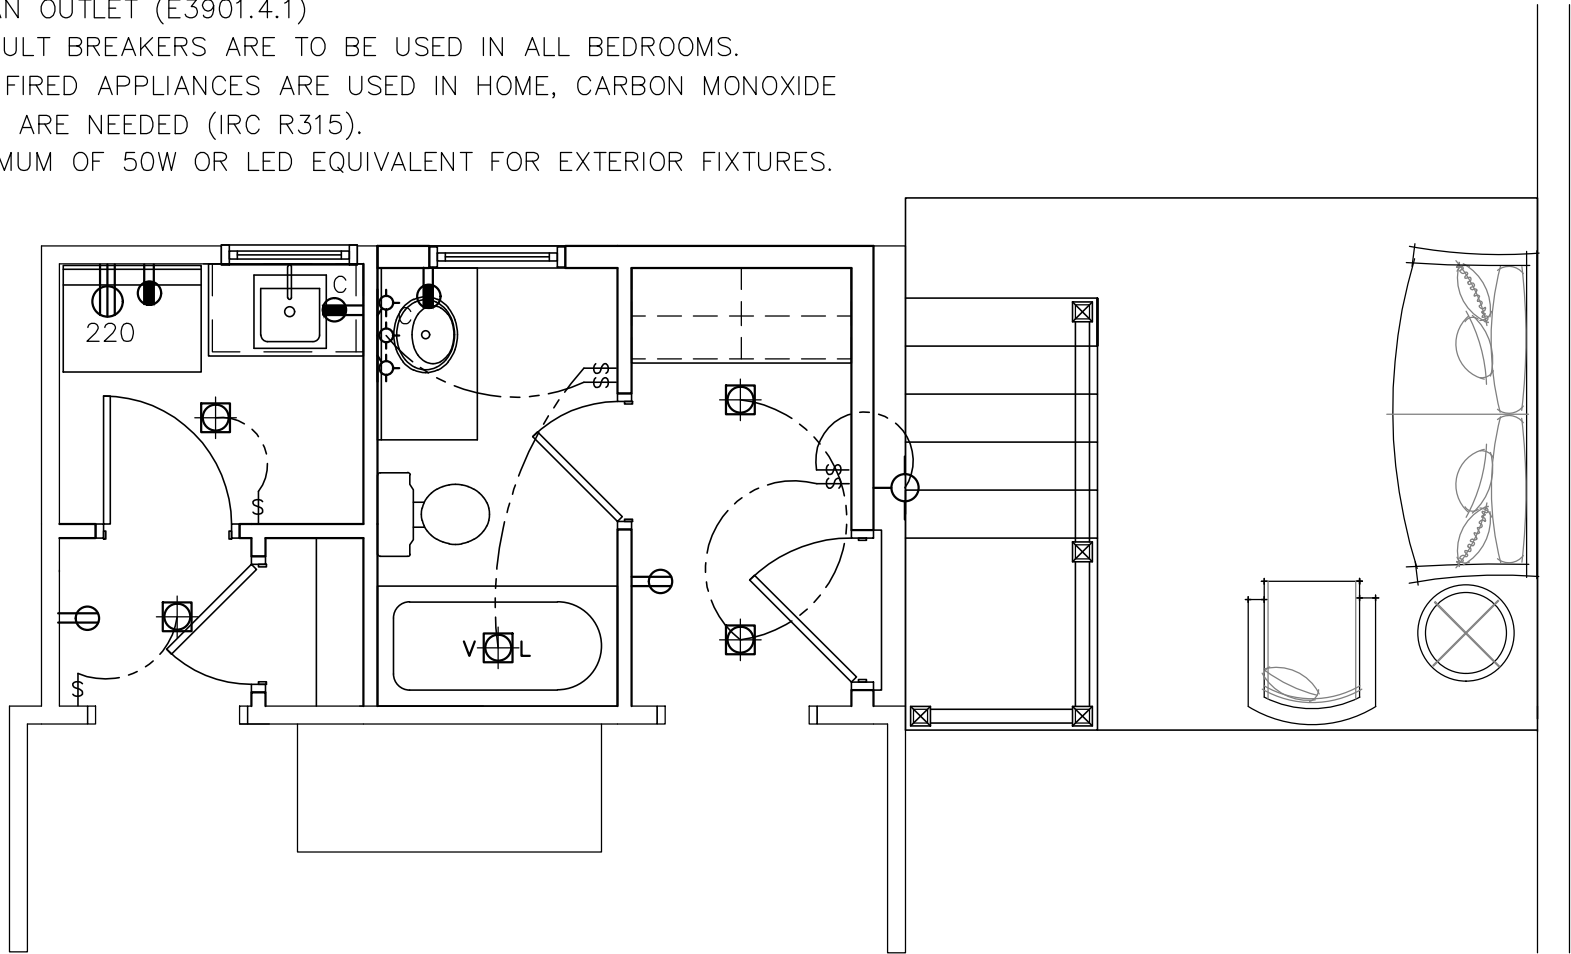

plan
1/4"=1'-0" 1 PROPOSED PARTIAL GROUND FLOOR
E1.1