

APPLICATION for
CERTIFICATE OF APPROPRIATENESS
Savannah's Historic Cuyler.Brownsville District

DRAWING INDEX		
SHEET NO.	LATEST ISSUE DATE	TITLE
A-0.0	27 FEBRUARY 2026	COVER SHEET: INDEX, GENERAL NOTES, SITE PLANS & PHOTOS
SURVEY	16 OCTOBER 2025	BY SHUPE SURVEYING COMPANY
A-0.1	27 FEBRUARY 2026	SITE PLANS: EXISTING AND PROPOSED
A-0.2		FOUNDATION PLAN AND NOTES
A-0.3		FRAMING PLANS AND NOTES
A-0.4		STRUCTURAL DETAILS
A-1.0	27 FEBRUARY 2026	EXISTING / DEMOLITION FLOOR AND ROOF PLANS
A-1.1	27 FEBRUARY 2026	PROPOSED FLOOR AND ROOF PLANS
A-1.2		LIGHTING AND ELECTRICAL PLANS
A-2.0	27 FEBRUARY 2026	EXISTING AND PROPOSED EXTERIOR ELEVATIONS, NORTH AND EAST
A-2.1	27 FEBRUARY 2026	EXISTING AND PROPOSED EXTERIOR ELEVATIONS, SOUTH AND WEST
A-3.0	27 FEBRUARY 2026	BUILDING SECTIONS
A-3.1		TYPICAL WALL SECTION

PROJECT DESCRIPTION:

PIN: 2-0066-47-018
ZONING: TR-1, CUYLER-BROWNSVILLE HISTORIC DISTRICT
PRINCIPAL BUILDING IS CONTRIBUTING STRUCTURE #274, BUILT IN 1909
OWENS WARD
FLOOD ZONE: 'X'


SEEKING CERTIFICATE OF APPROPRIATENESS FOR RESTORATION OF EXISTING RESIDENCE, 2-STORY ADDITION AT REAR AND NEW WOOD FENCING ALONG SIDE PROPERTY LINES AND LANE.

PROPOSED MATERIALS:


- WOOD SIDING AT HISTORIC STRUCTURE TO BE RESTORED. ~~CURRENT SIDING IS COVERED BY FAUX BRICK WRAP.~~
- ADDITION TO RECEIVE HARDIE BOARD SIDING, SMOOTH FINISH, SIDING EXPOSURE MUST BE AT LEAST 1" GREATER THAN ORIGINAL WOOD SIDING
- CMU PIER FOUNDATION WITH TEXTURED MASONRY PAINT FINISH, PAINTED HOGPEN 1X8 INFILL BETWEEN PIERS, SET BACK FROM FACE OF PIER
- ARCHITECTURAL ASPHALT SHINGLE ROOFING - ADDITION TO MATCH EXISTING
- ALUMINUM-CLAD WOOD WINDOWS: SIERRA PACIFIC WESTCHESTER SERIES, COLOR 'WHITE 001'
- THERMATRU SMOOTH-STAR FIBERGLASS COMPOSITE DOOR, PAINTED
- STAINED WOOD DECK, RAILING AND STAIR AT REAR ENTRY
- STAINED WOOD FENCING

EXTERIOR MATERIALS:

NEW WINDOWS (AT ADDITION)
SIERRA PACIFIC WESTCHESTER / EXTERIOR FINISH: 001 WHITE
SINGLE-HUNG
SIMULATED DIVIDED LIGHT: 7/8" TRADITIONAL

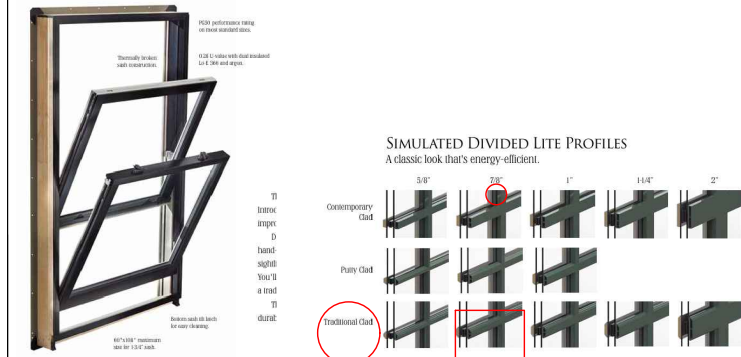

NEW RAILINGS AT FRONT PORCH (PAINTED)
VINTAGE WOODWORKS P2 HANDRAIL WITH
1.5" SQUARE BALUSTERS AND
SLOPED-TOP BOTTOM RAIL


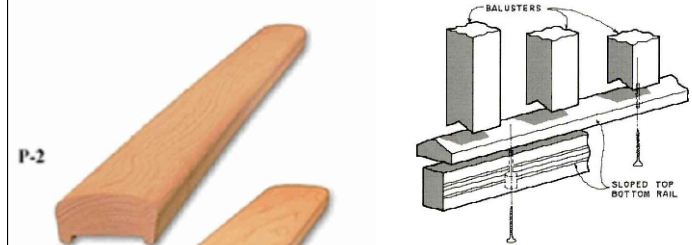


**P2 Handrail,
Plain Subrail, and
Sloped-top Bottom Rail**

This Rail Set fits
3/4" - 1-5/8" (net) Balusters.

Installed Handrail/Subrail is 2-1/2" wide
x 1-7/8" tall. Installed Bottom Rail is 2-
5/8" wide x 3-5/8" tall.

NEW DOOR (AT ADDITION)
THERMA-TRU SMOOTHSTAR
STYLE NO. S4305XN
HALF LITE, 1 PANEL SHAKER
WITH SQUARE STICKING
PAINTED FINISH
BLACK HARDWARE
CLEAR GLASS

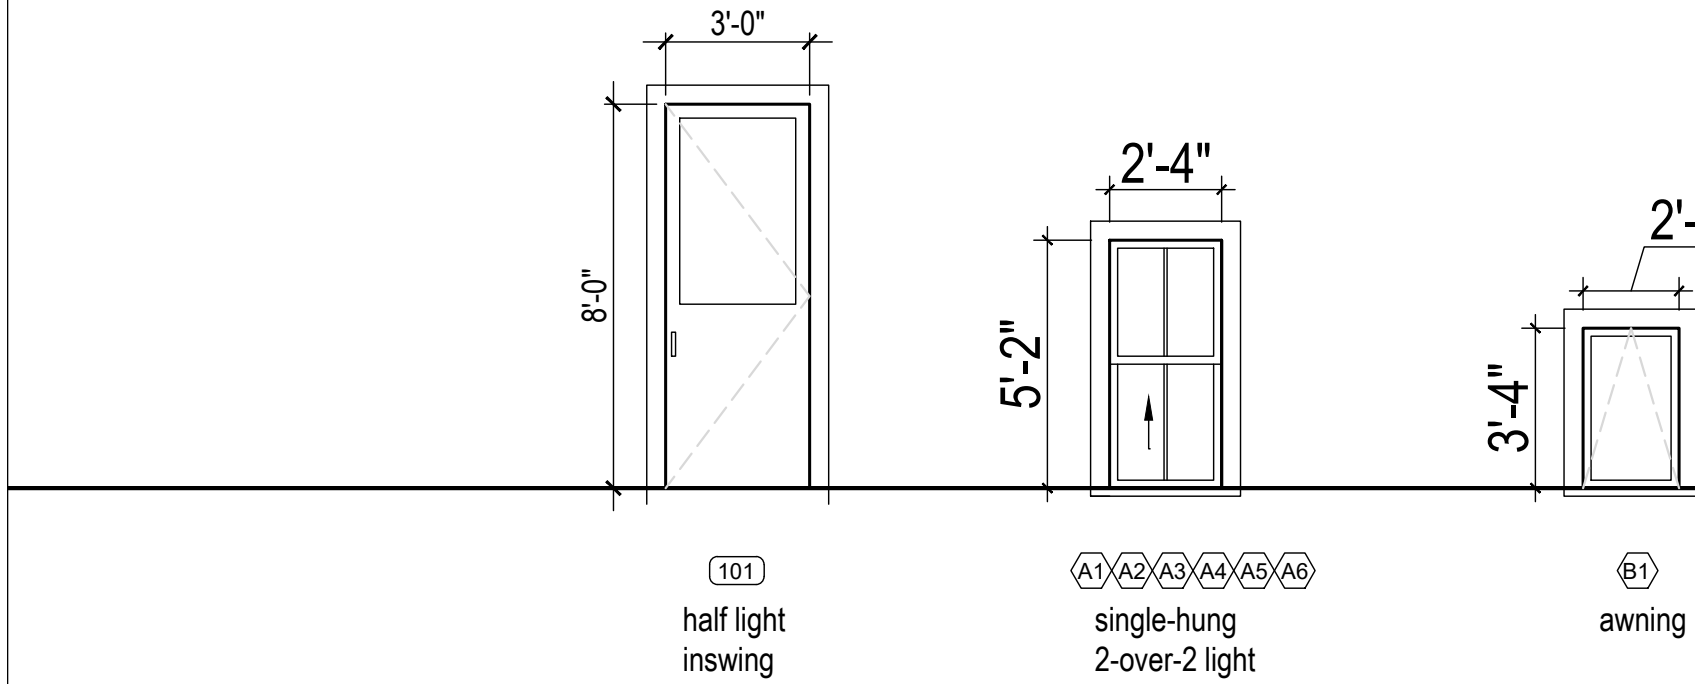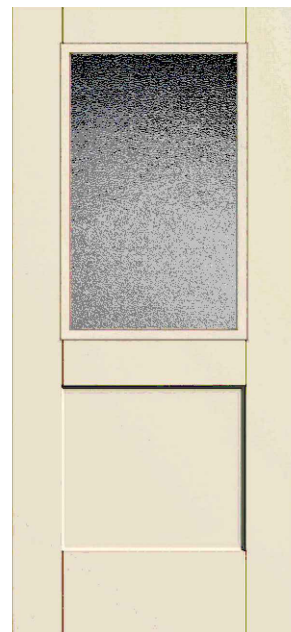

BUILDING CODE DATA (CITY OF SAVANNAH, GEORGIA):

Mandatory Codes, City of Savannah:
International Residential Code, 2018 Edition, with Georgia Amendments (2020)
International Fire Code, 2018 Edition (No Georgia Amendments)
International Plumbing Code, 2018 Edition, with Georgia Amendments (2020)
International Mechanical Code, 2018 Edition, with Georgia Amendments (2020)
International Fuel Gas Code, 2018 Edition, with Georgia Amendments (2020)
National Electrical Code, 2017 Edition (No Georgia Amendments)
International Energy Conservation Code, 2015 Edition, with Georgia Supplements and Amendments (2020)
International Swimming Pool and Spa Code, 2018 Edition, with Georgia Amendments (2020)
Life Safety Code (NFPA 101), 2018
ADA Standards for Accessible Design, 2010

DESIGNS SHALL BE BASED UPON THE FOLLOWING CRITERIA:
- 3-SECOND WIND GUST: 135 MPH
- WIND EXPOSURE 'B'
- SEISMIC DESIGN CATEGORY: 'C'


REQUIREMENTS FOR NEW WINDOWS, DOORS AND SKYLIGHTS:
- NEGATIVE DESIGN PRESSURE: DP 40 OR HIGHER
- SOLAR HEAT GAIN COEFFICIENT 0.30 OR LOWER
- U-FACTOR: 0.50 OR LOWER

ROOFING:
METAL ROOFING MATERIALS SHALL BE NATURALLY CORROSION RESISTANT OR PROVIDED WITH CORROSION RESISTANCE IN ACCORDANCE WITH TABLE LISTED IN SSTD 10-99, CHAPTER 5. FOR PANEL SYSTEMS, 2 ROWS OF FASTENERS SHALL BE USED ALONG THE EAVES, HIPS AND RIDGES. THE FIRST ROW SHOULD BE WITHIN 2- TO 3- INCHES OF THE EDGE AND THE NEXT ROW 3- TO 4-INCHES FROM THE FIRST. OTHER FASTENING TO BE PER IRC AND MANUFACTURER'S INSTALLATION INSTRUCTIONS. ALL SCREWS AND OTHER FASTENERS TO BE CORROSION RESISTANT.

GENERAL NOTES:

- ALL WORK SHALL BE ACCOMPLISHED IN ACCORDANCE WITH THE SPECIFIED BUILDING CODES, BY COMPANIES AND/OR INDIVIDUALS PROPERLY LICENSED TO PERFORM SUCH WORK. IT IS THE RESPONSIBILITY OF THE CONTRACTOR AND HIS/HER SUB-CONTRACTORS TO BUILD A STRUCTURALLY SOUND WATERPROOF STRUCTURE, FREE FROM MATERIAL DEFECTS, THAT CONFORMS TO LOCAL BUILDING CODES AND AREA RESTRICTIONS.
- IT IS UNDERSTOOD THAT THE CONTRACTOR(S) HAVE READ AND UNDERSTAND ALL DRAWINGS, SPECIFICATIONS, AND ANY APPLICABLE CODES UNDER WHICH THE BUILDING IS TO BE CONSTRUCTED. THE ARCHITECT WAIVES ANY AND ALL RESPONSIBILITY AND LIABILITY FOR PROBLEMS WHICH ARISE FROM THE FAILURE TO FOLLOW THE CONSTRUCTION DOCUMENTS OR THE DESIGN INTENT THEY CONVEY.
- THE CONTRACTOR SHALL FAMILIARIZE HIM(HER)SELF WITH THE EXISTING CONDITIONS AND NOTIFY THE OWNER AND ARCHITECT IN WRITING IF ANY DISCREPANCIES OR INCONSISTANCIES BETWEEN THE CONTRACT DOCUMENTS AND EXISTING CONDITIONS ARE DISCOVERED, PRIOR TO SUBMITTING A BID AND BEGINNING CONSTRUCTION.
- IN CASE OF A CONFLICT BETWEEN DRAWINGS AND SPECIFICATIONS, THE MORE RIGID REQUIREMENTS SHALL BE ASSUMED UNTIL A RULING IS MADE BY THE ARCHITECT OR ENGINEER.
- THE GENERAL CONTRACTOR SHALL BE RESPONSIBLE FOR THE COORDINATION OF ALL MECHANICAL, ELECTRICAL, AND PLUMBING SYSTEMS. ALL WORK TO BE IN COMPLIANCE WITH CURRENTLY ADOPTED MECHANICAL, ELECTRICAL AND PLUMBING CODES.
- THE CONTRACTOR WILL BE RESPONSIBLE FOR OBTAINING ALL REQUIRED PERMITS AND INSPECTIONS TO INSURE THE SAFETY, INTEGRITY, AND COMPLETION OF THIS PROJECT. THE ARCHITECT SHALL BE PROVIDED A FULL COPY OF THE PERMITTED DRAWINGS WITH COMMENTS BY THE LOCAL BUILDING AUTHORITIES UPON COMPLETION OF THEIR REVIEW. THE ARCHITECT/ENGINEER, AS REQUIRED, WILL PROVIDE ANY ADDITIONAL DETAILS, CLARIFICATIONS AND COMMENTS IN DIRECT RESPONSE TO THOSE ON THE ISSUED PERMIT DRAWINGS.
- THE CONTRACTOR IS RESPONSIBLE FOR SCHEDULING REQUIRED INSPECTIONS AND TESTS.
- THE CONTRACTOR SHALL PROVIDE ALL NECESSARY BLOCKING, BACKING, FRAMING, STRUCTURAL STEEL SUPPORT, HANGERS, AND OTHER SUPPORT FOR ALL FIXTURES, EQUIPMENT, MILLWORK, CABINETRY, STONE, HANDRAILS, FURNISHINGS, DECORATIVE LIGHTING AND ALL OTHER ITEMS REQUIRING SAME.
- ALL WORK AND/OR MATERIALS, ASSEMBLIES, PRODUCTS AND FINISHES SHALL BE PERFORMED/INSTALLED PER MANUFACTURER'S RECOMMENDATIONS.
- ALL FINISHES, INCLUDING PAINT, ARE TO BE PURCHASED FROM SPECIFIED MANUFACTURER. ALL SUBSTITUTION REQUESTS MUST BE SUBMITTED TO THE ARCHITECT IN WRITING.
- DIMENSIONS SHALL TAKE PRECEDENCE OVER SCALE. IN ORDER TO IDENTIFY CONFLICTS WITH EXISTING CONSTRUCTION AND DIMENSIONAL ERROR, DIMENSIONAL LAYOUT SHALL BE VERIFIED IN THE FIELD PRIOR TO PROCEEDING WITH THE WORK. THE ARCHITECT SHALL BE NOTIFIED OF ANY DIMENSIONS REQUIRING CORRECTION. DIMENSIONS ARE TO FACE OF WALL FINISH UNLESS OTHERWISE NOTED.
- CONTRACTOR SHALL REMOVE FROM SITE AND DISCARD ALL CONSTRUCTION DEBRIS AT APPROVED DISPOSAL SITE.
- CONTRACTOR SHALL ENSURE SAFE PASSAGE OF PERSONS AROUND AREA OF CONSTRUCTION. PROVIDE TEMPORARY BARRICADES TO PROTECT THE GENERAL PUBLIC FROM INJURY DUE TO CONSTRUCTION WORK.

VICINITY MAP:

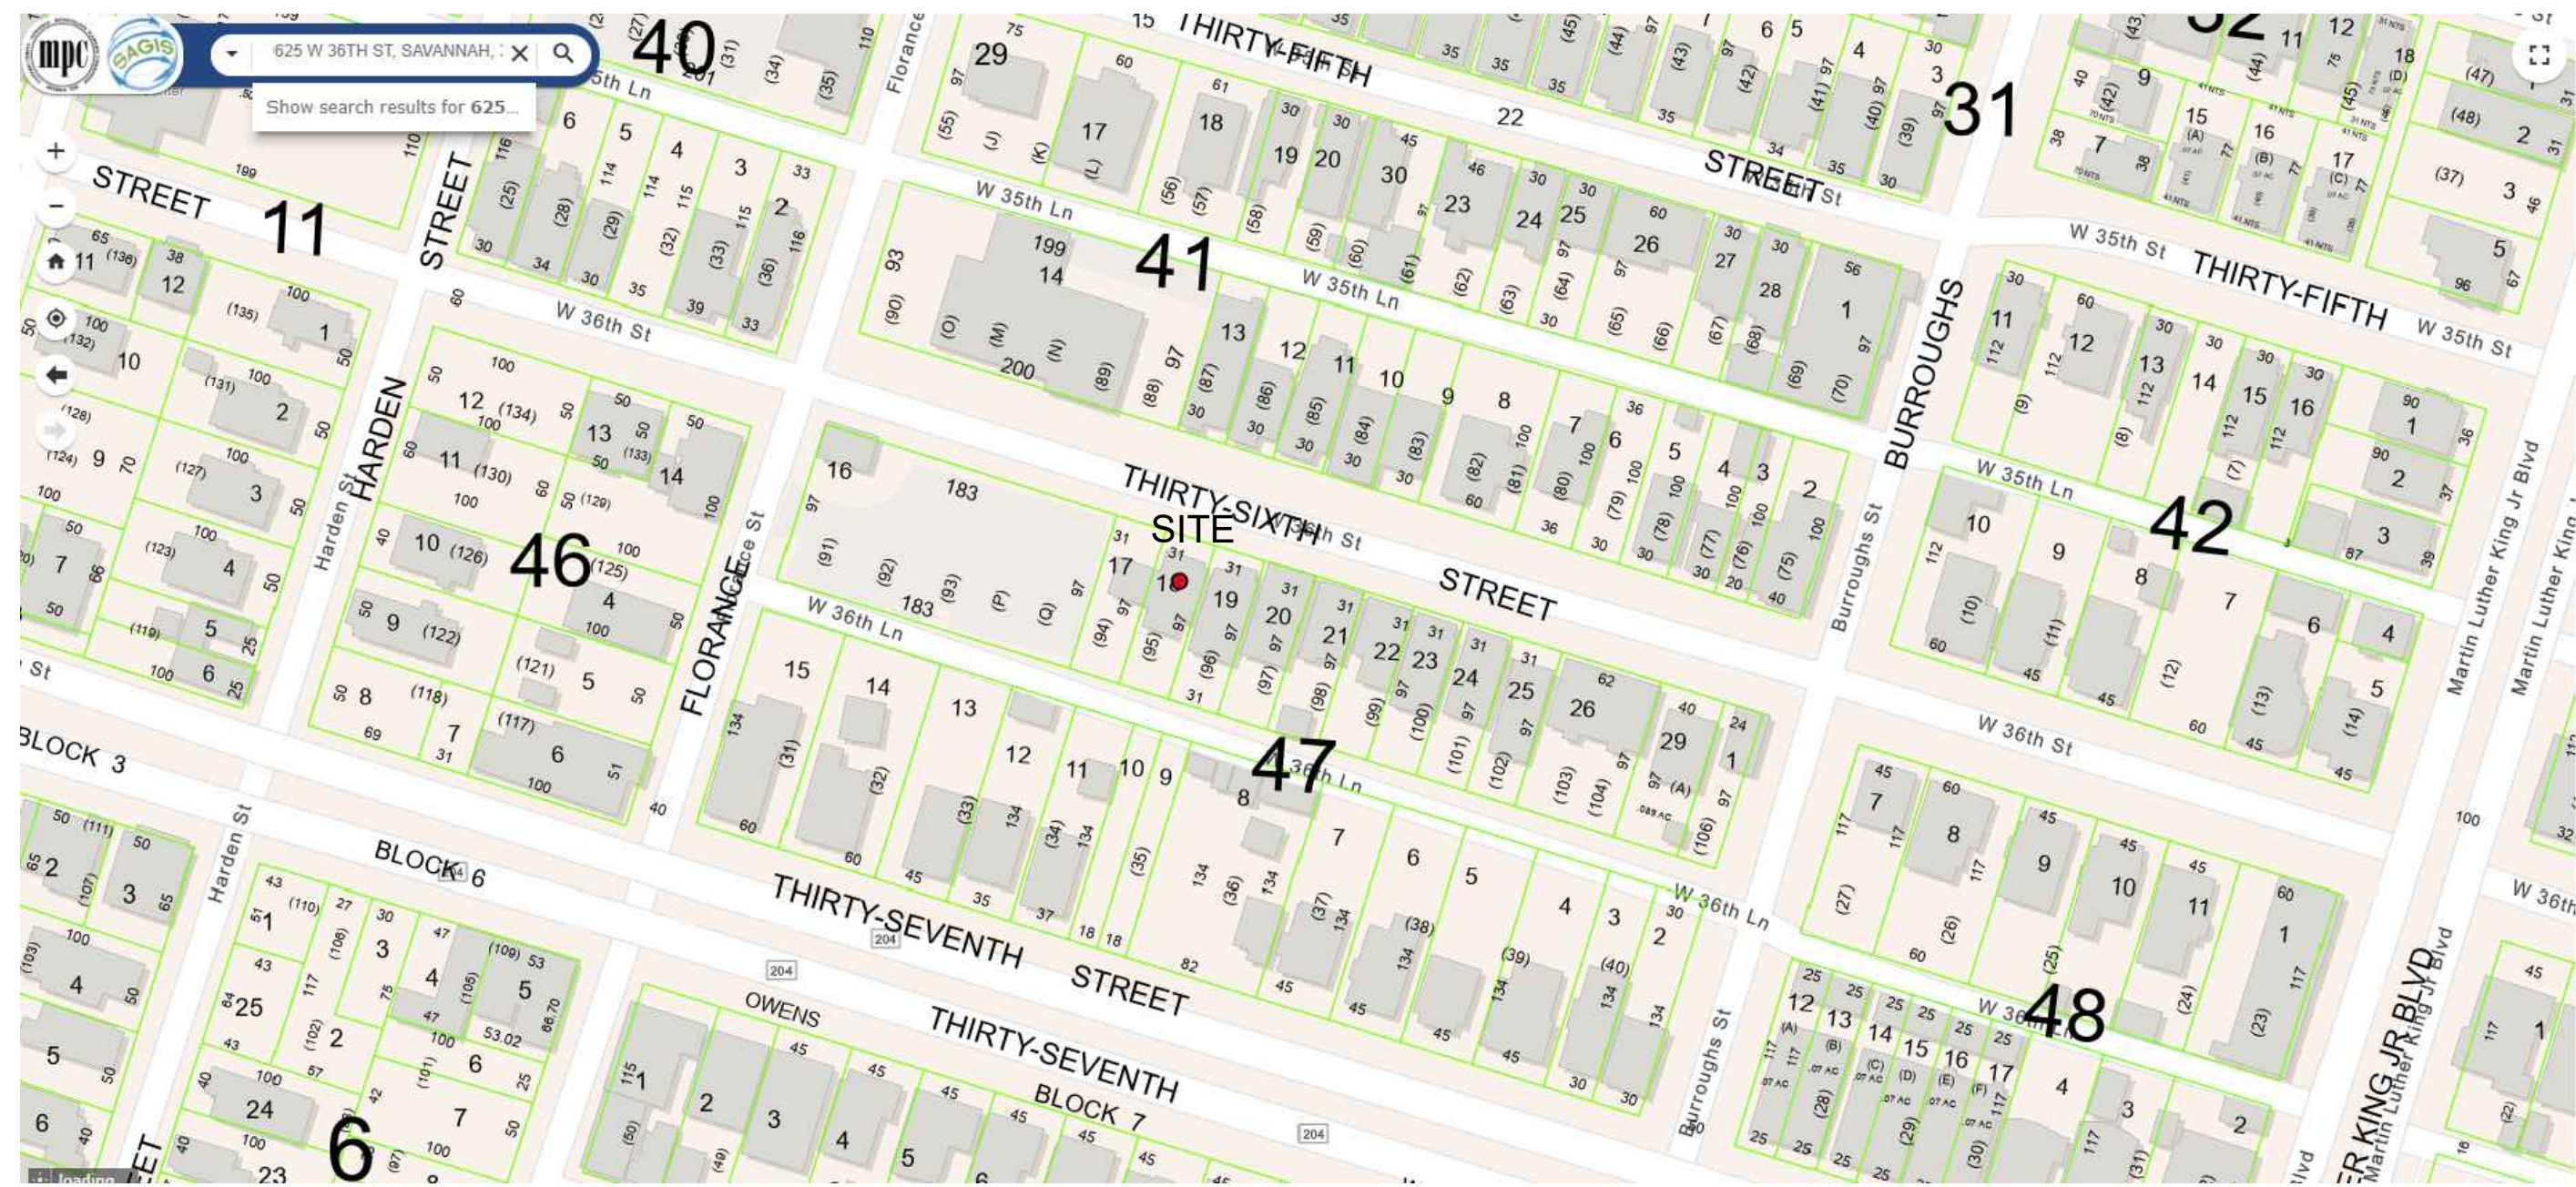

SITE PHOTOS



FRONT:




REAR:



EXISTING WINDOWS TO BE REPAIRED (TYPICAL CONDITION)



seal

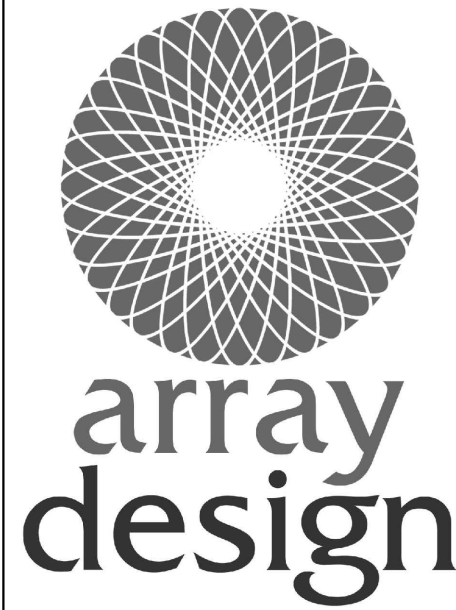

SHAUNA
KUCERA
Registered Architect
912.228.9088

M. DIAB RESIDENCE
625 W. 36TH STREET
SAVANNAH, GEORGIA 31415

Revisions:

A-0.0 27 FEBRUARY 2026


Date: 23 february 2026
Title:

COVER SHEET:
SITE PLAN
& PROJECT
INFORMATION


Drawing No.

A-0.0

NOT RELEASED FOR CONSTRUCTION

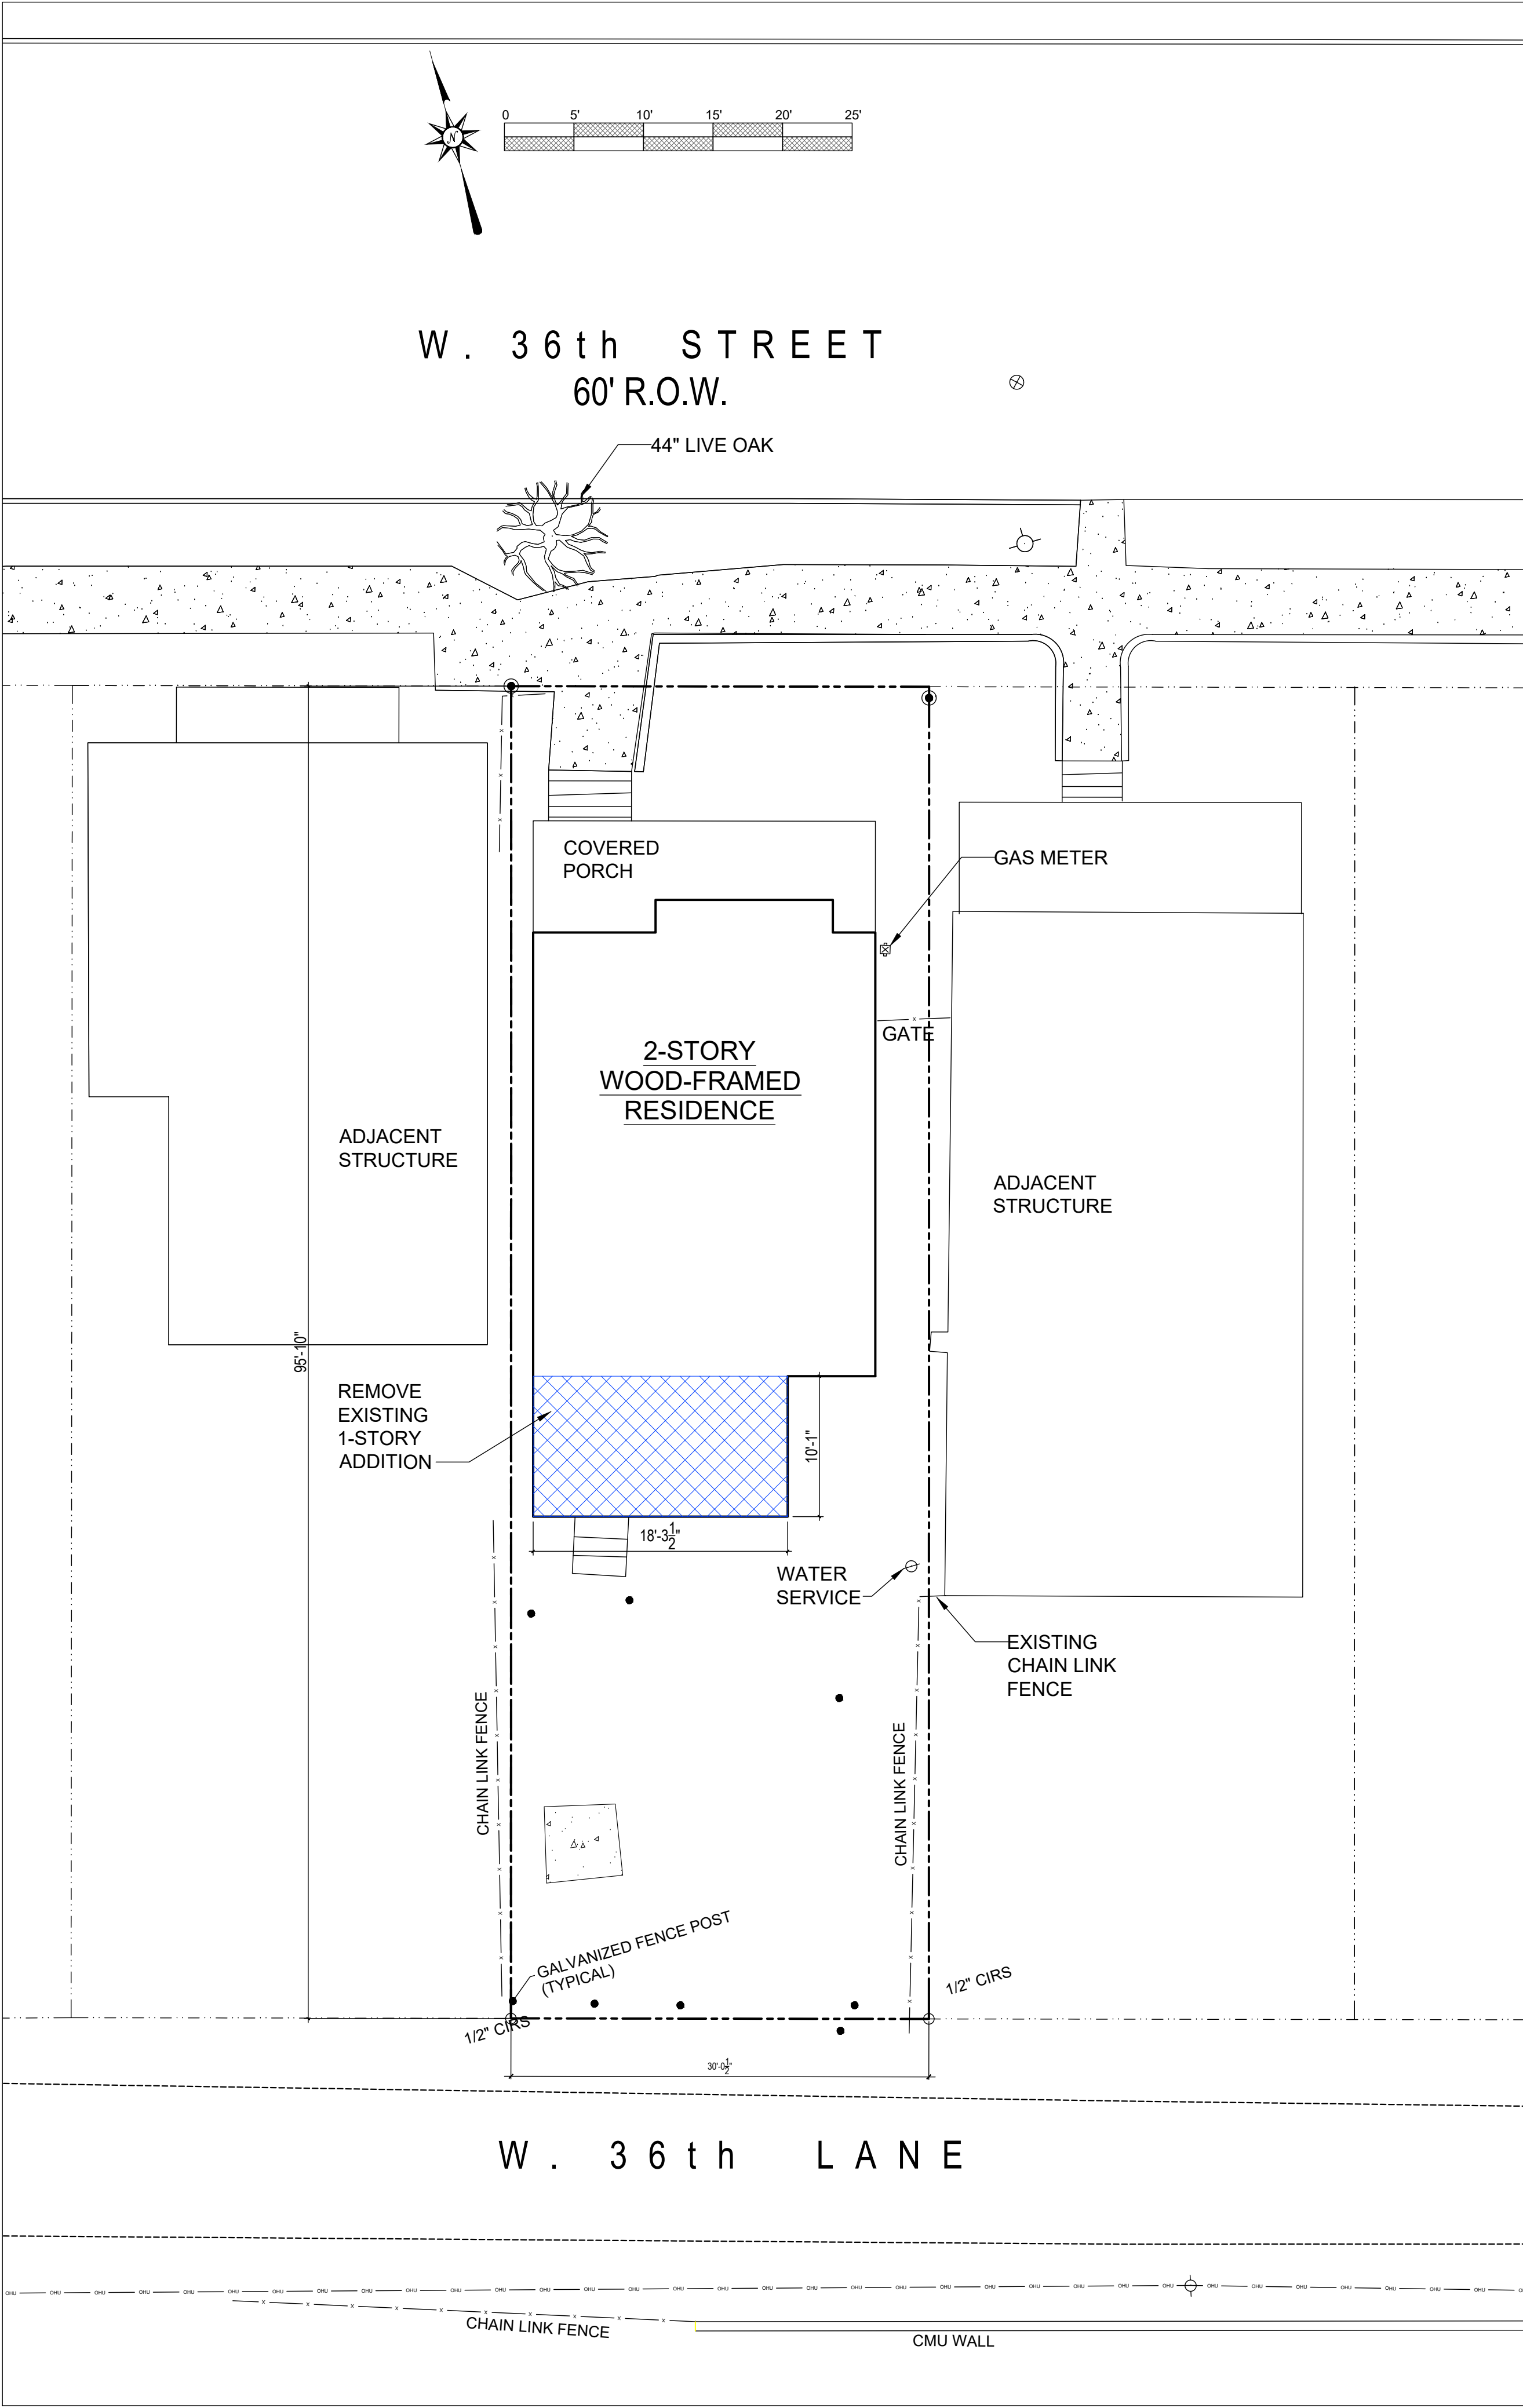


1 SITE PLAN: EXISTING
SCALE: 1/8" = 1'-0"

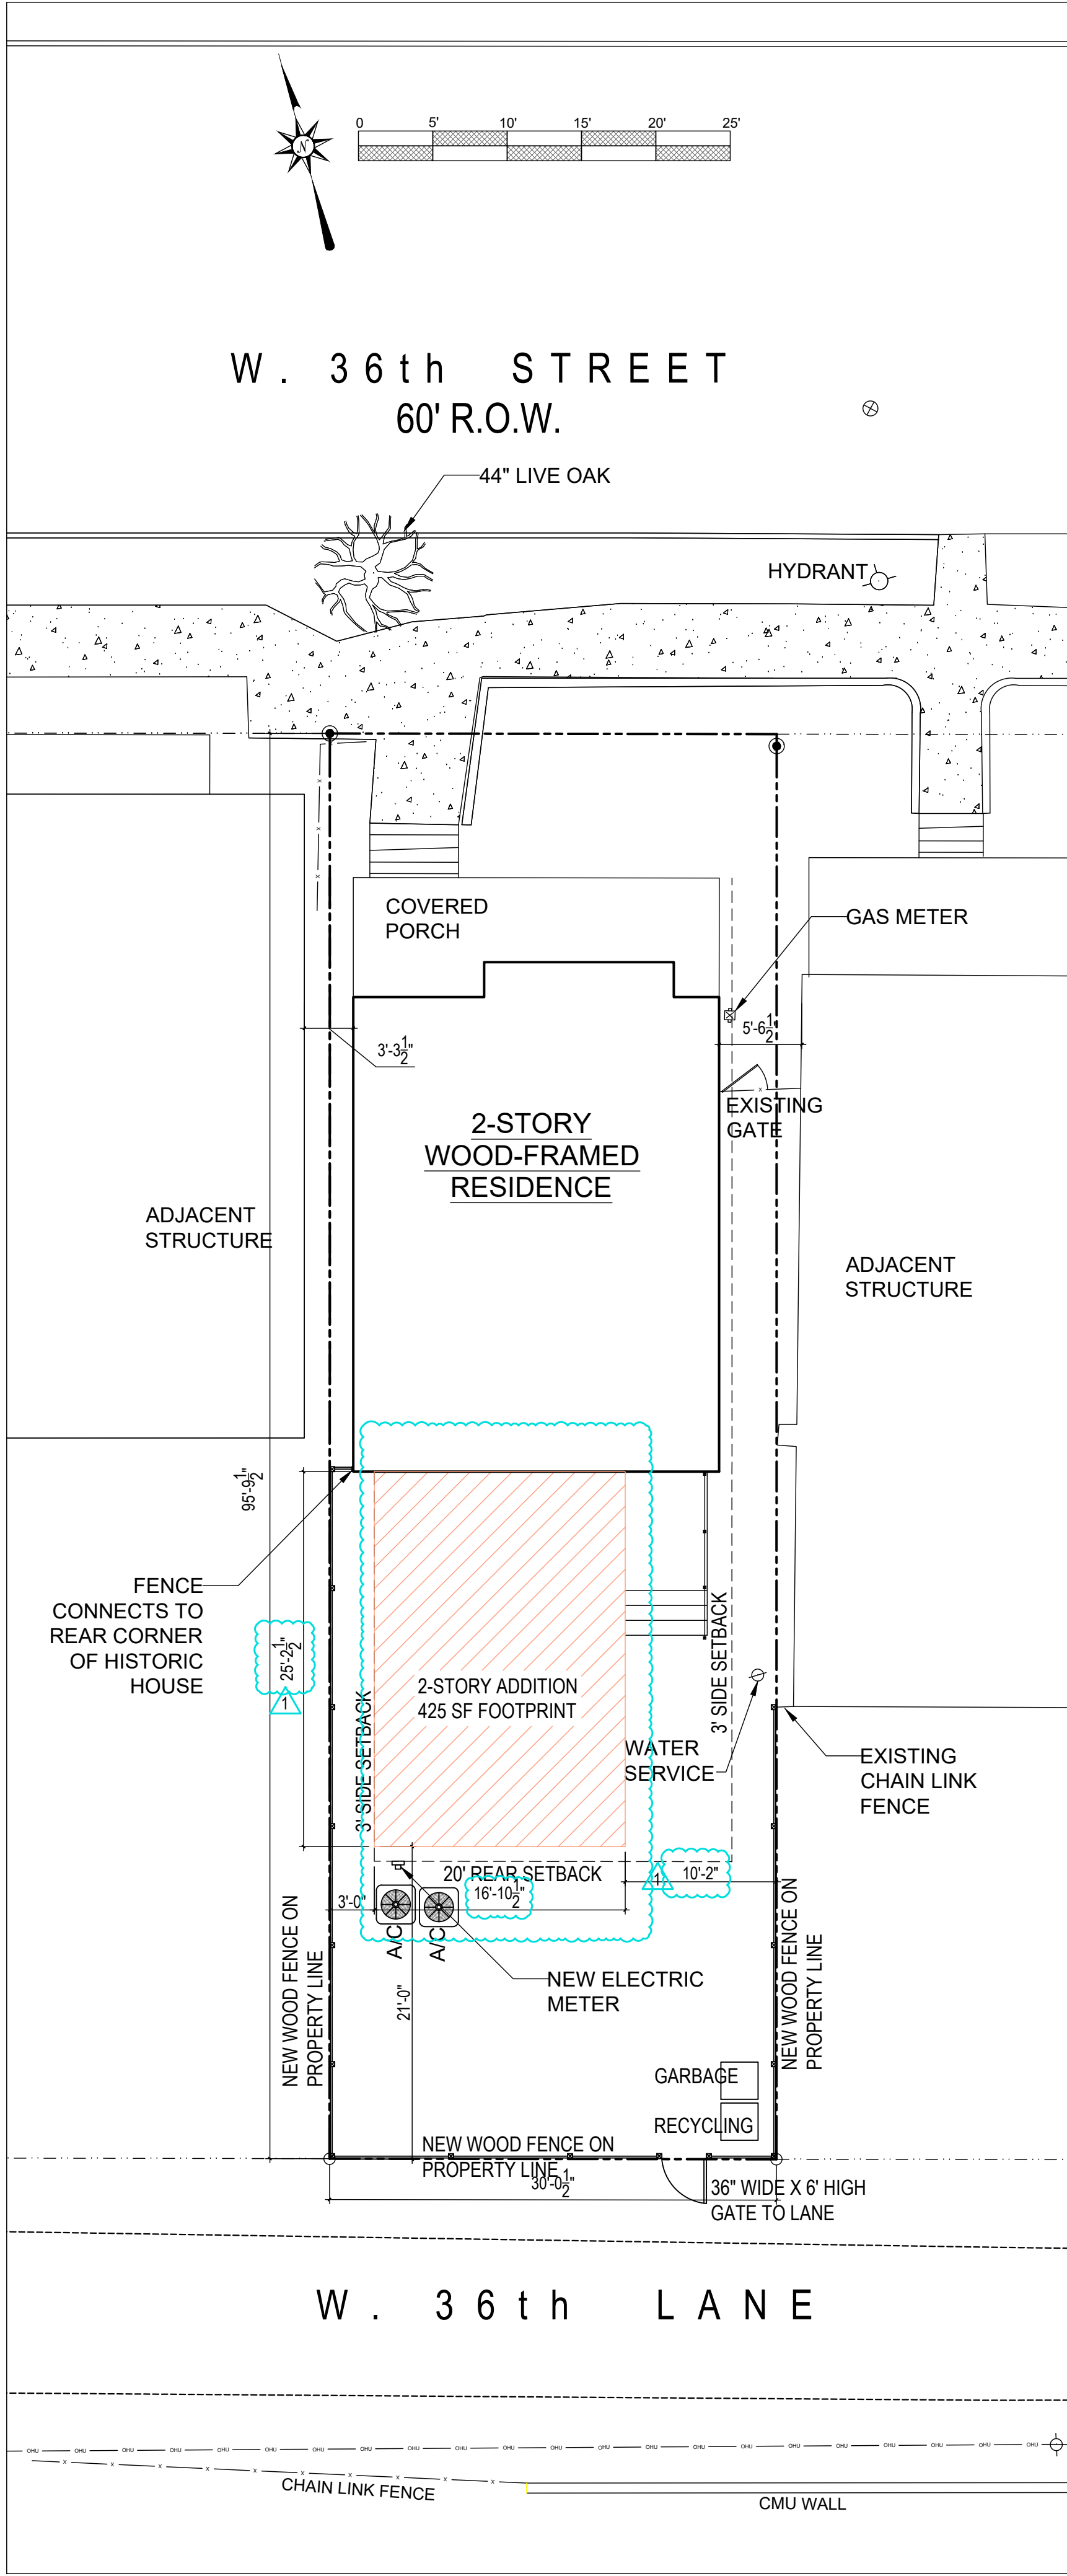


2 SITE PLAN: PROPOSED
SCALE: 1/8" = 1'-0"

LOT COVERAGE
EXISTING

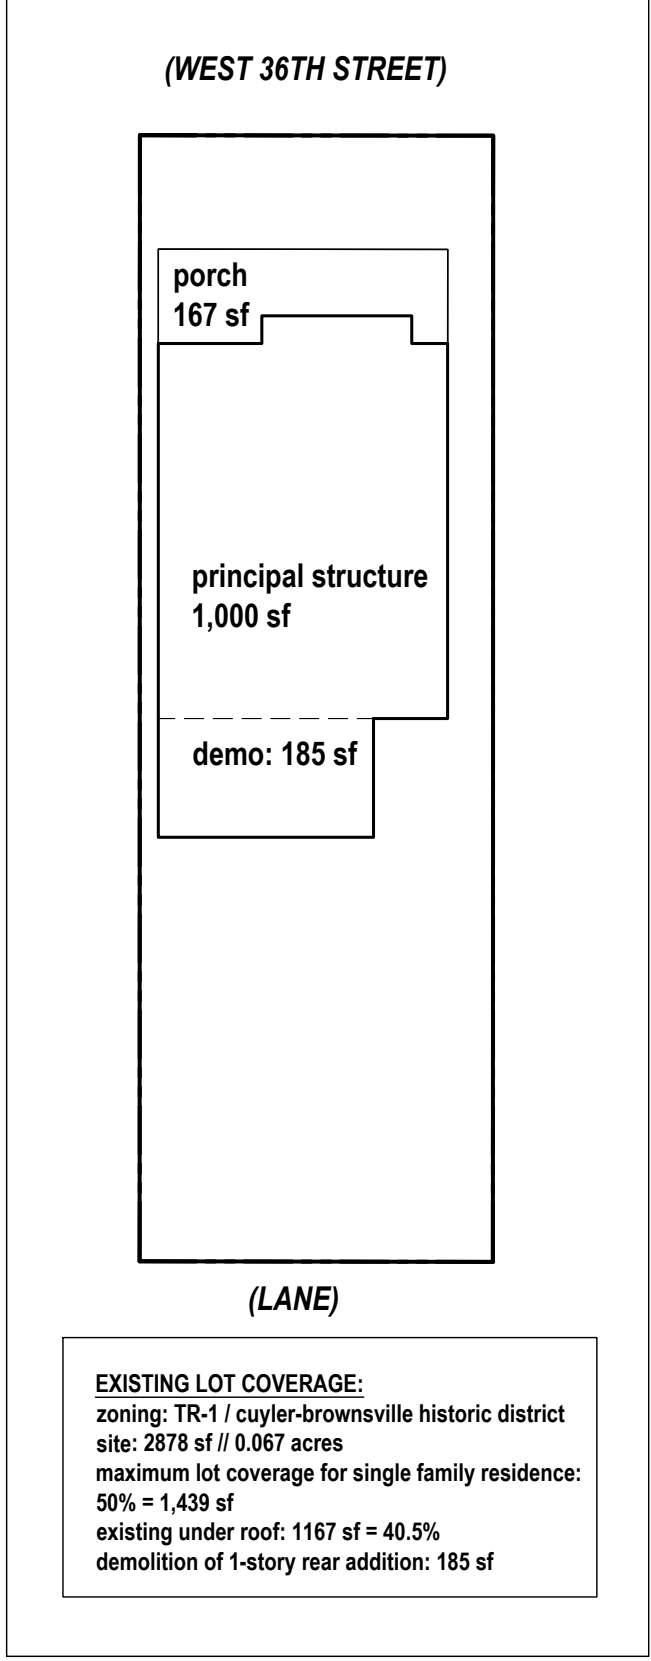

LOT COVERAGE
PROPOSED

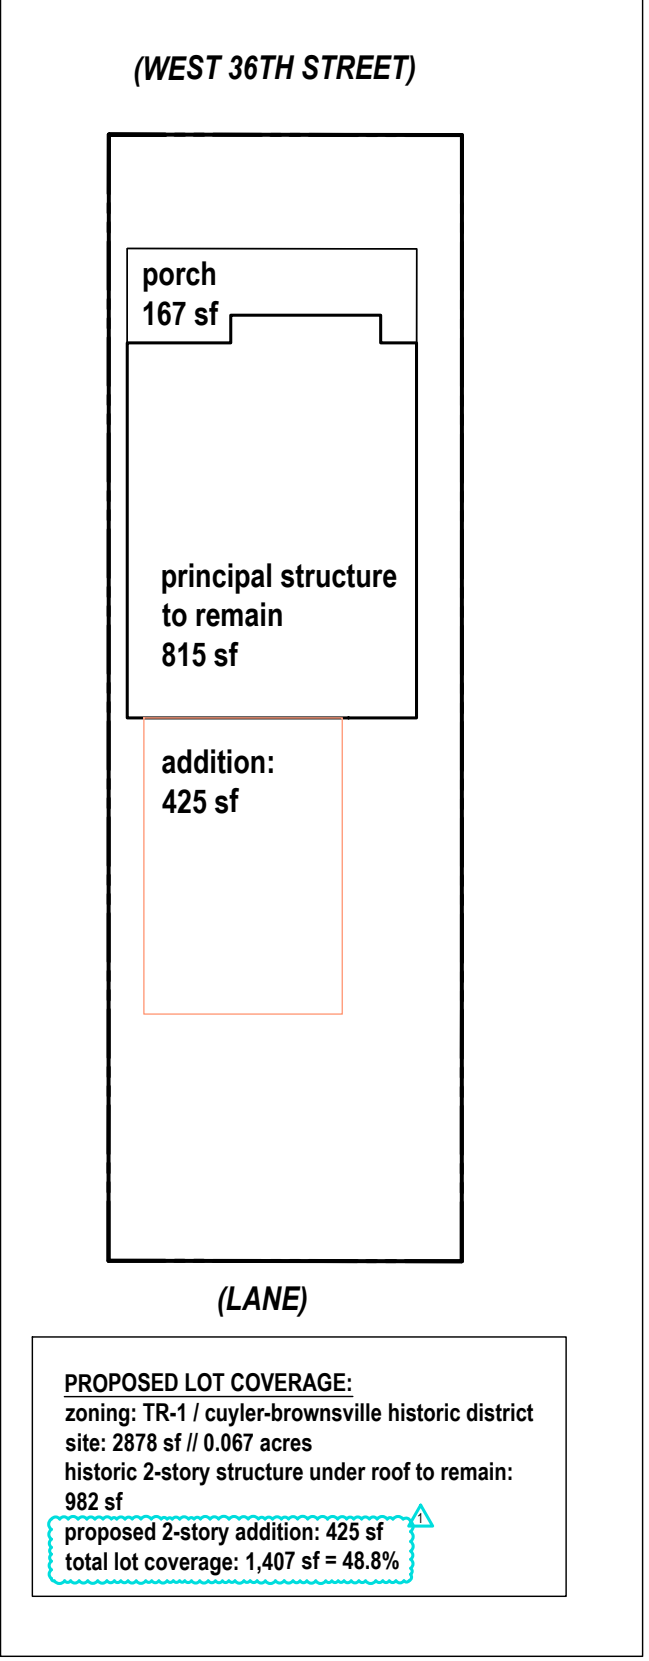

seal



SHAUNA
KUCERA
Registered Architect
912.228.9088

 
M. DIAB RESIDENCE
625 W. 36TH STREET
SAVANNAH, GEORGIA 31415

 
Revisions:
27 FEBRUARY 2026


Date: 23 february 2026
Title:
SITE PLANS:
EXISTING AND
PROPOSED

Drawing No.
A-0.1

NOT RELEASED FOR CONSTRUCTION





 = DEMOLITION

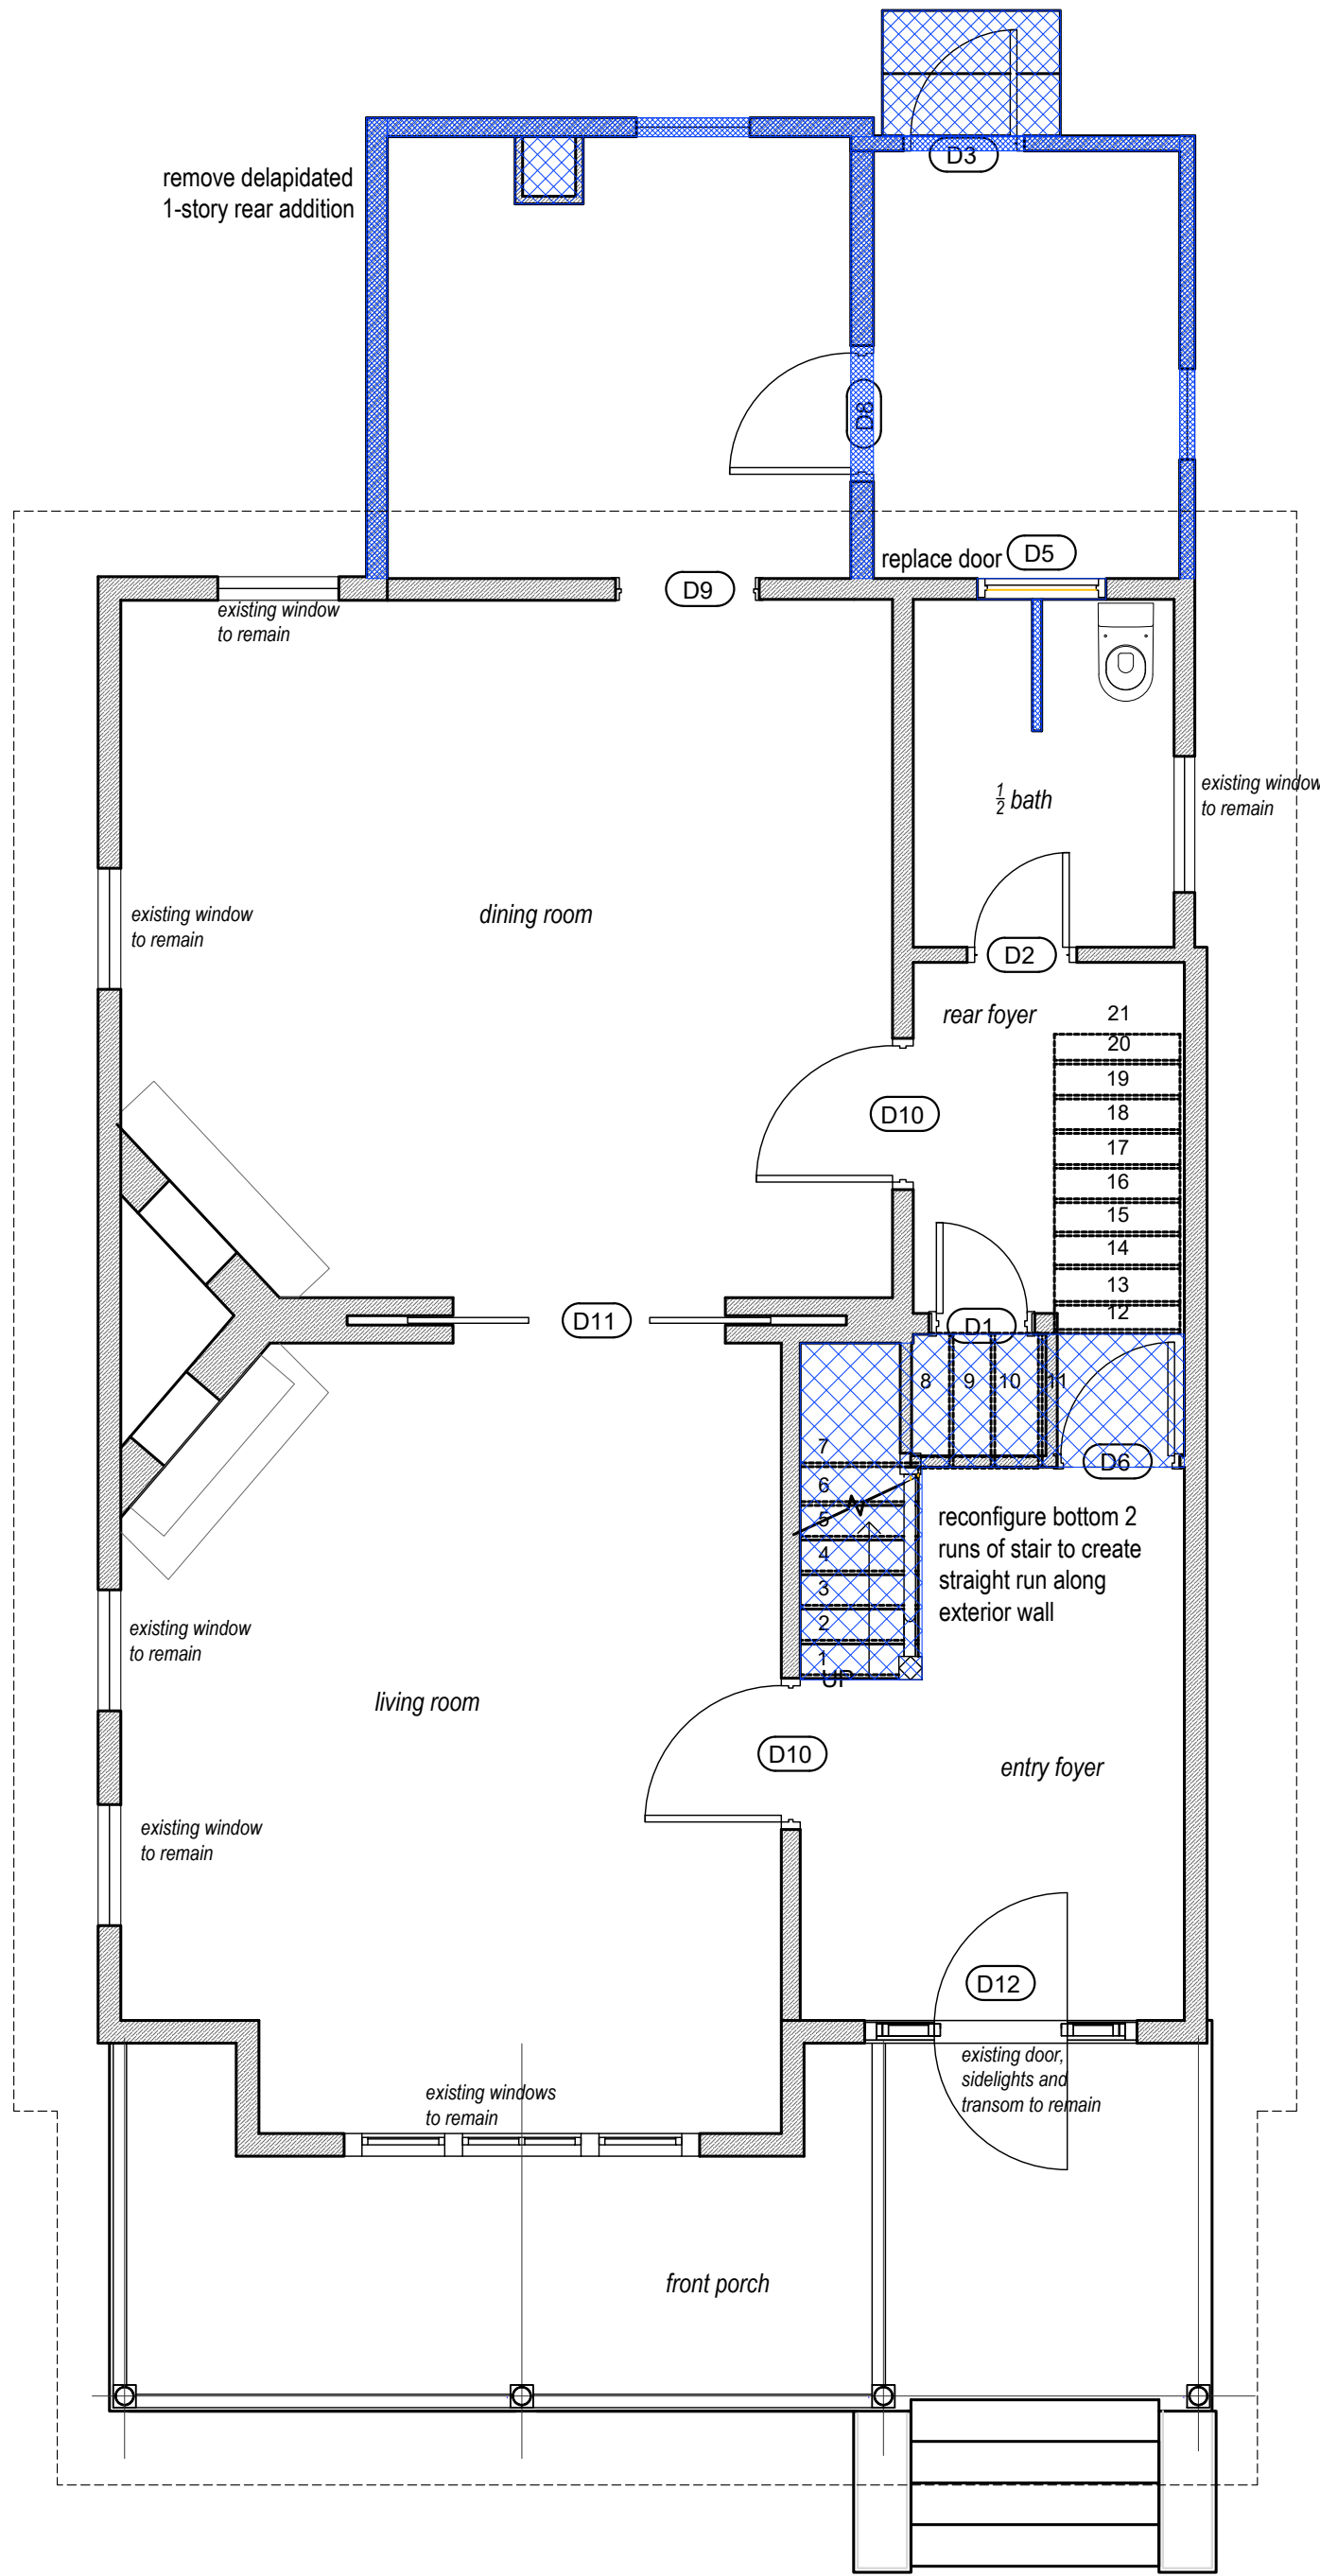


1
A-1.0

  EXISTING FLOOR PLAN: GROUND LEVEL
SCALE: 1/4" = 1'-0"




 = DEMOLITION

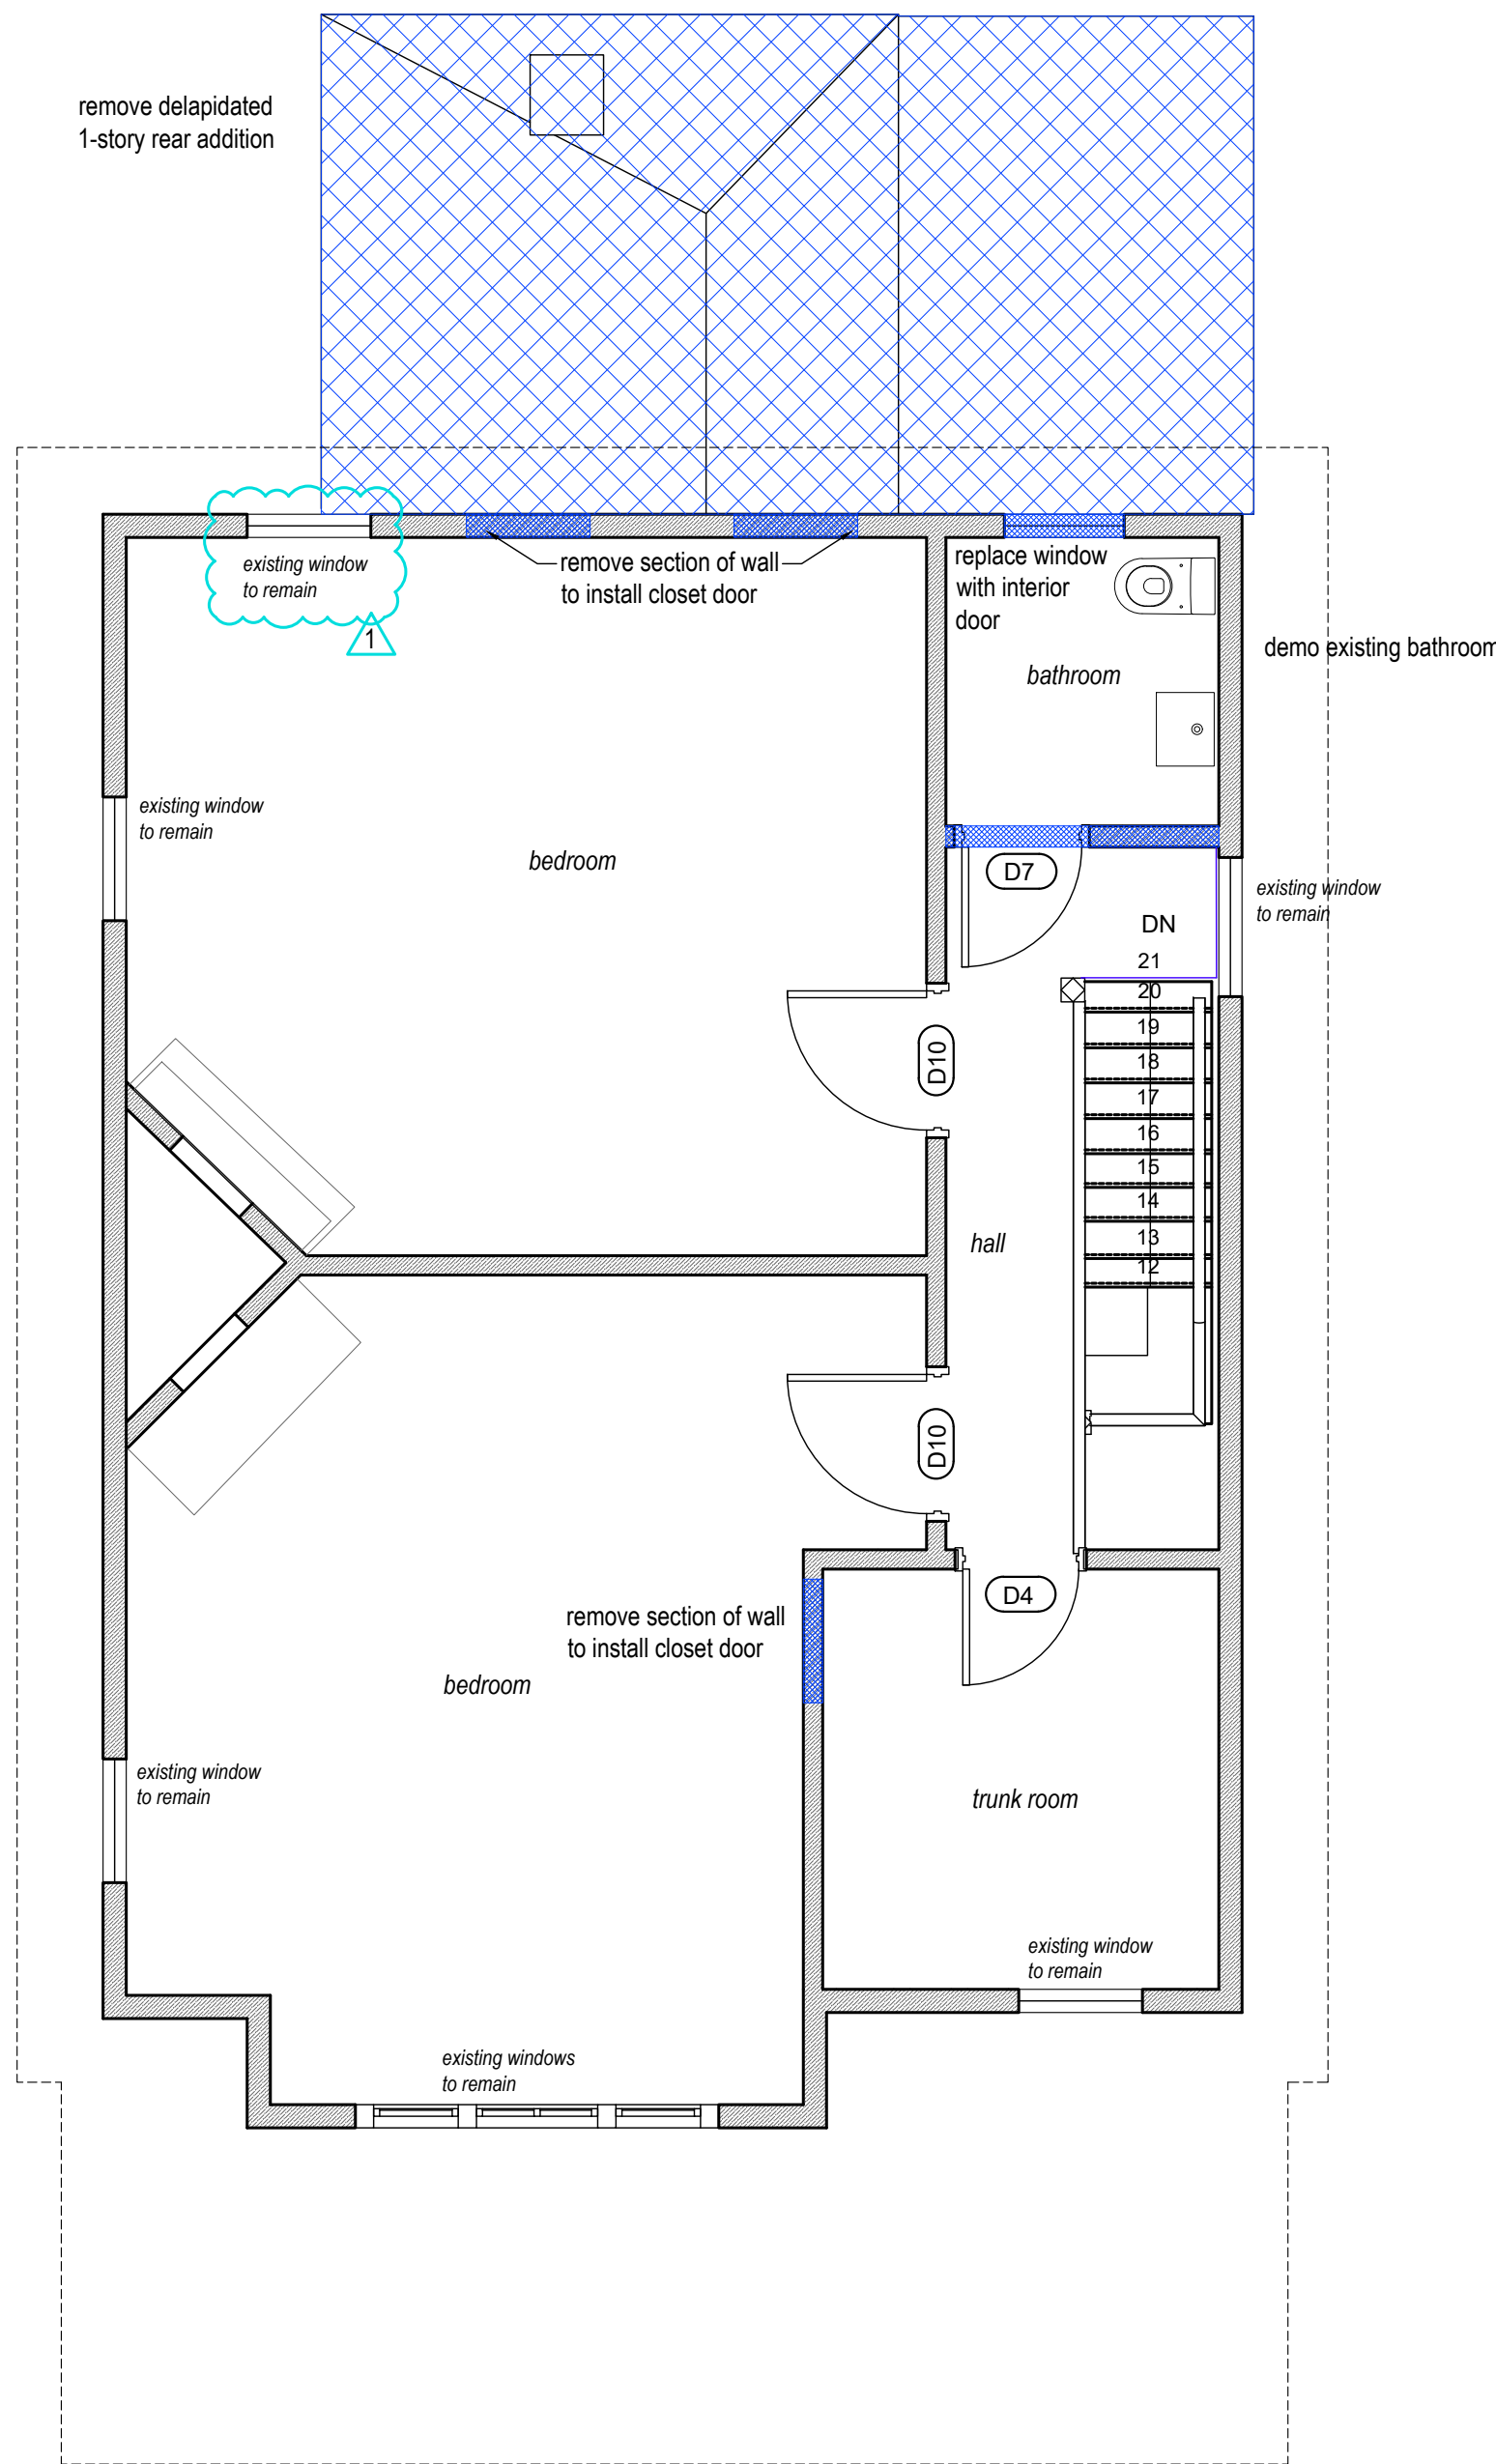


2
A-1.0

 EXISTING FLOOR PLAN: SECOND LEVEL
SCALE: 1/4" = 1'-0"



 = DEMOLITION

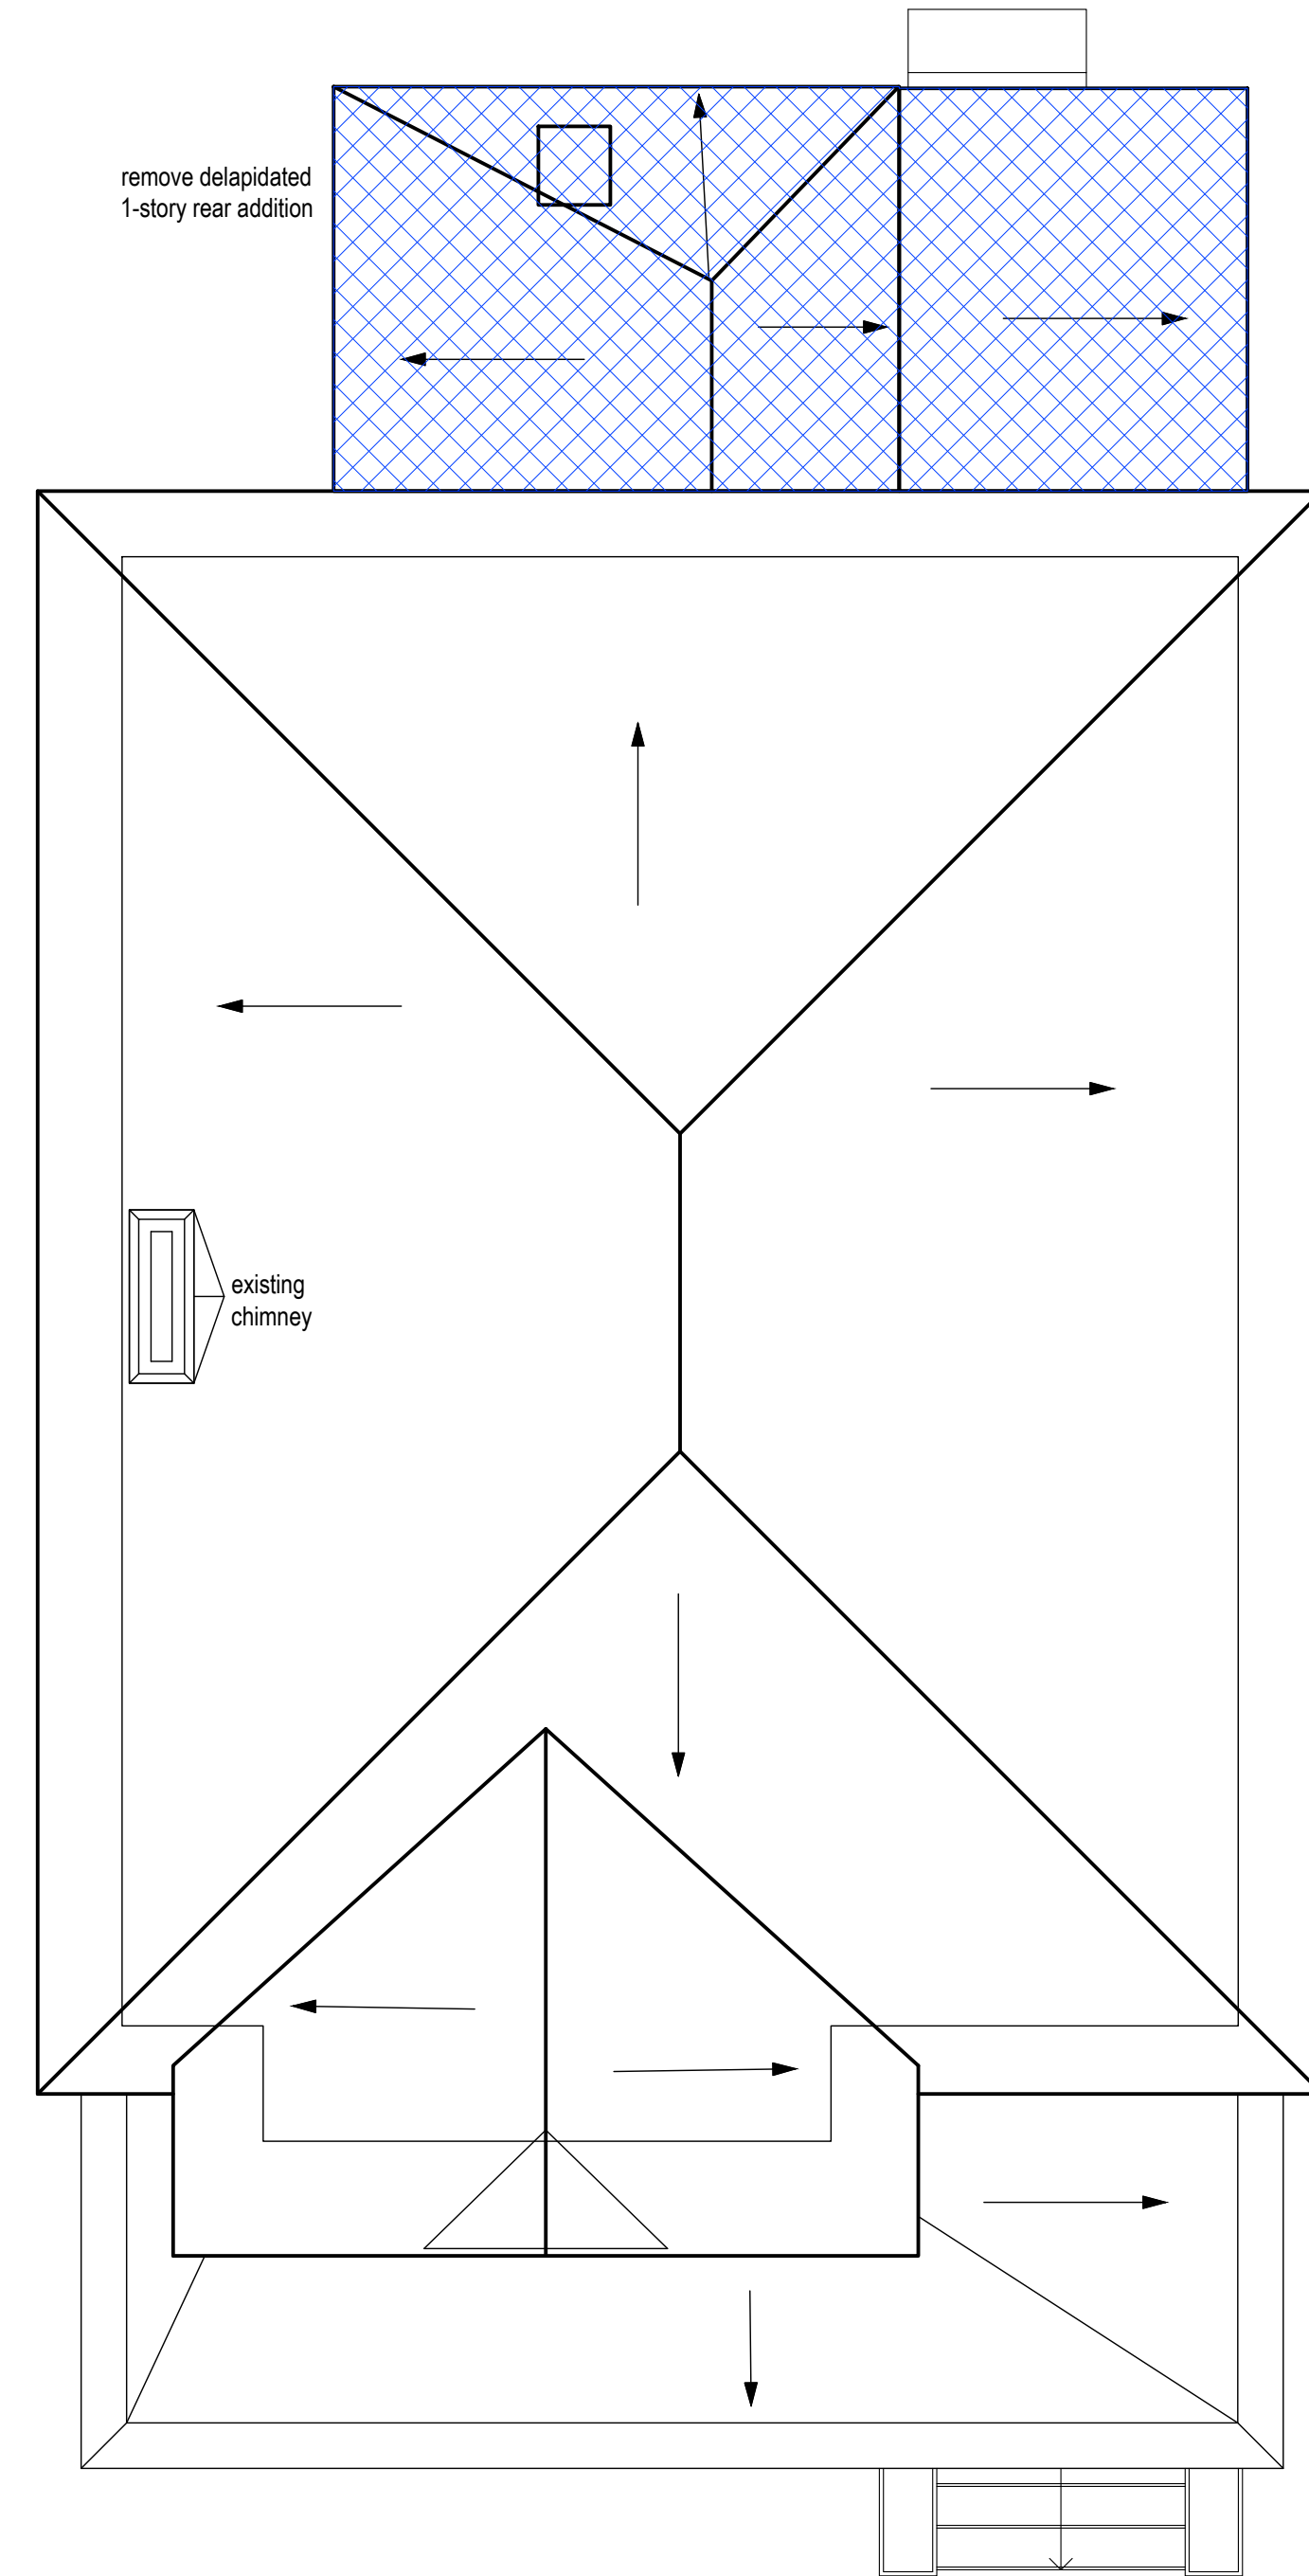

3
A-1.0

EXISTING ROOF PLAN
SCALE: 1/4" = 1'-0"

seal



SHAUNA
KUCERA
Registered Architect
912.228.9088

M. DIAB RESIDENCE
625 W. 36TH STREET
SAVANNAH, GEORGIA 31415

Revisions:
1. 27 FEBRUARY 2026


Date: 23 february 2026
Title:

EXISTING
/DEMOLITION
FLOOR AND
ROOF PLANS


Drawing No.

A-1.0


NOT RELEASED FOR CONSTRUCTION

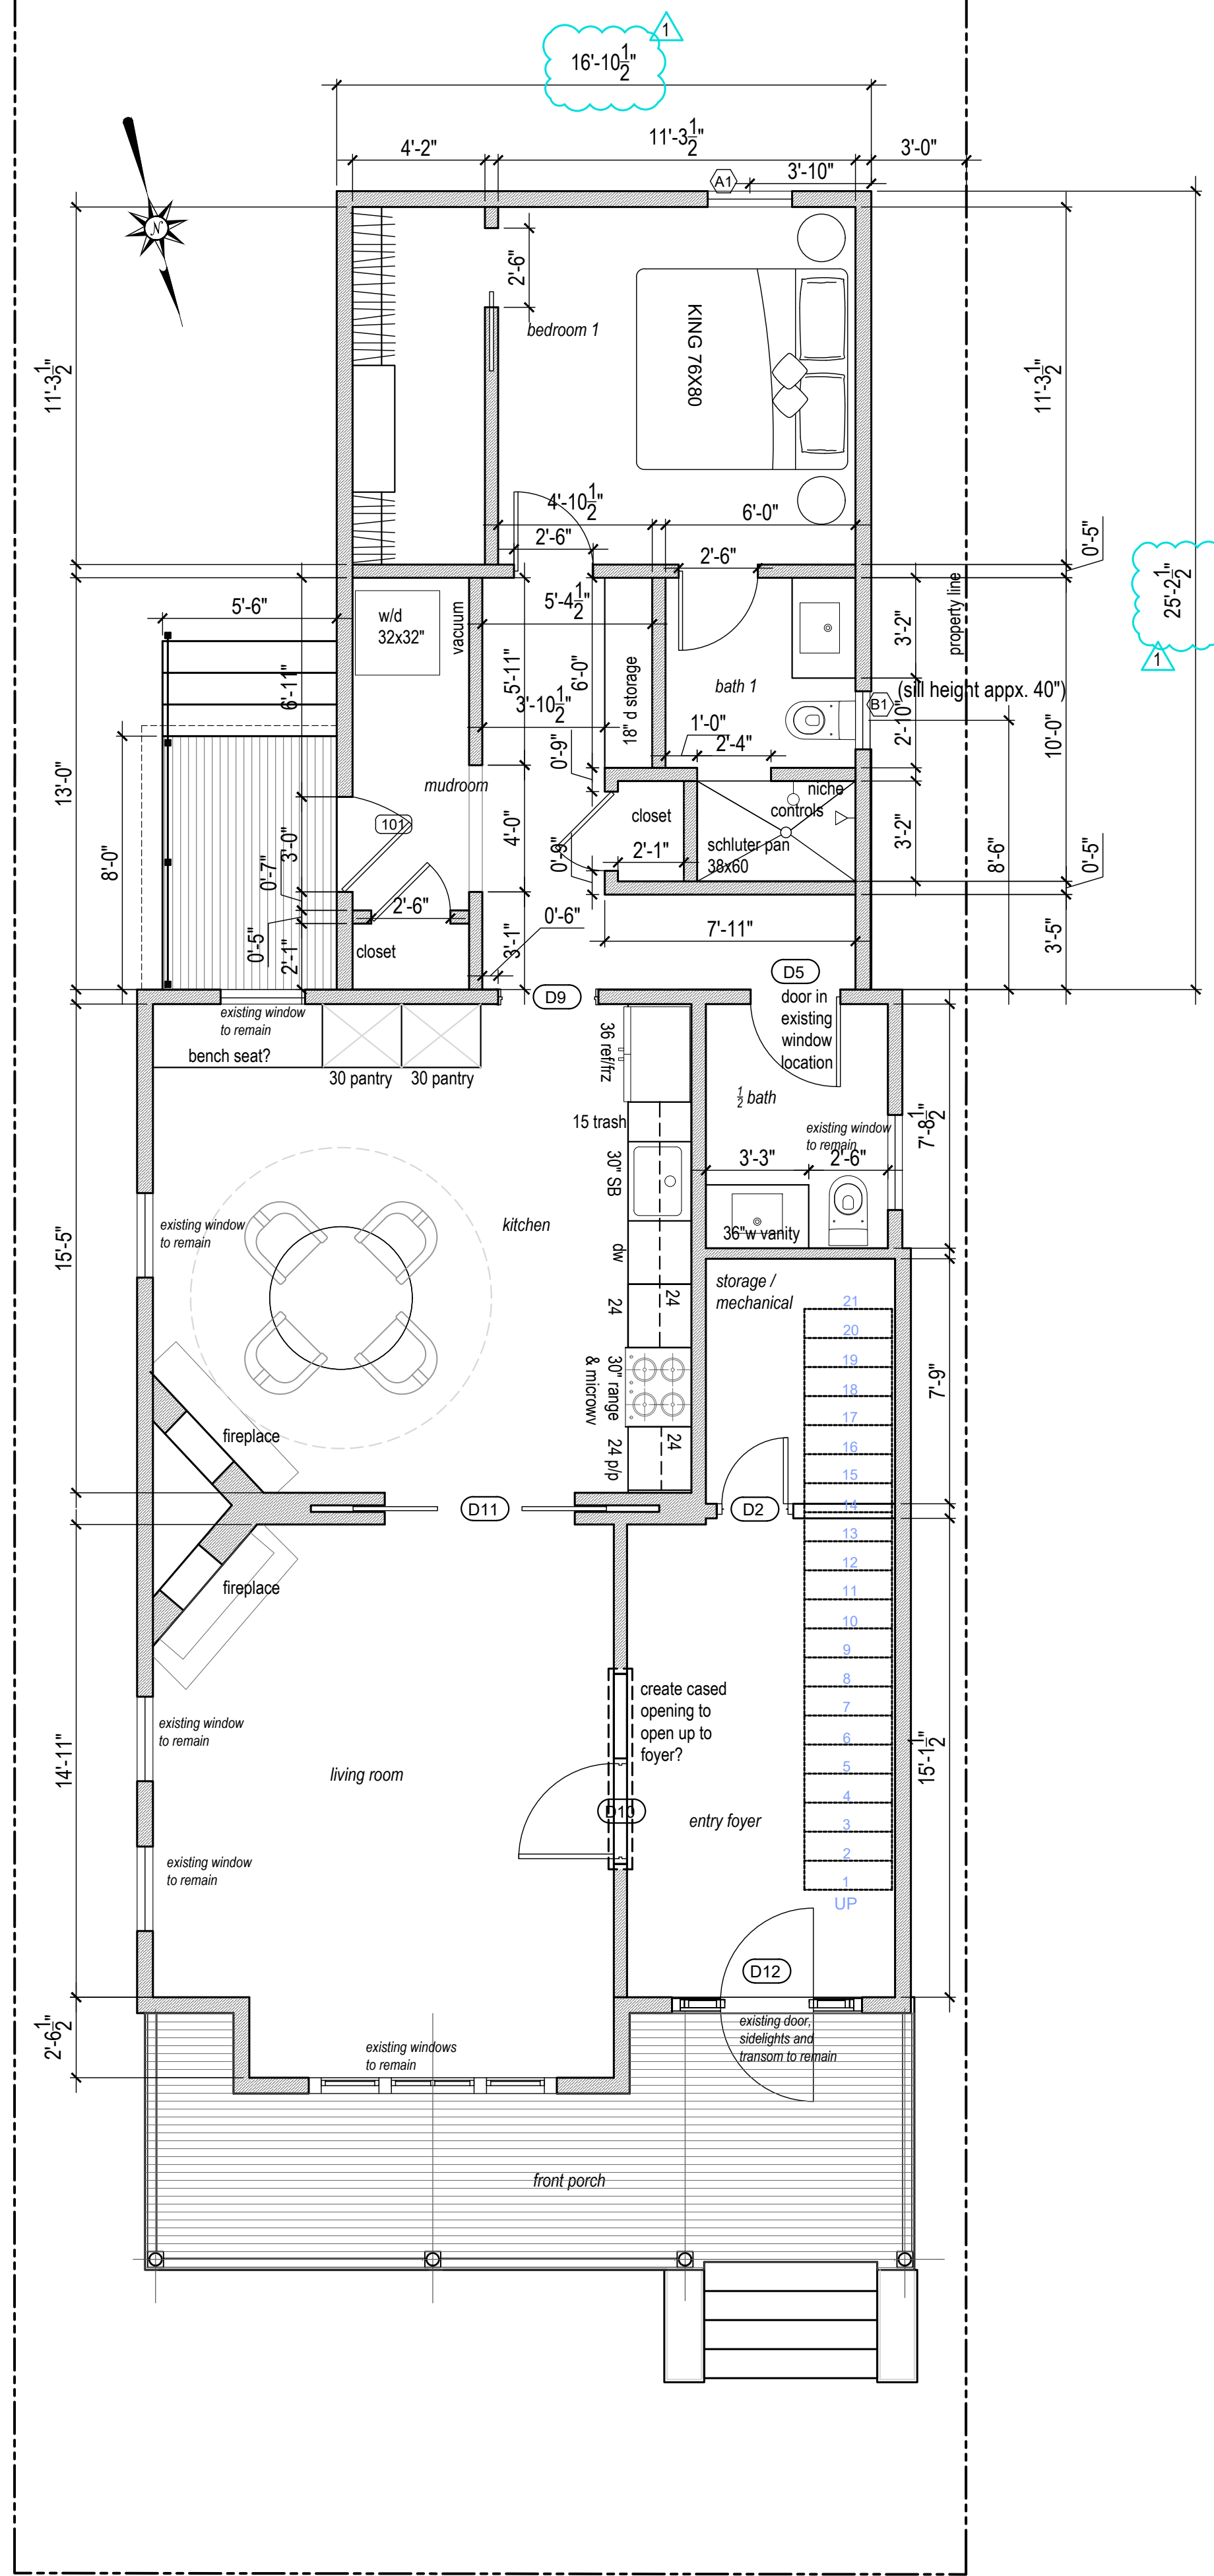

1 PROPOSED FLOOR PLAN: GROUND LEVEL
SCALE: 1/4" = 1'-0"

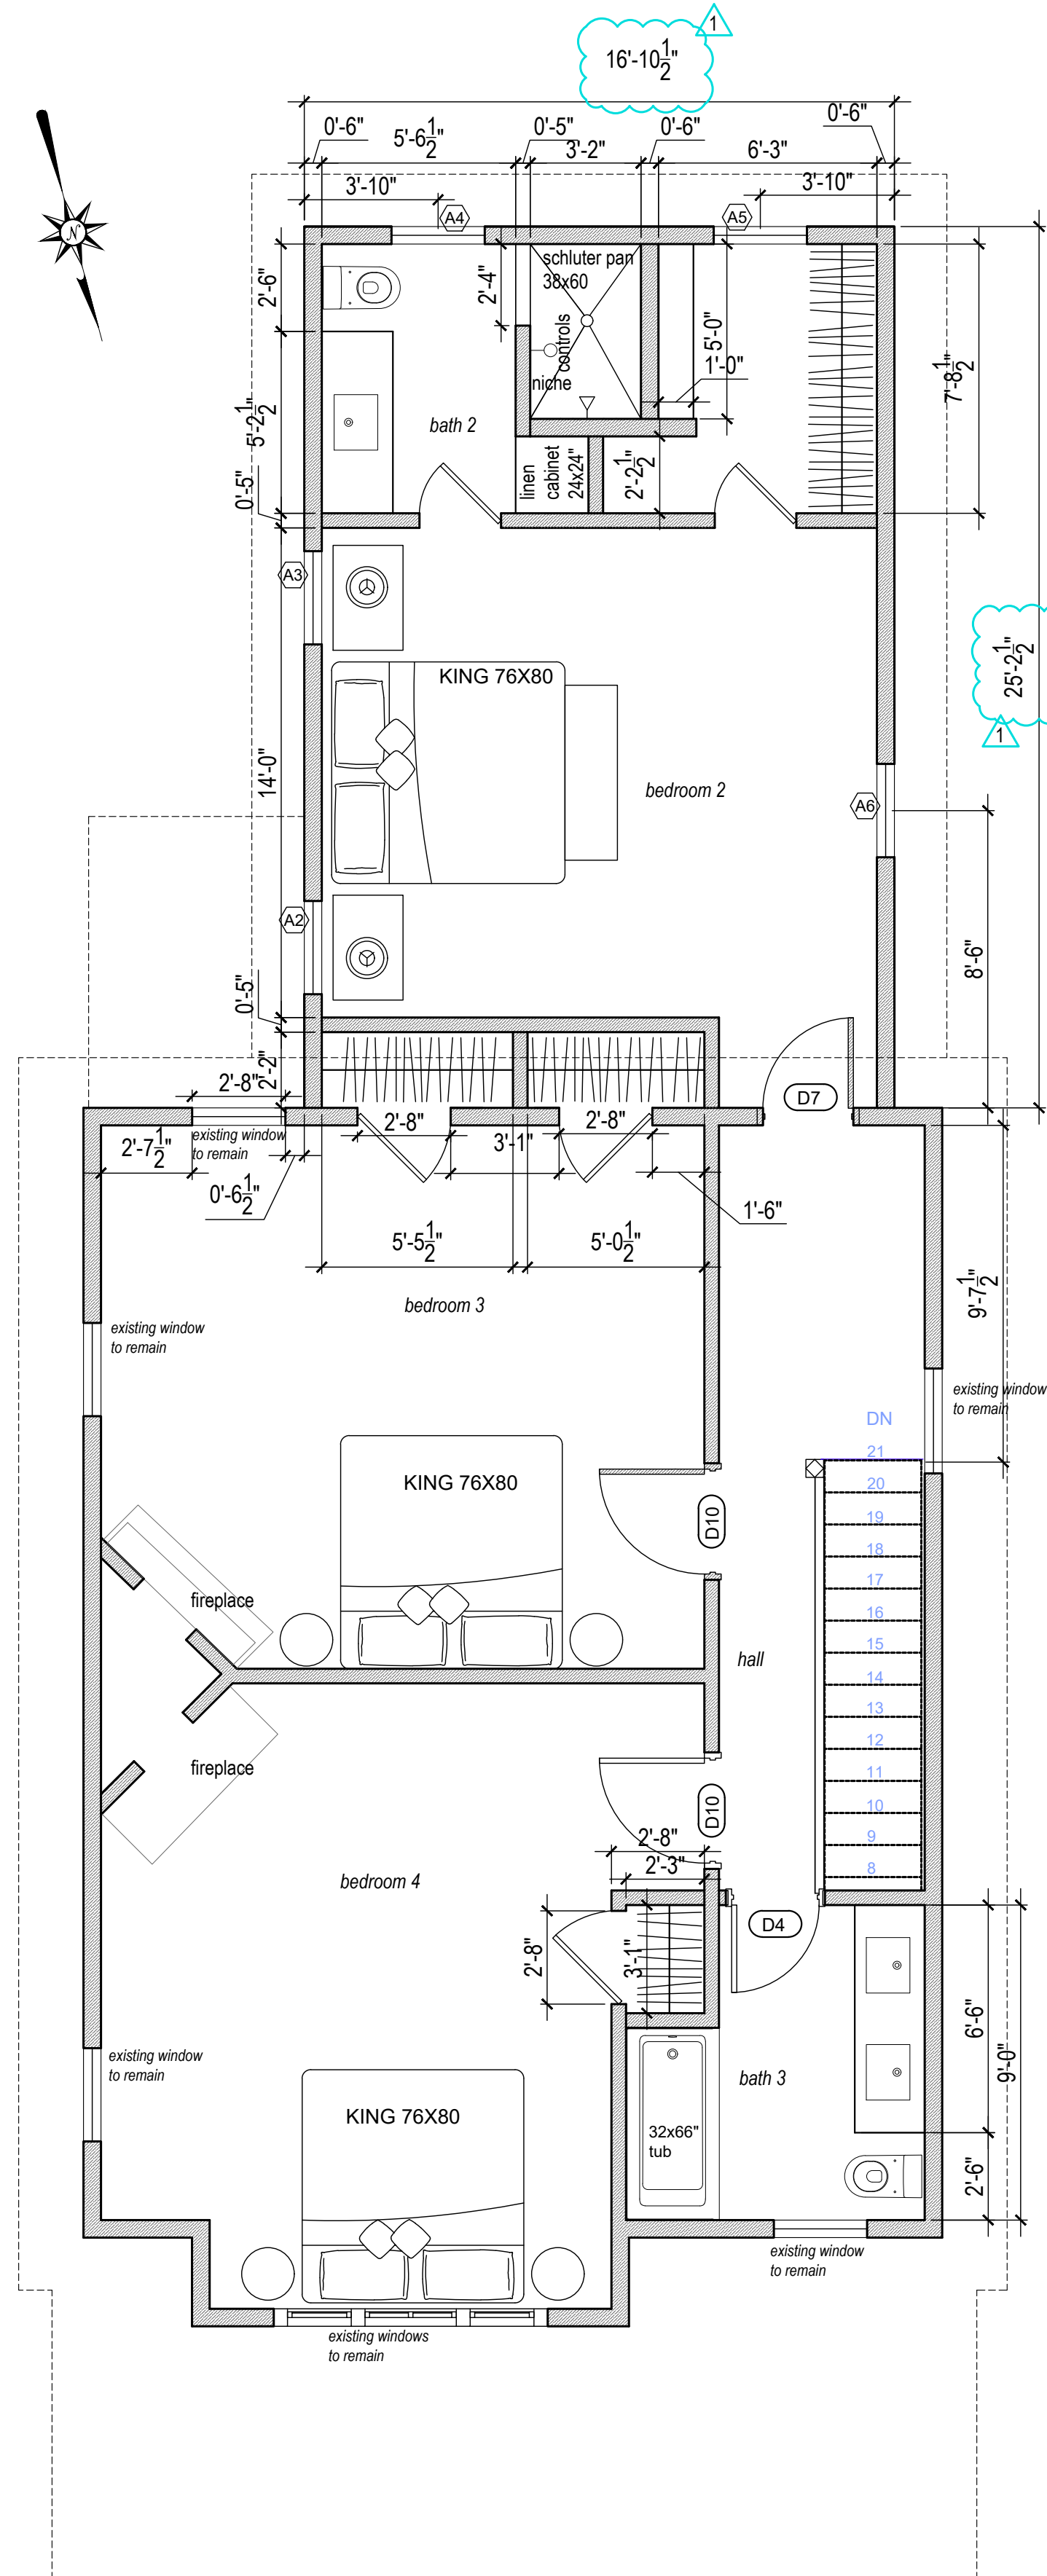


2 PROPOSED FLOOR PLAN: SECOND LEVEL
SCALE: 1/4" = 1'-0"

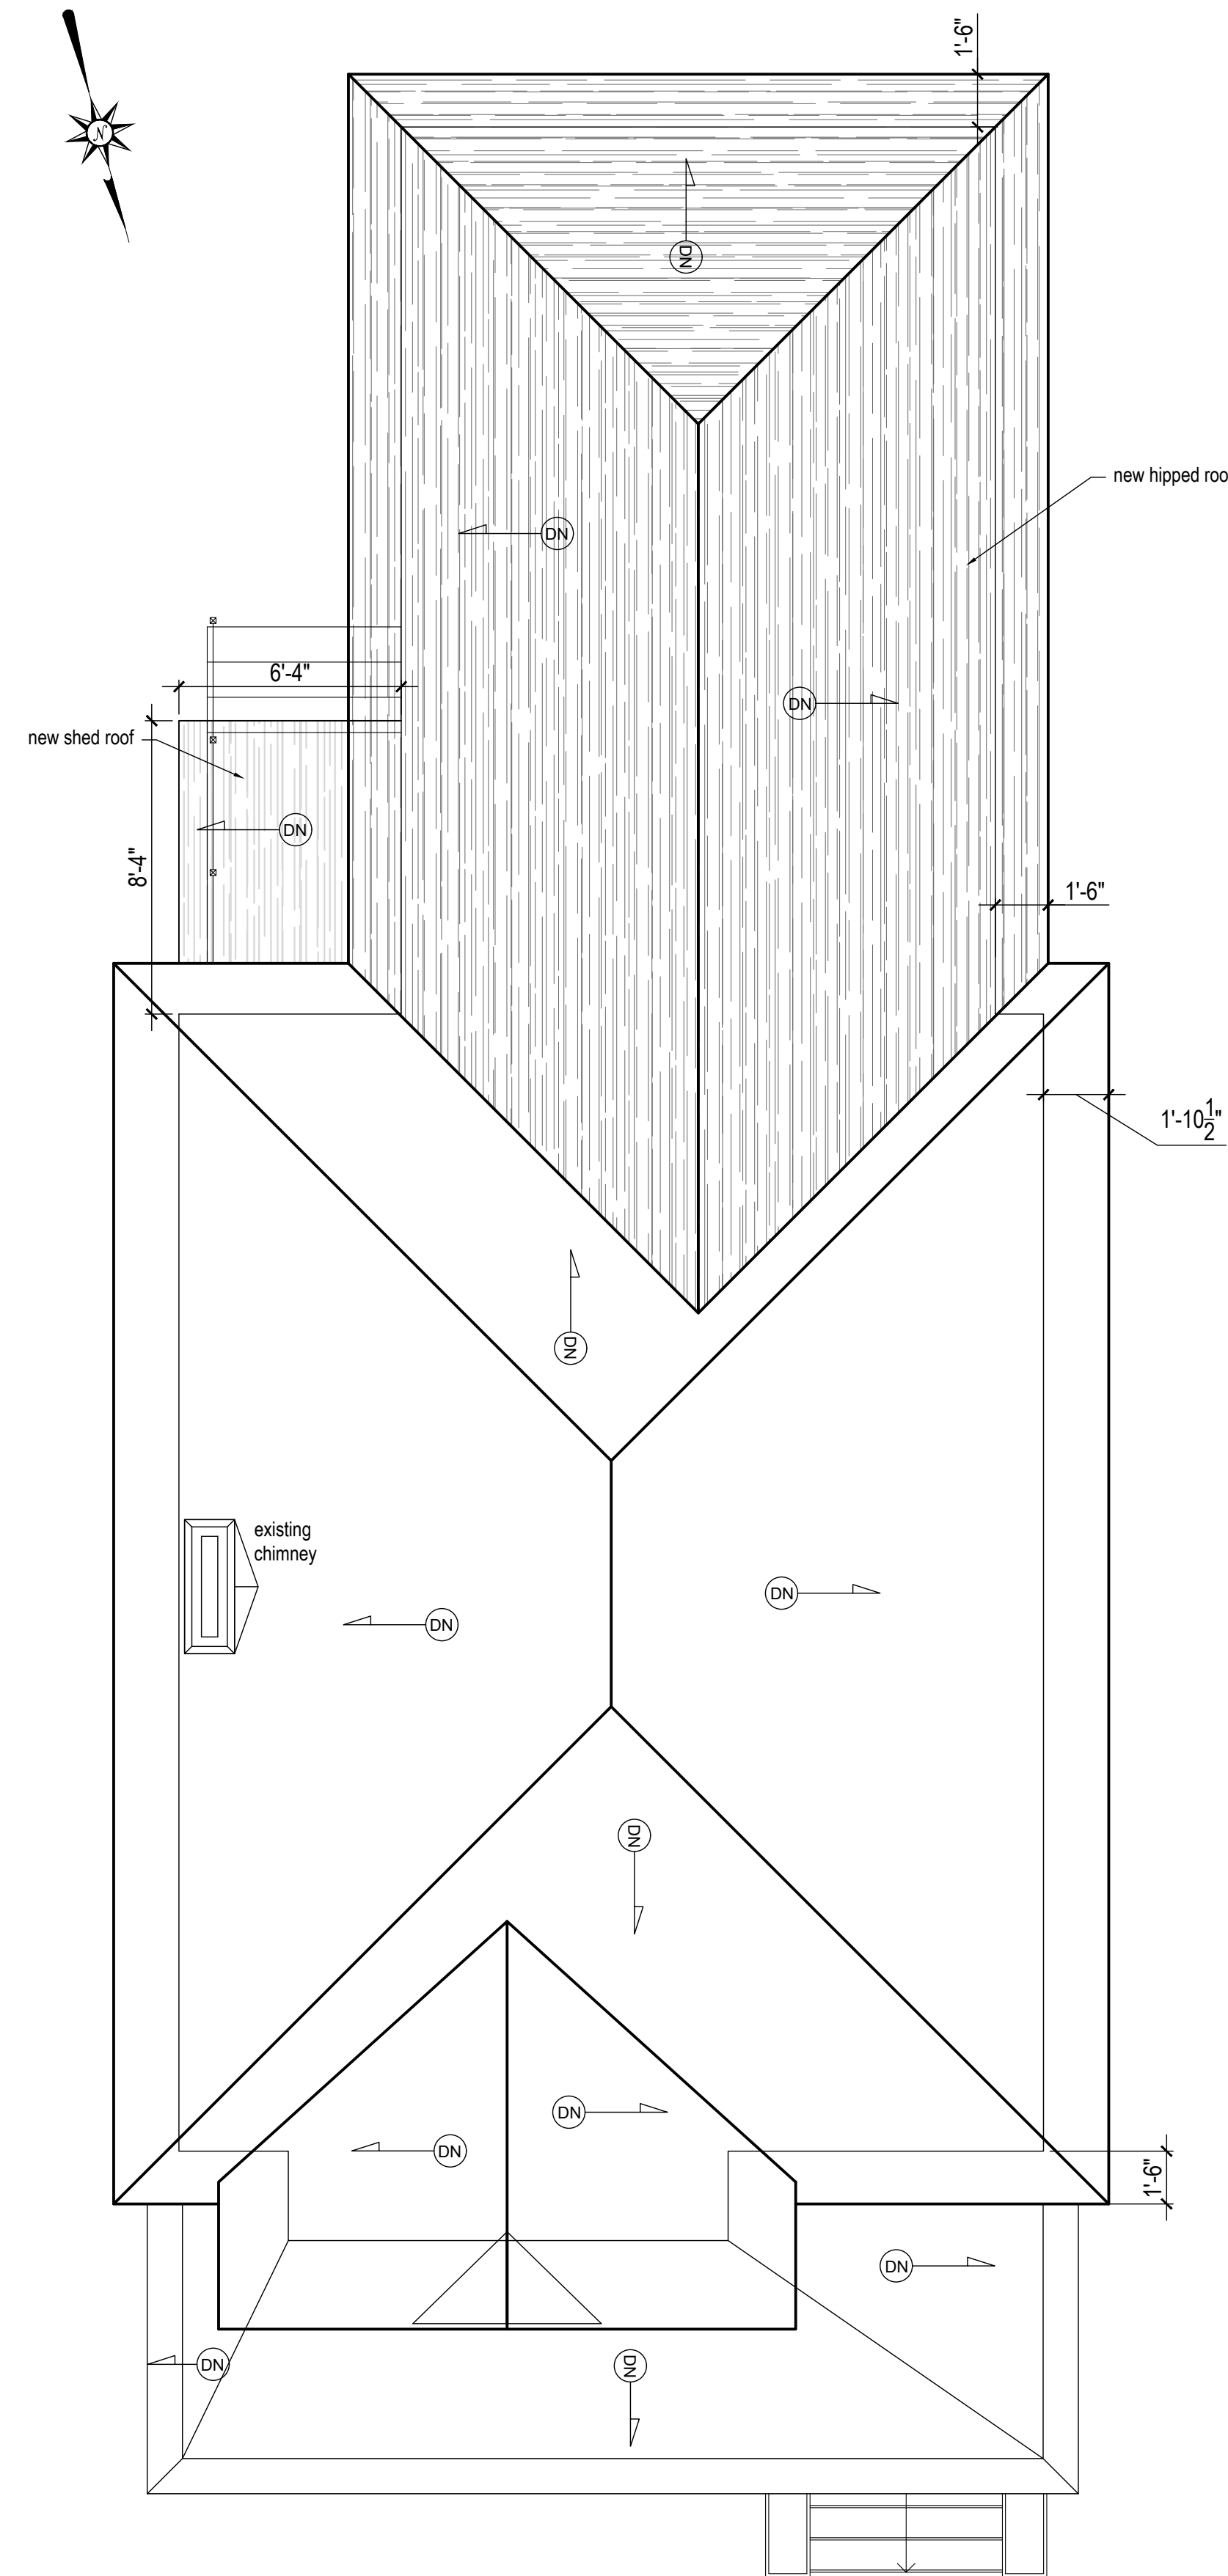

3 PROPOSED ROOF PLAN
SCALE: 1/4" = 1'-0"

seal

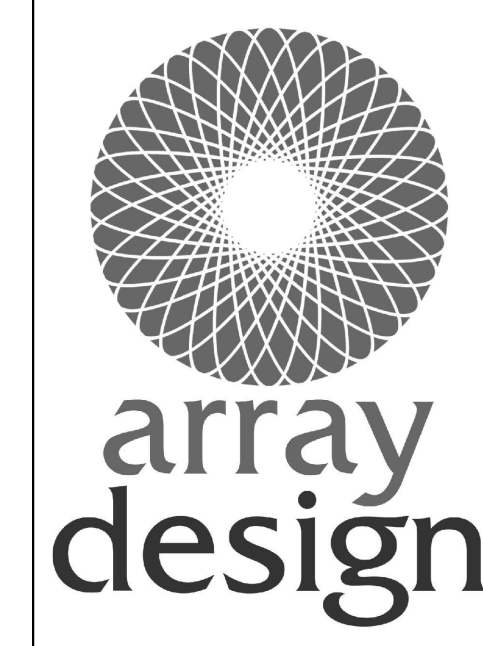

SHAUNA KUCERA
Registered Architect
912.228.9088

M. DIAB RESIDENCE
625 W. 36TH STREET
SAVANNAH, GEORGIA 31415

Revisions:

27 FEBRUARY 2026


Date: 23 february 2026
Title:

PROPOSED
FLOOR AND
ROOF PLANS


Drawing No.

A-1.1

NOT RELEASED FOR CONSTRUCTION

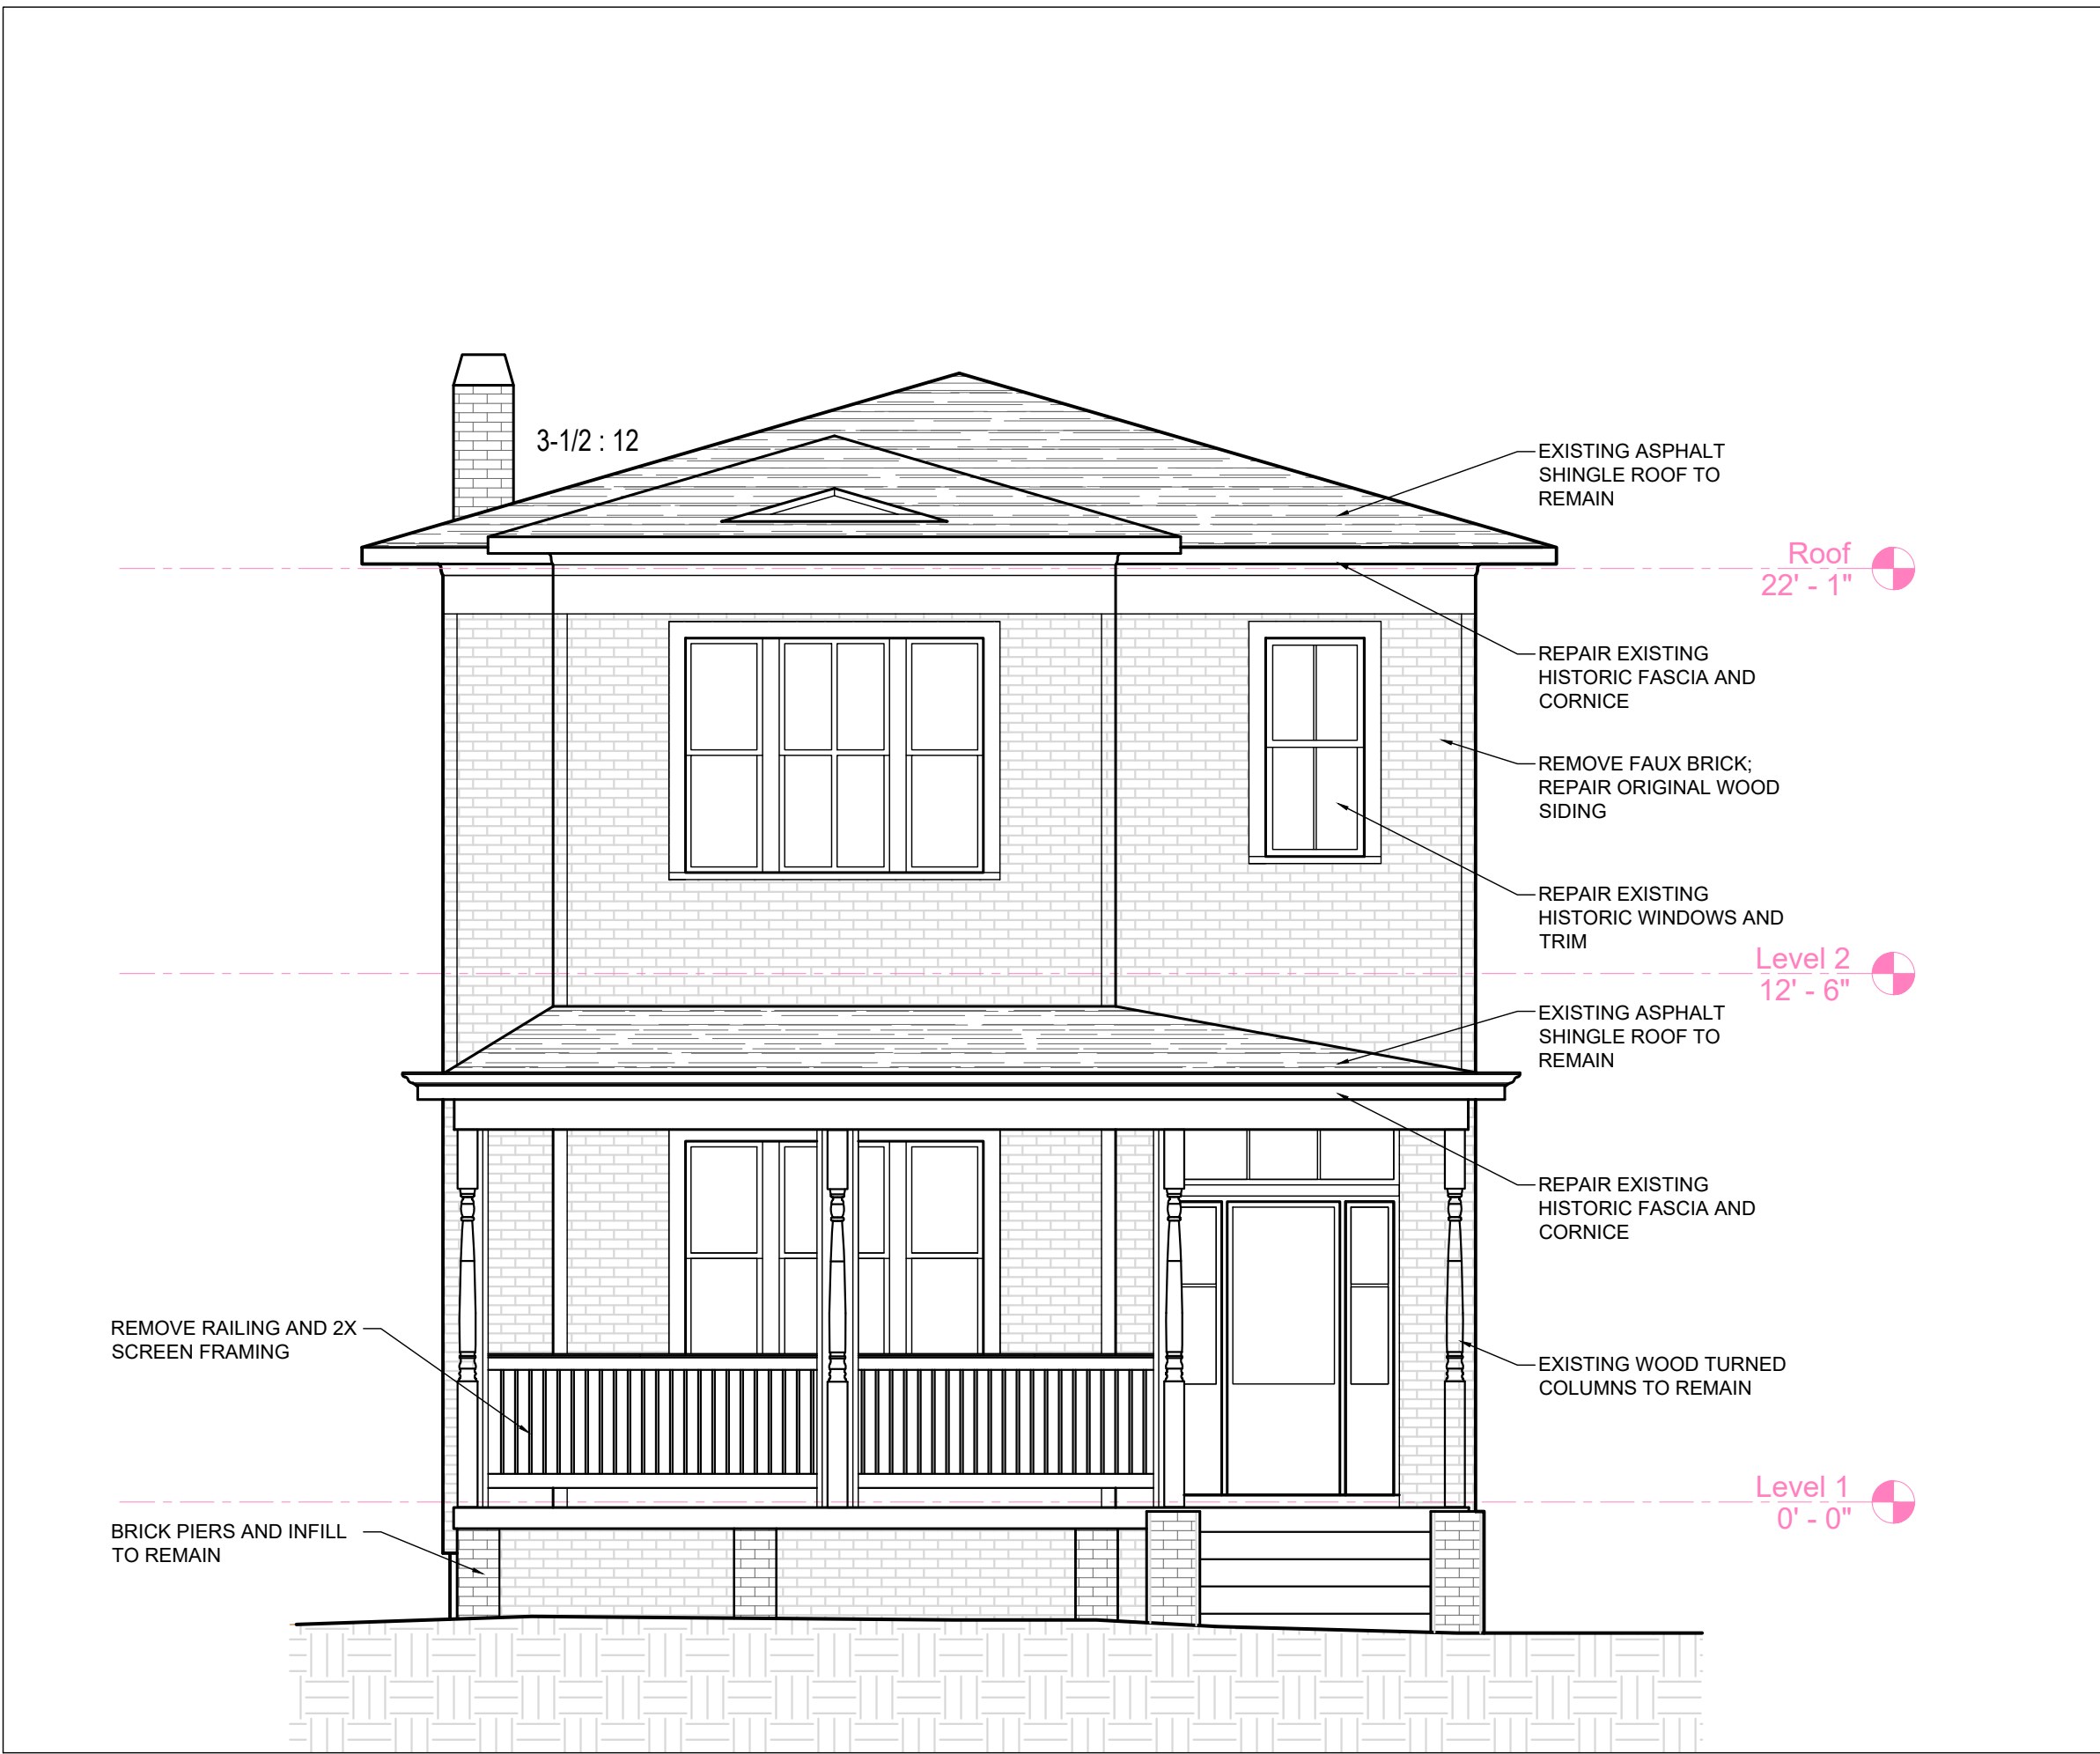

1 NORTH ELEVATION: EXISTING
SCALE: 1/4" = 1'-0"

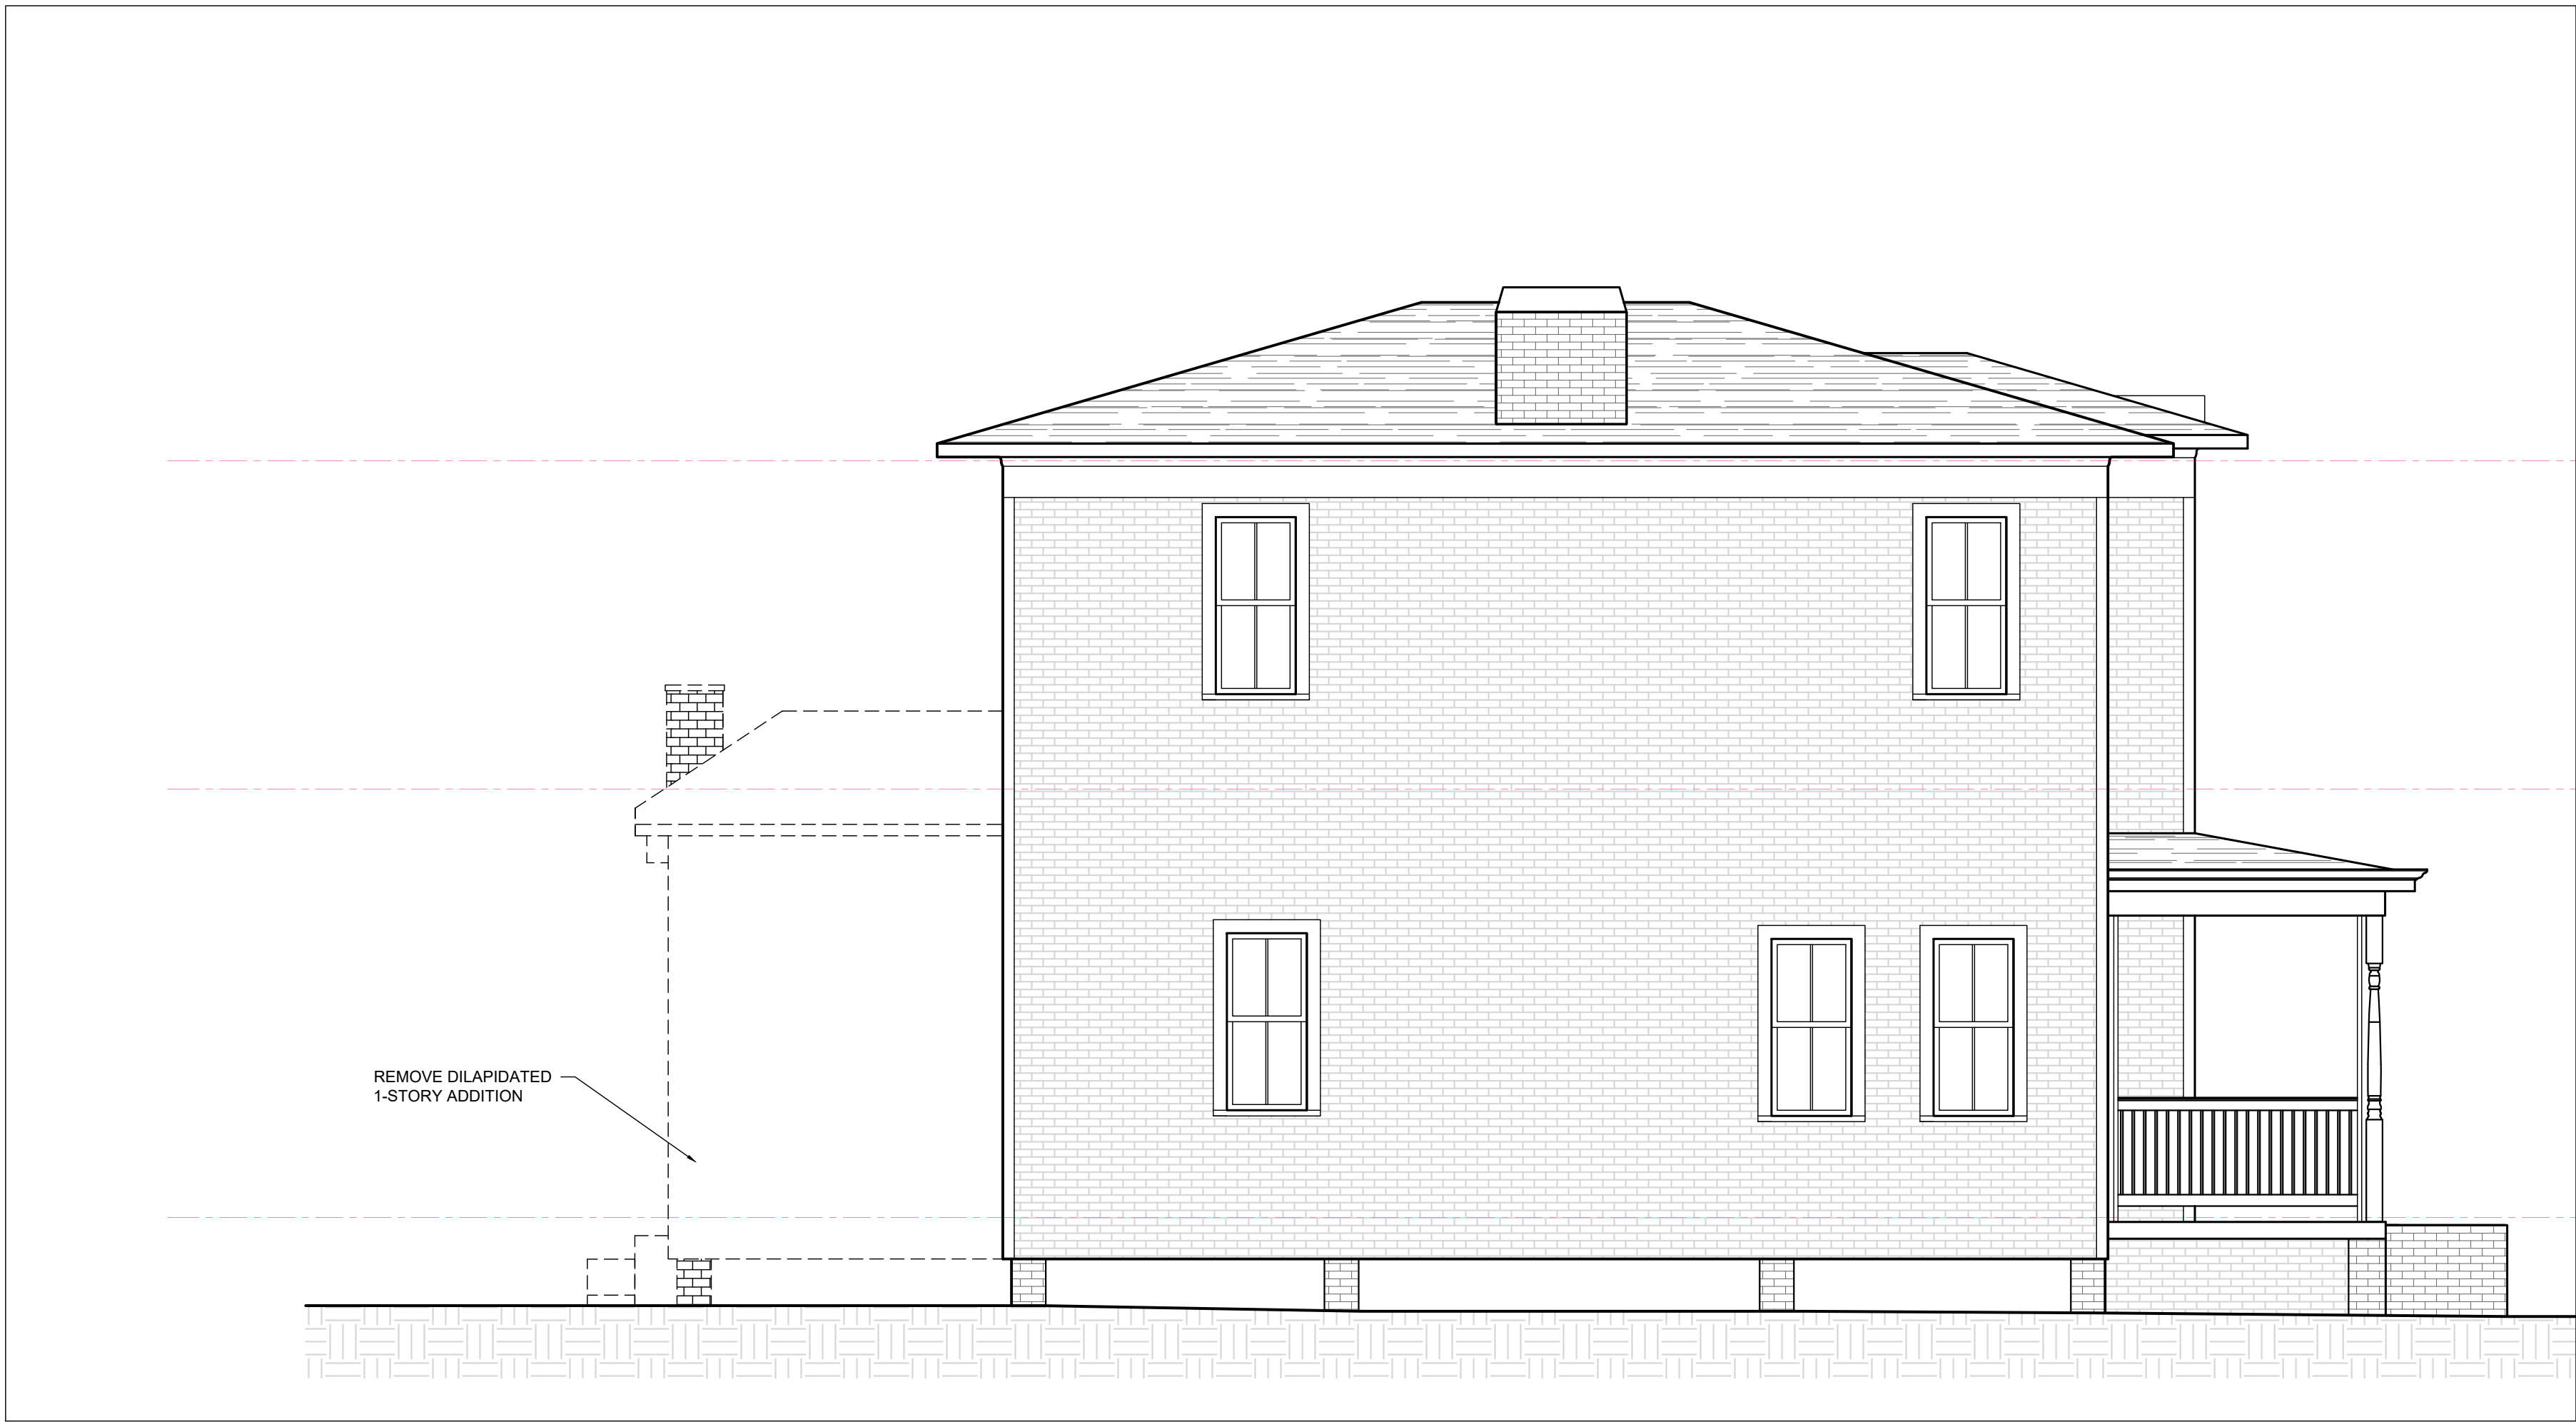

3 EAST ELEVATION: EXISTING
SCALE: 1/4" = 1'-0"




2 NORTH ELEVATION: PROPOSED
SCALE: 1/4" = 1'-0"



4 EAST ELEVATION: PROPOSED
SCALE: 1/4" = 1'-0"

seal

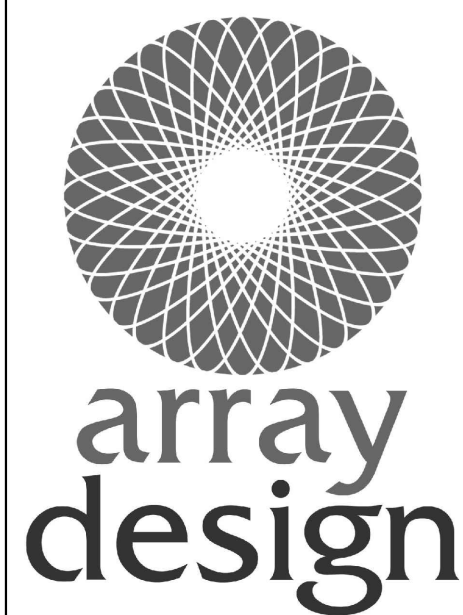

SHAUNA KUCERA
Registered Architect
912.228.9088


M. DIAB RESIDENCE
625 W. 36TH STREET
SAVANNAH, GEORGIA 31415

Revisions:
27 FEBRUARY 2026


Date: 23 february 2026
Title:
EXTERIOR ELEVATIONS, EXISTING & PROPOSED, NORTH AND EAST
Drawing No.

A-2.0


NOT RELEASED FOR CONSTRUCTION

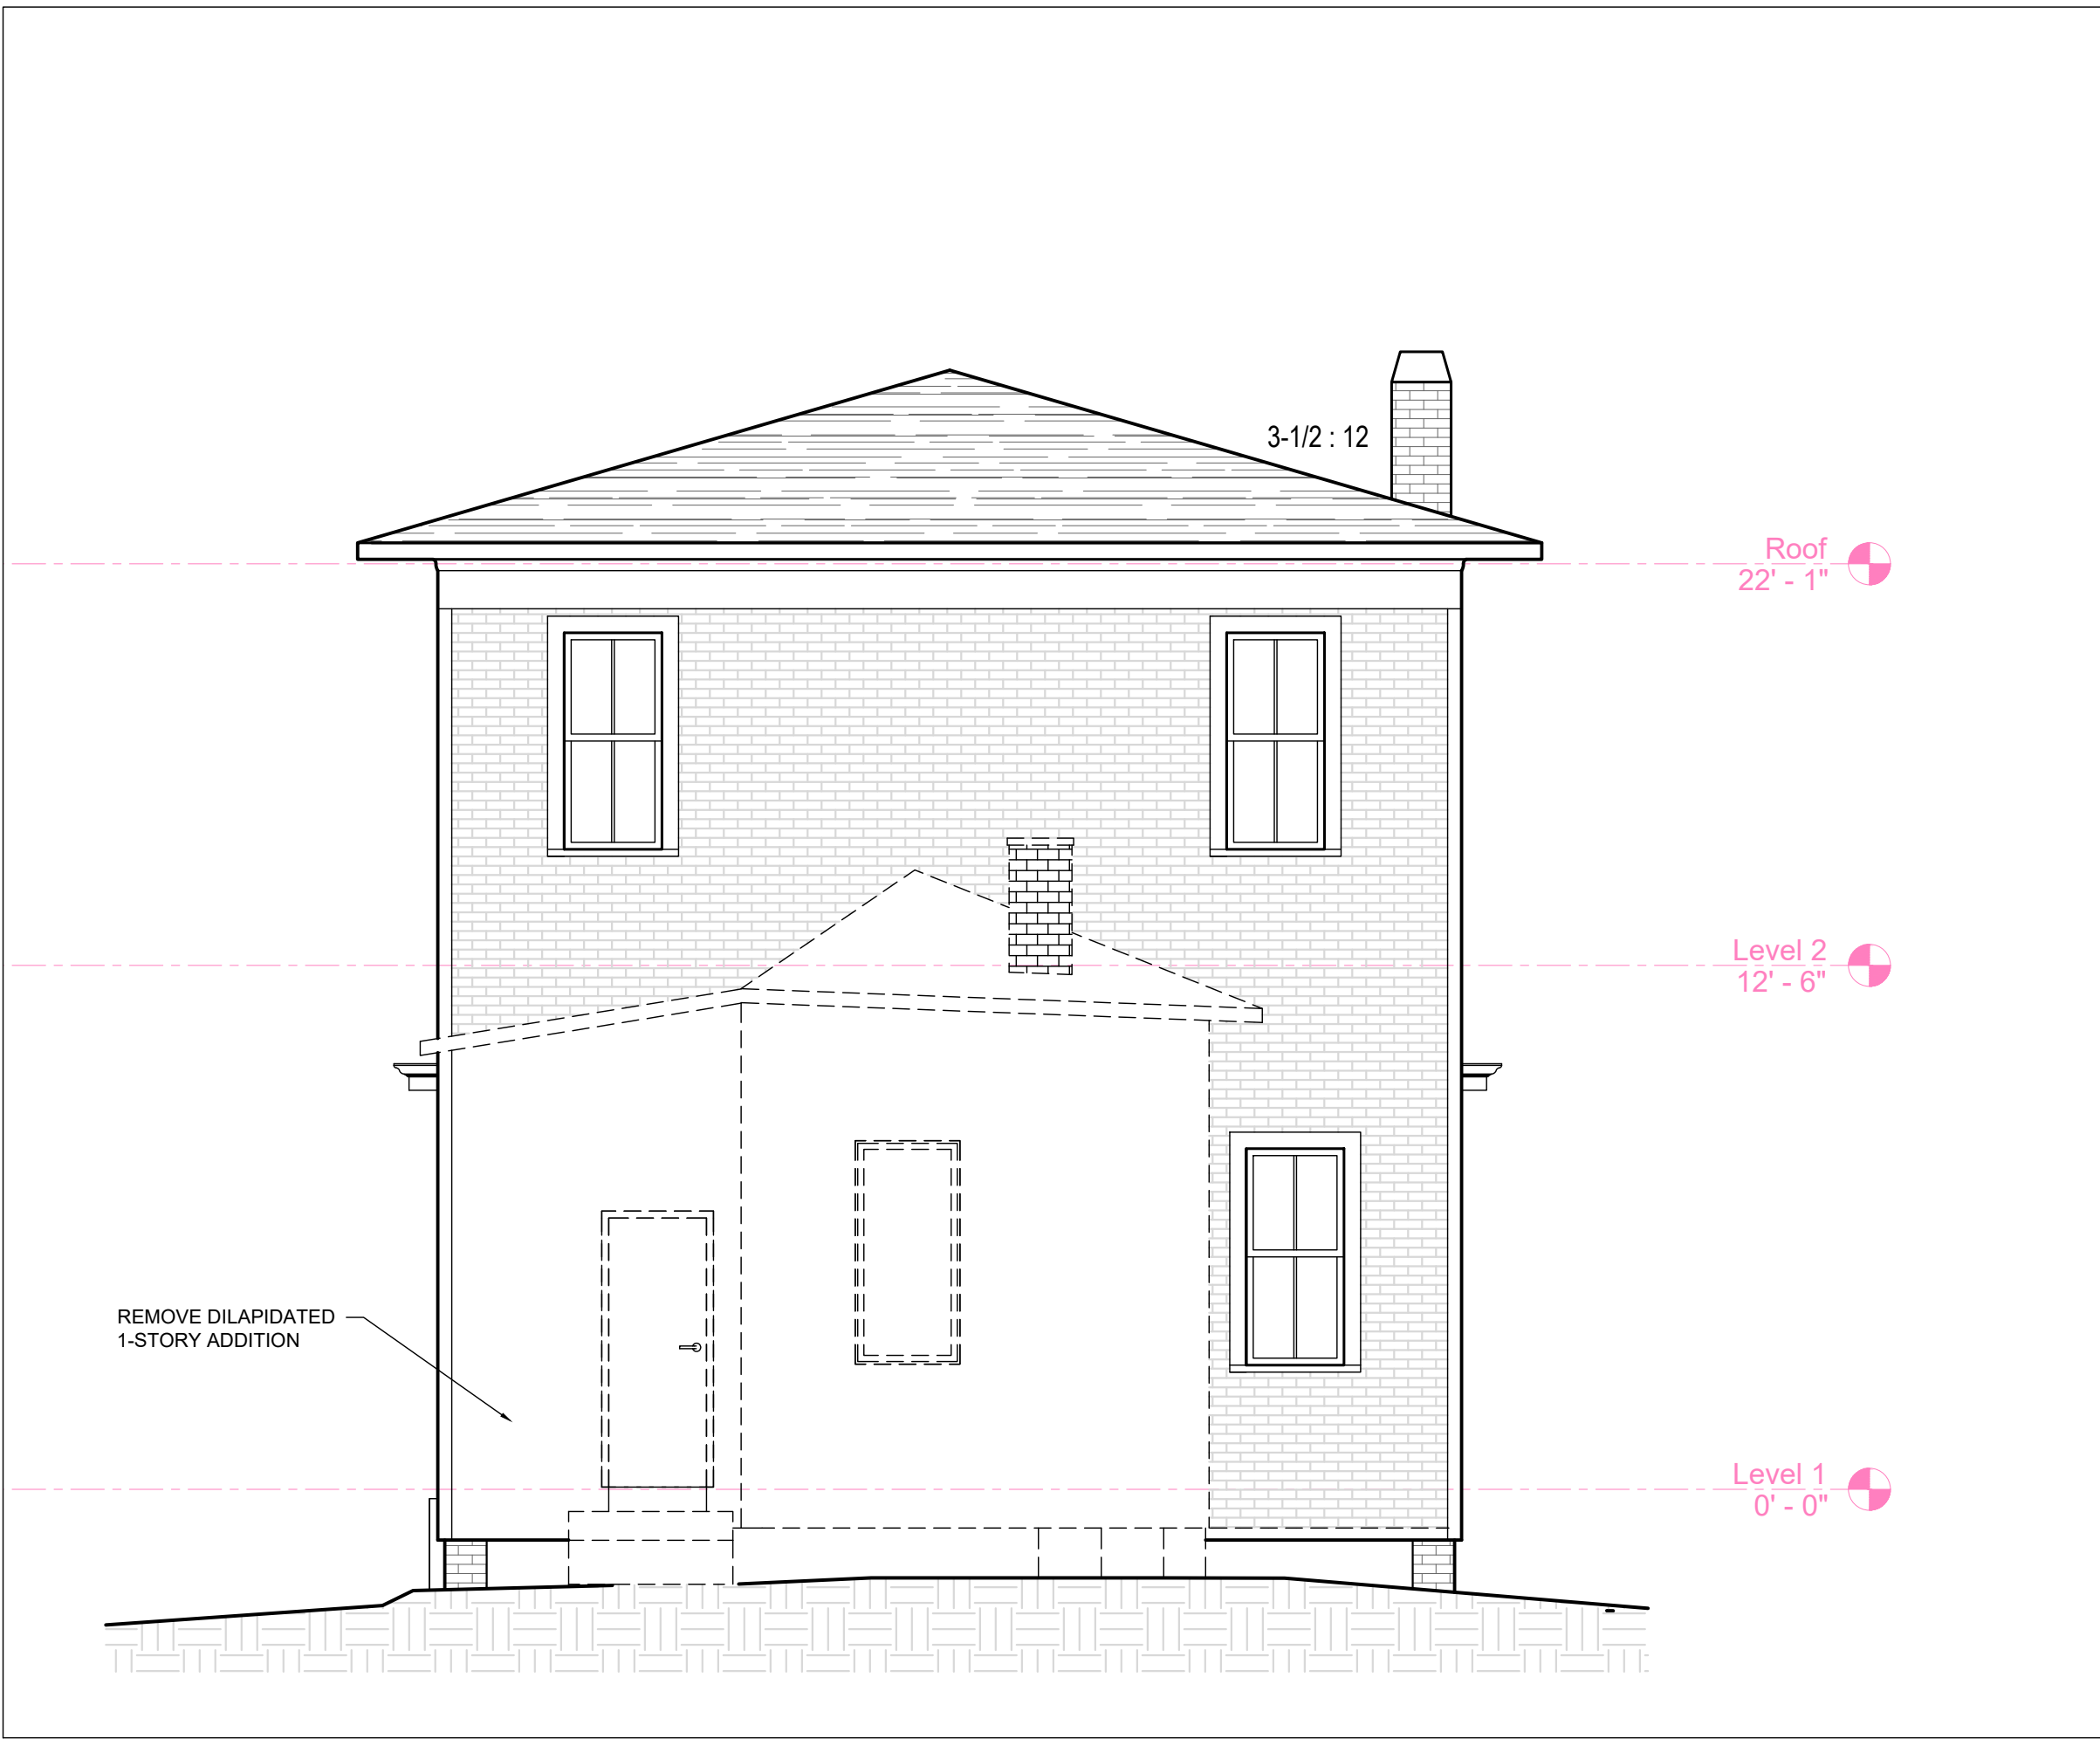

1 SOUTH ELEVATION: EXISTING
SCALE: 1/4" = 1'-0"

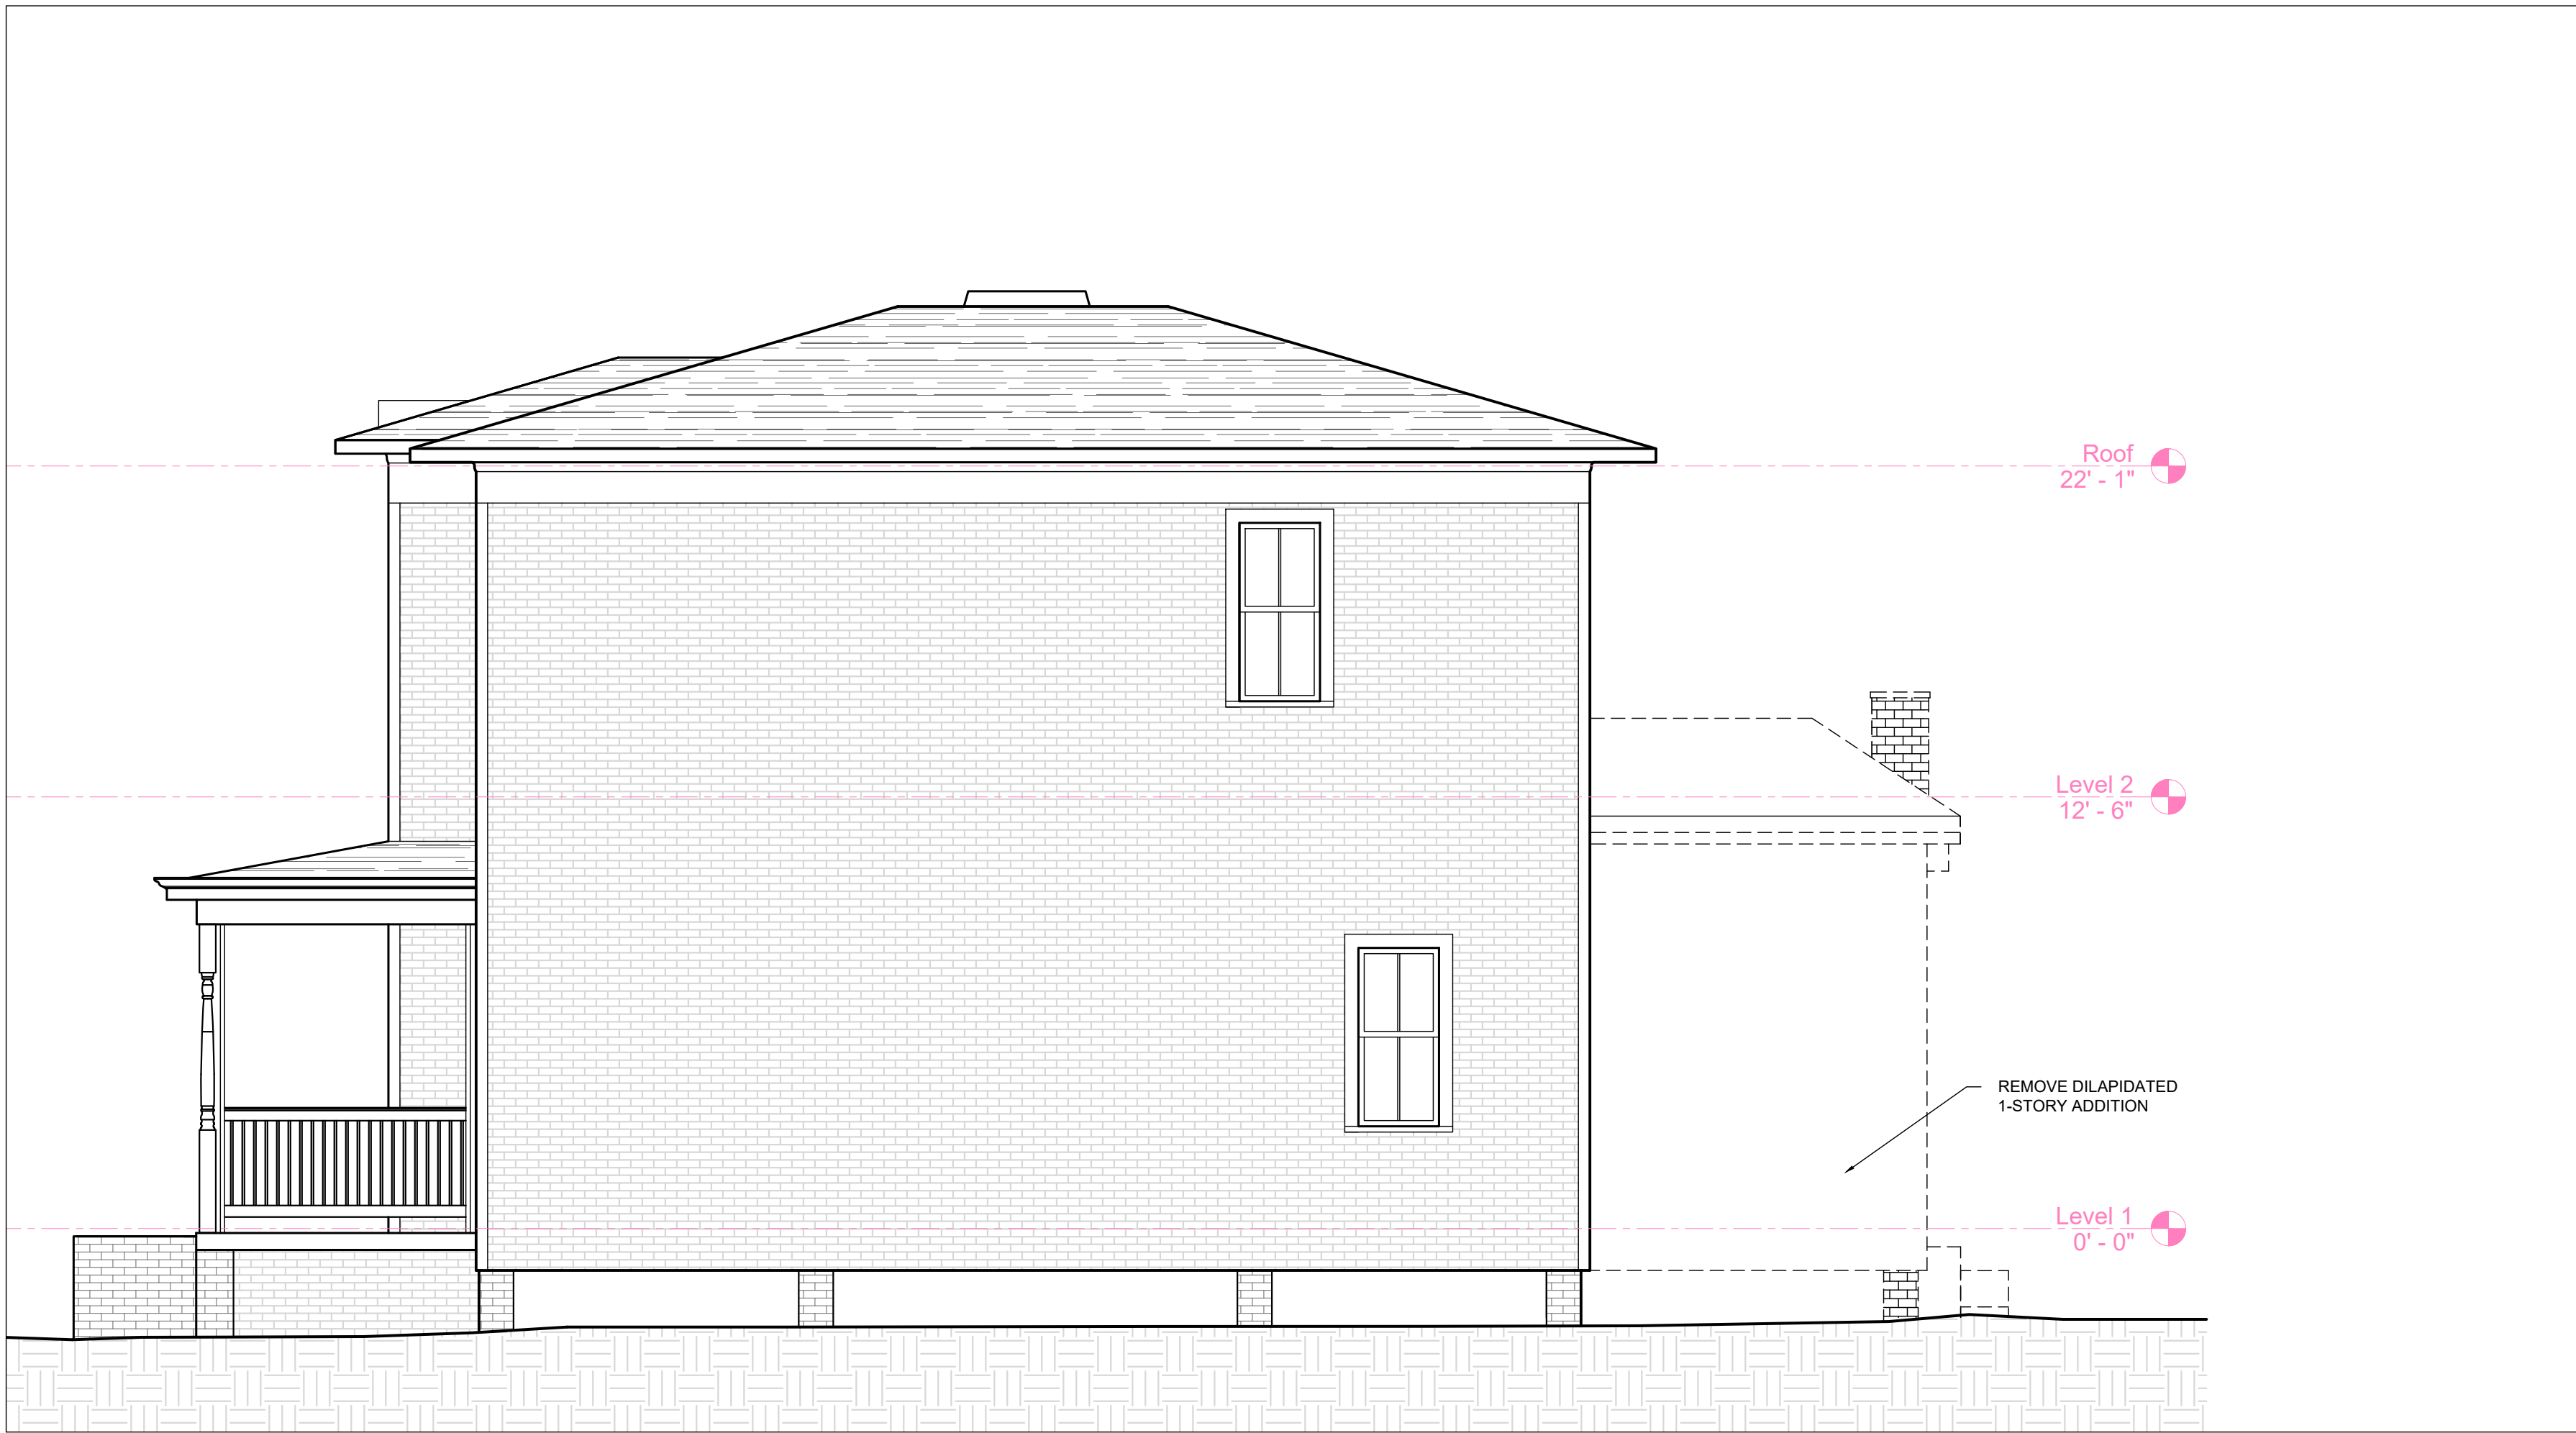

3 WEST ELEVATION: EXISTING
SCALE: 1/4" = 1'-0"

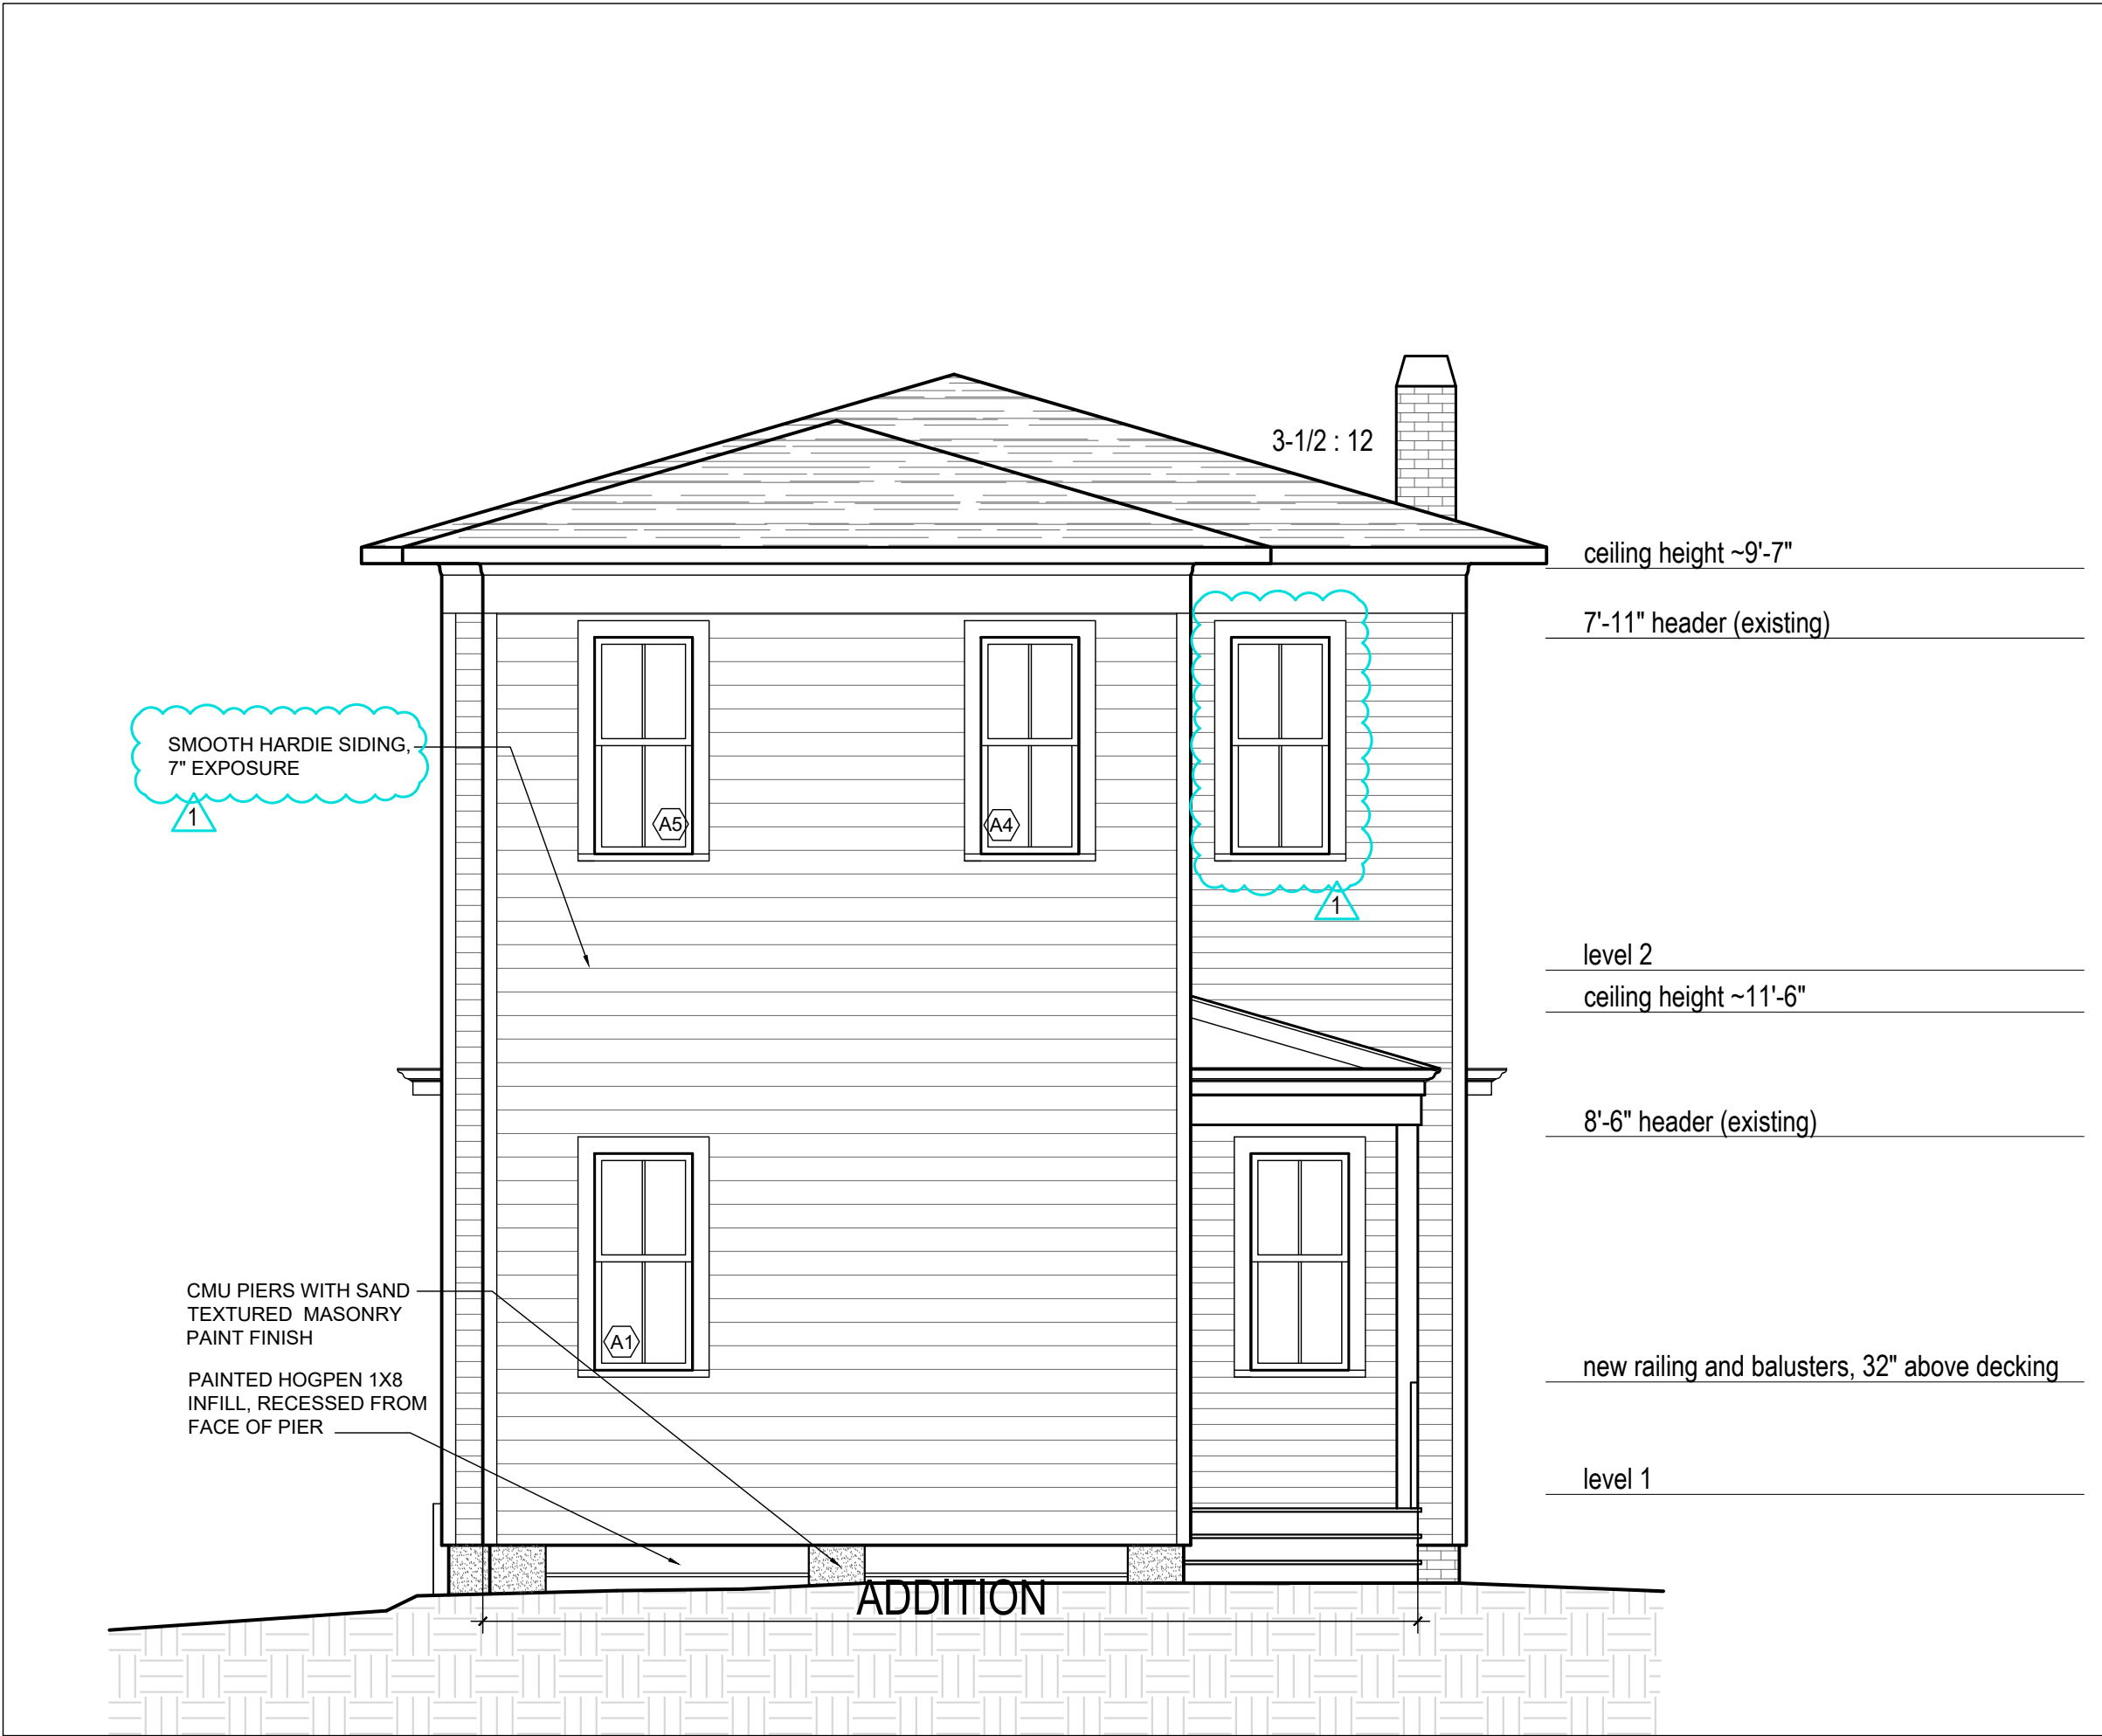


2 SOUTH ELEVATION: PROPOSED
SCALE: 1/4" = 1'-0"



4 WEST ELEVATION: PROPOSED
SCALE: 1/4" = 1'-0"

seal

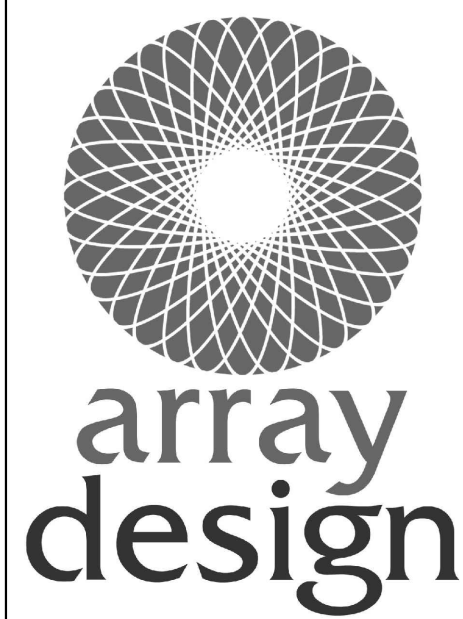

SHAUNA KUCERA
Registered Architect
912.228.9088


M. DIAB RESIDENCE
625 W. 36TH STREET
SAVANNAH, GEORGIA 31415

Revisions:
27 FEBRUARY 2026

Date: 23 february 2026
Title:
EXTERIOR ELEVATIONS, EXISTING & PROPOSED, SOUTH AND WEST
Drawing No.


A-2.1

NOT RELEASED FOR CONSTRUCTION

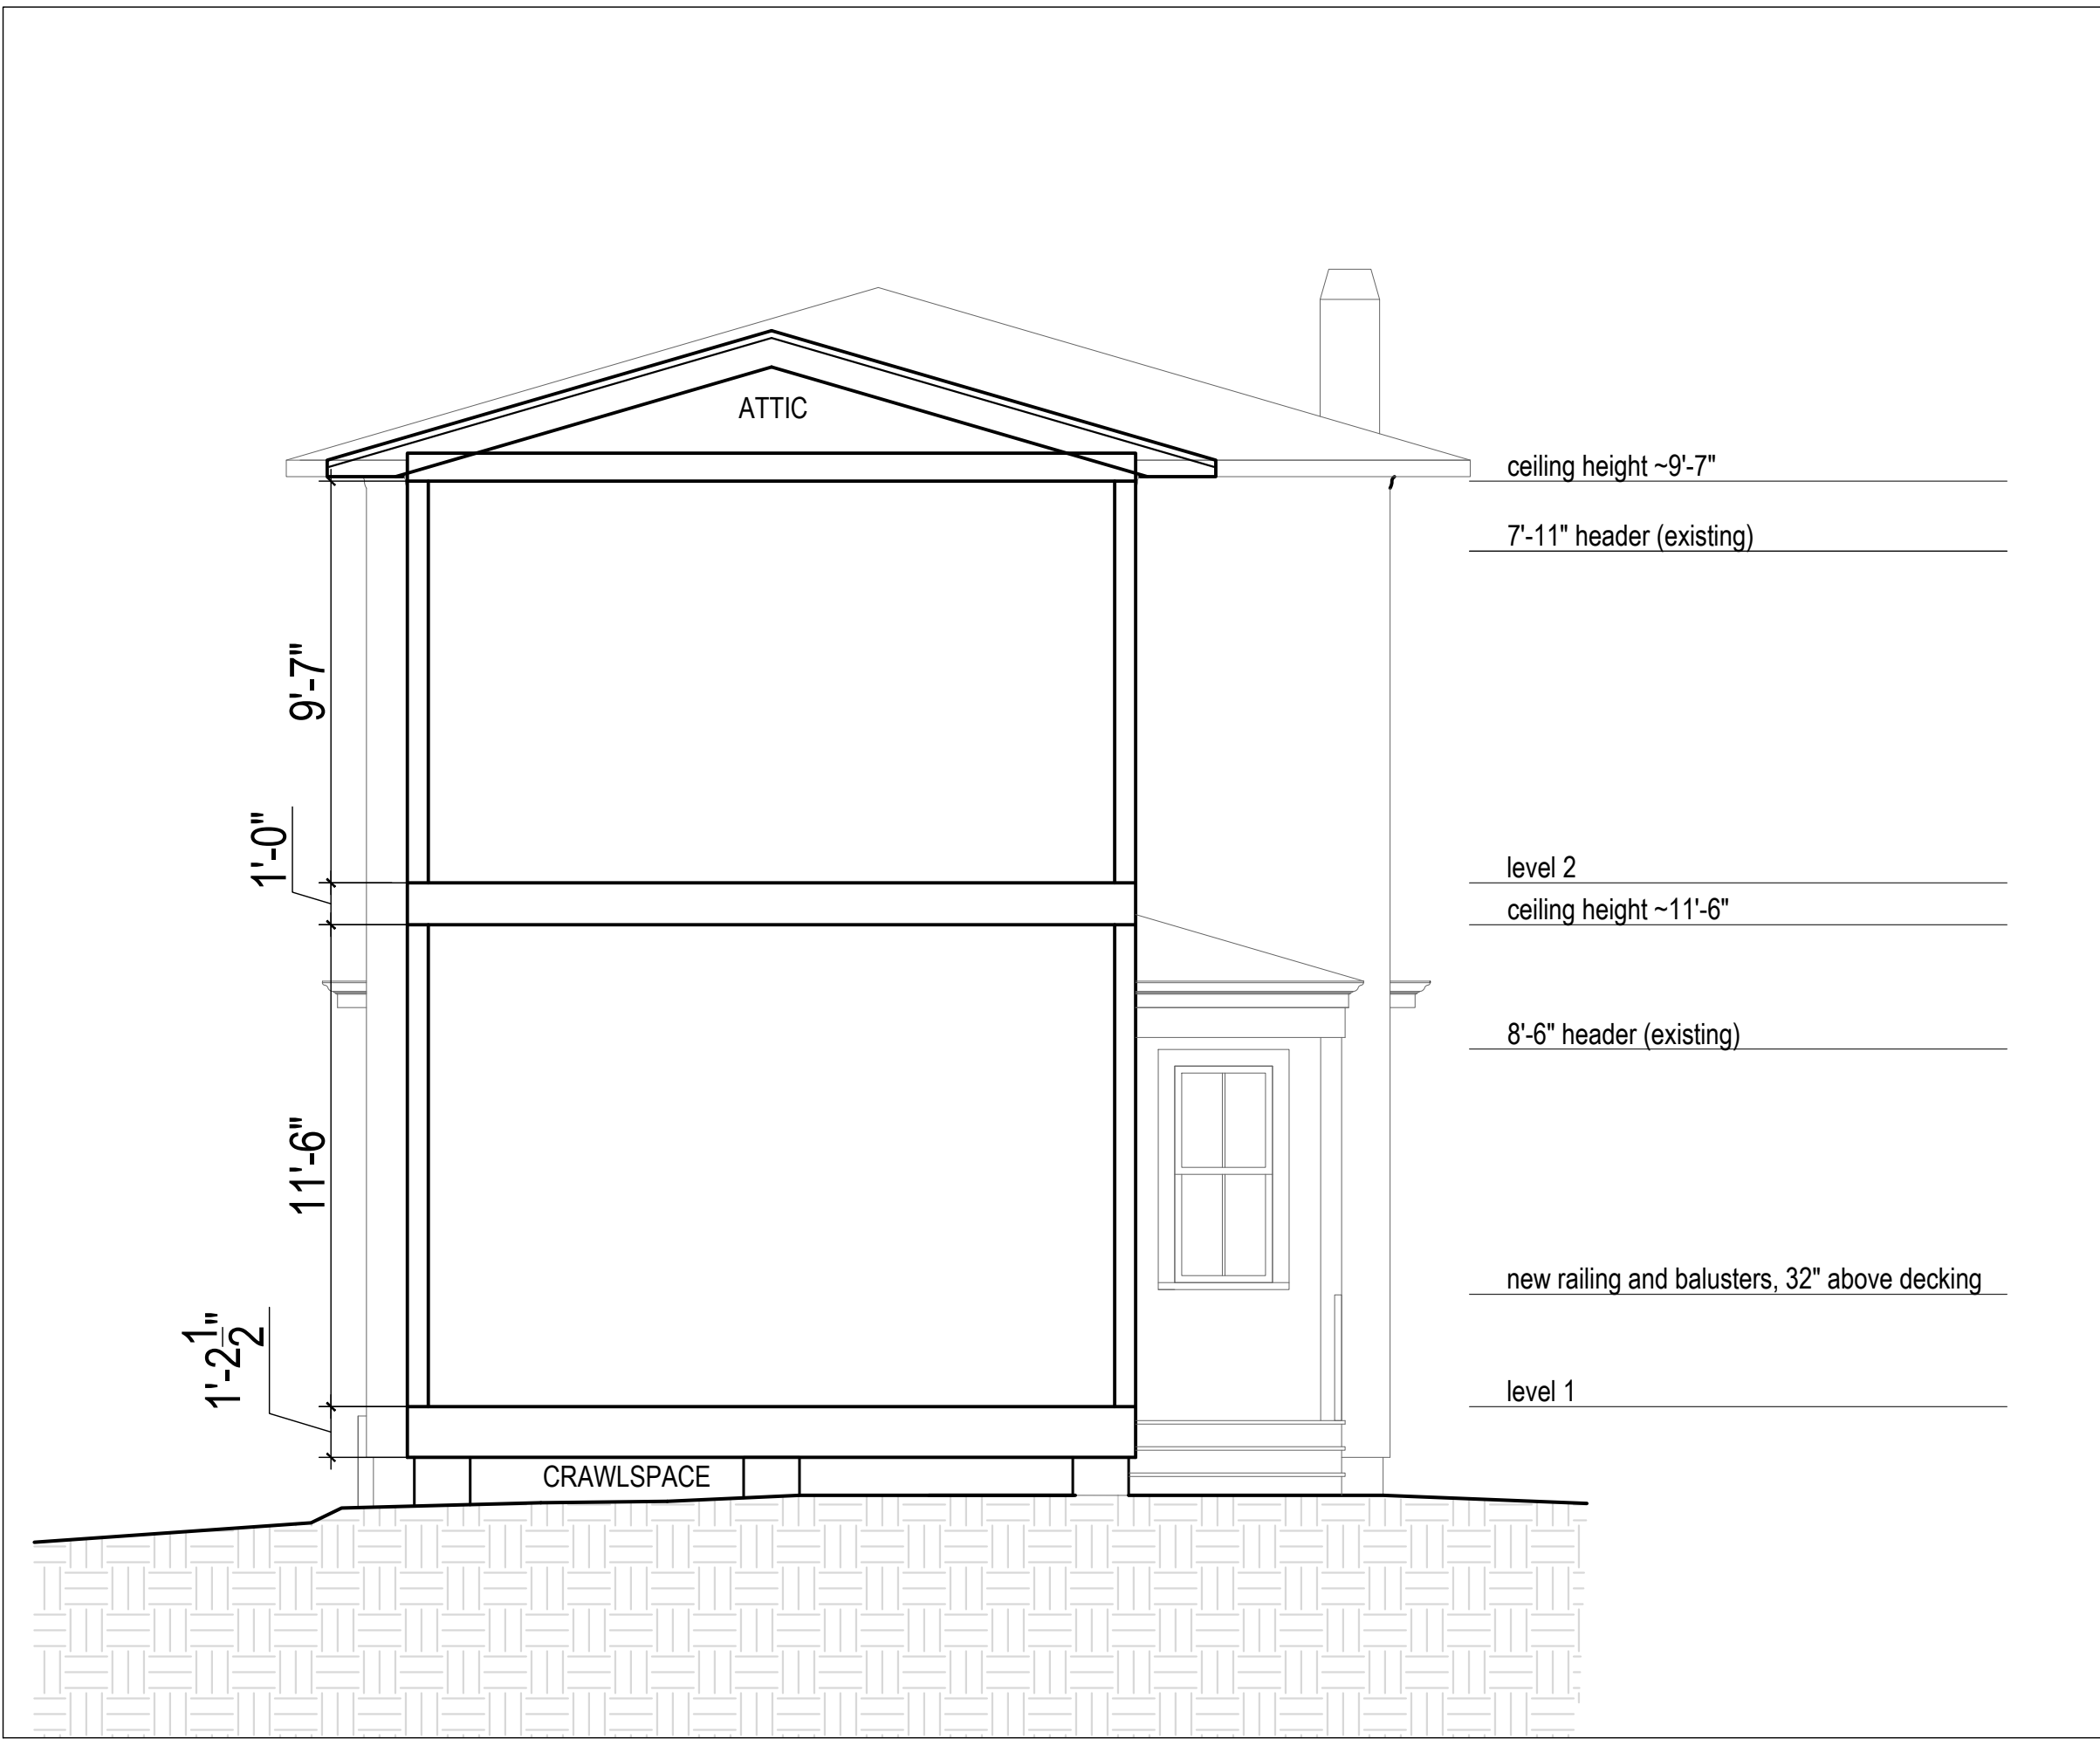

1
A-3.0


BUILDING SECTION THROUGH REAR ADDITION
WEST-EAST
SCALE: 1/4" = 1'-0"

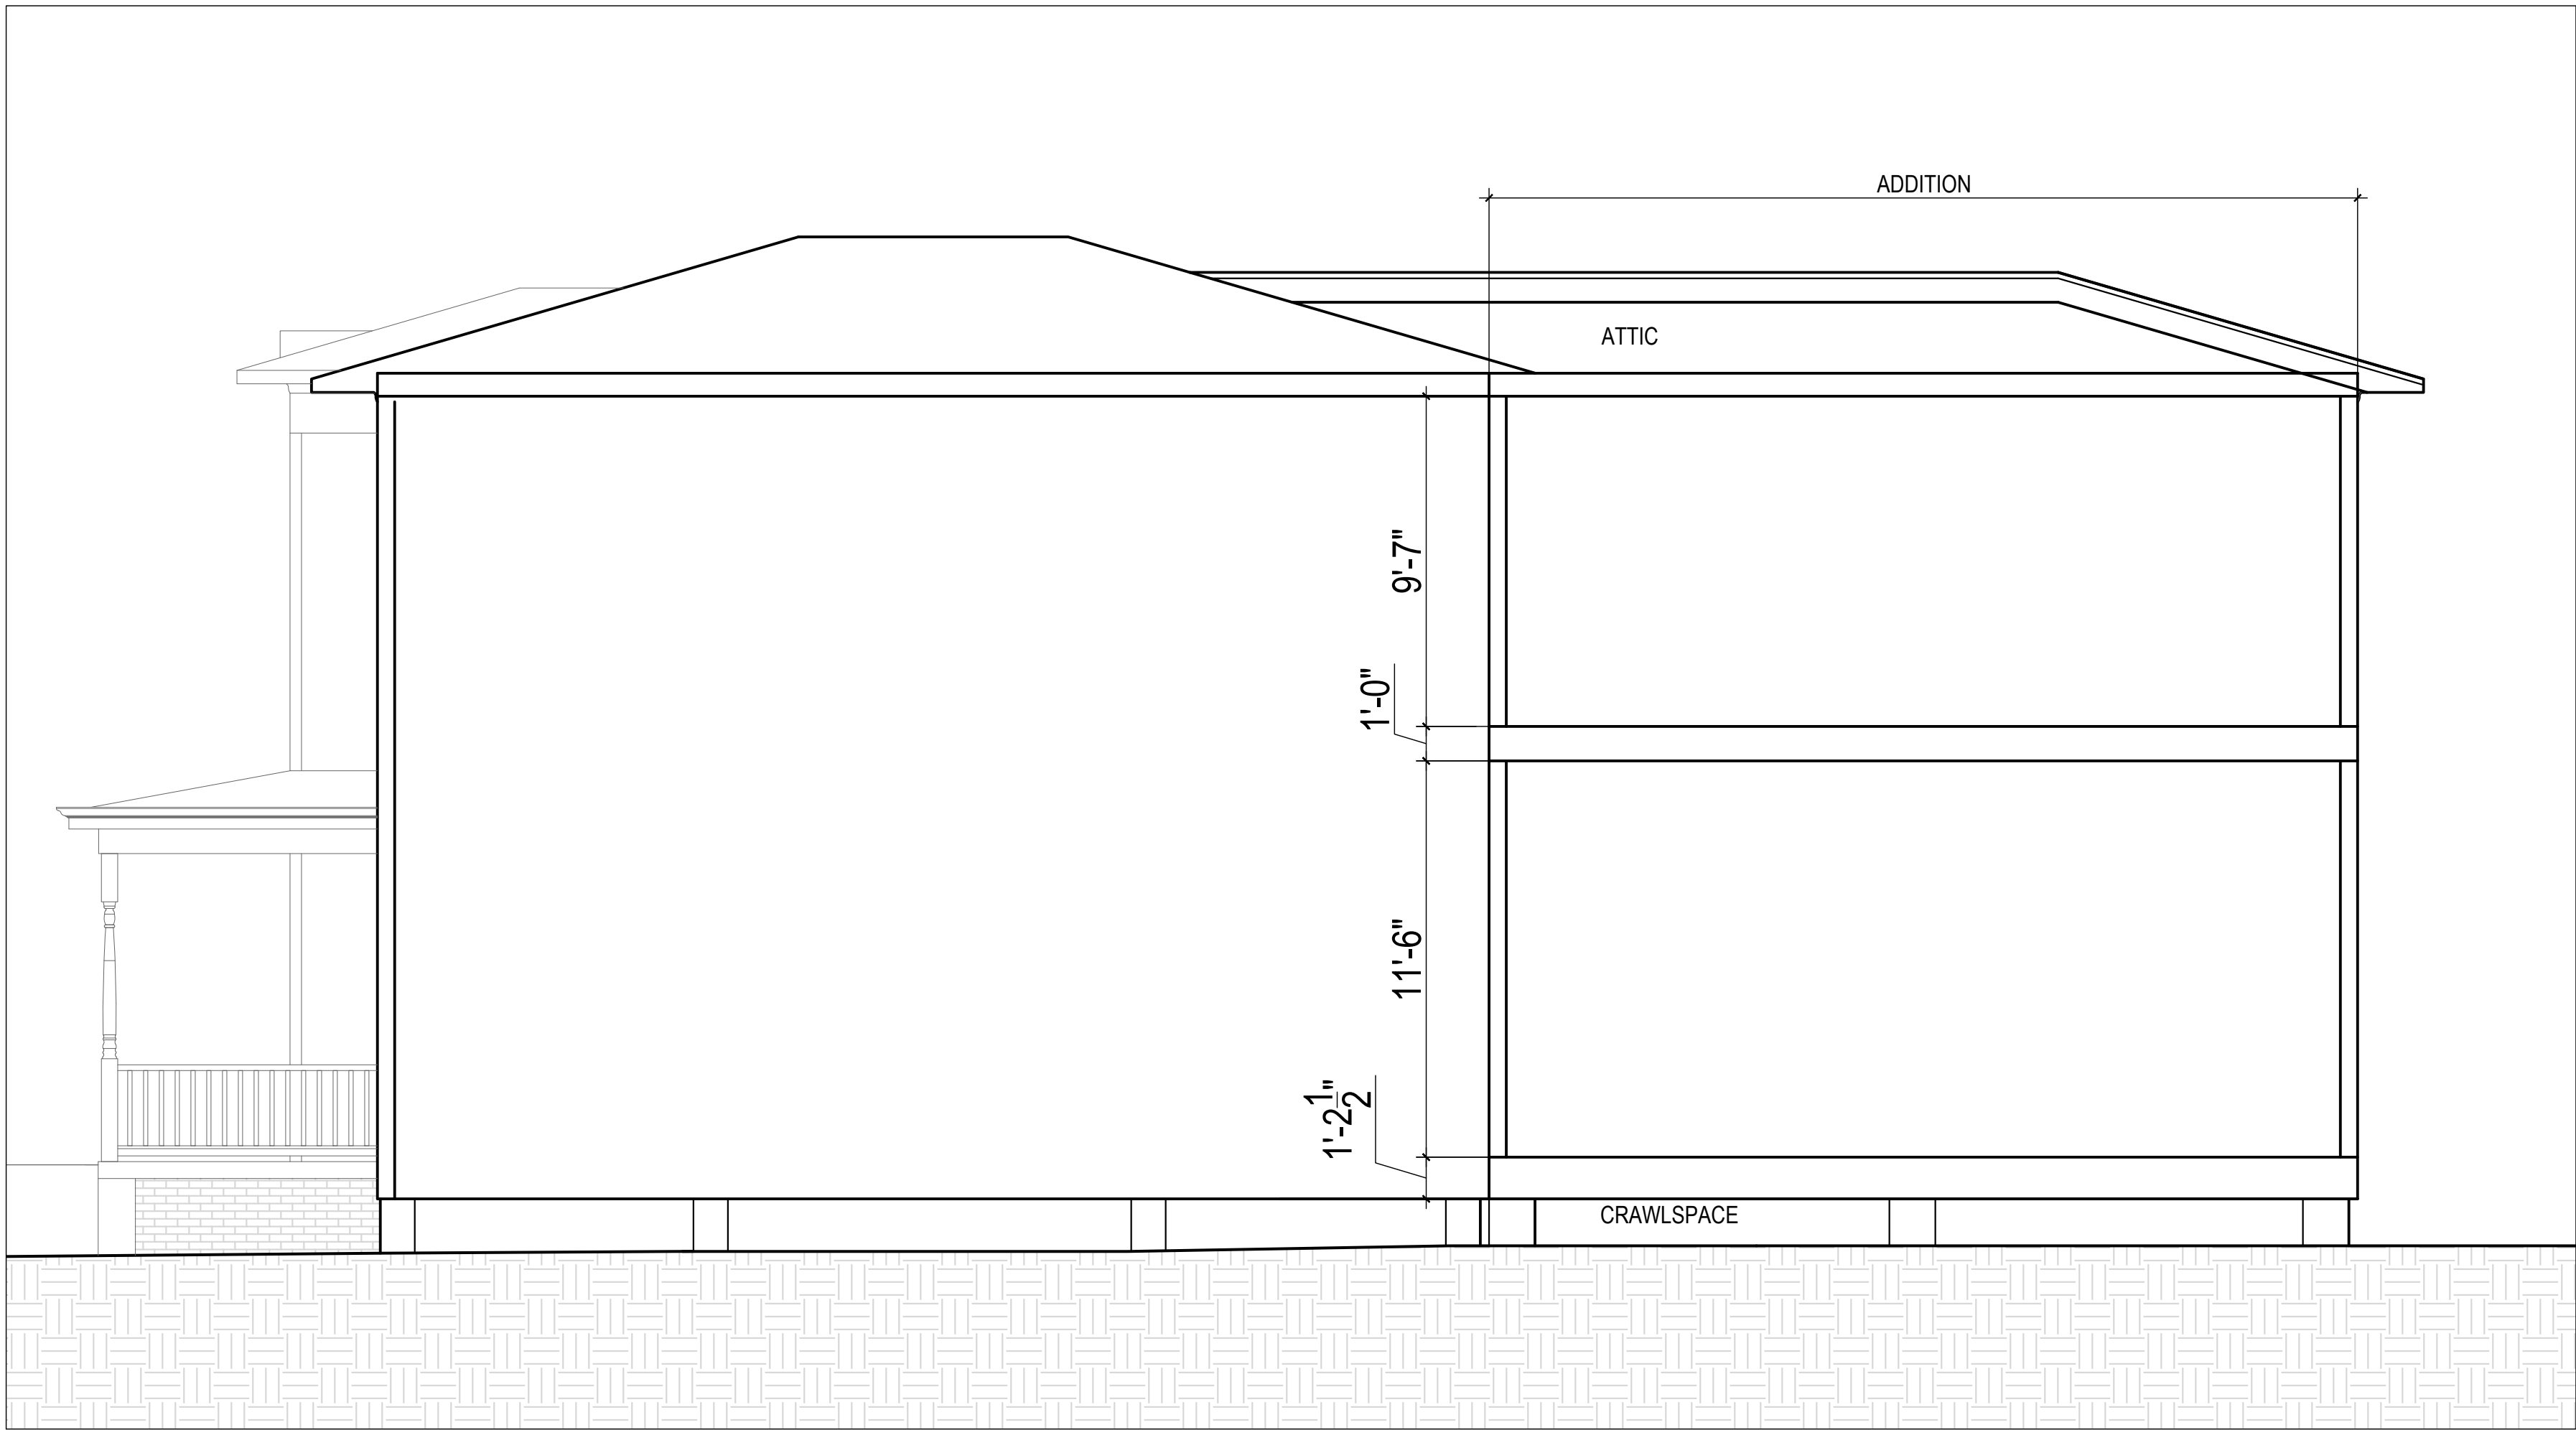


2
A-3.0

BUILDING SECTION THROUGH REAR ADDITION
NORTH-SOUTH
SCALE: 1/4" = 1'-0"

WINDOW DETAIL

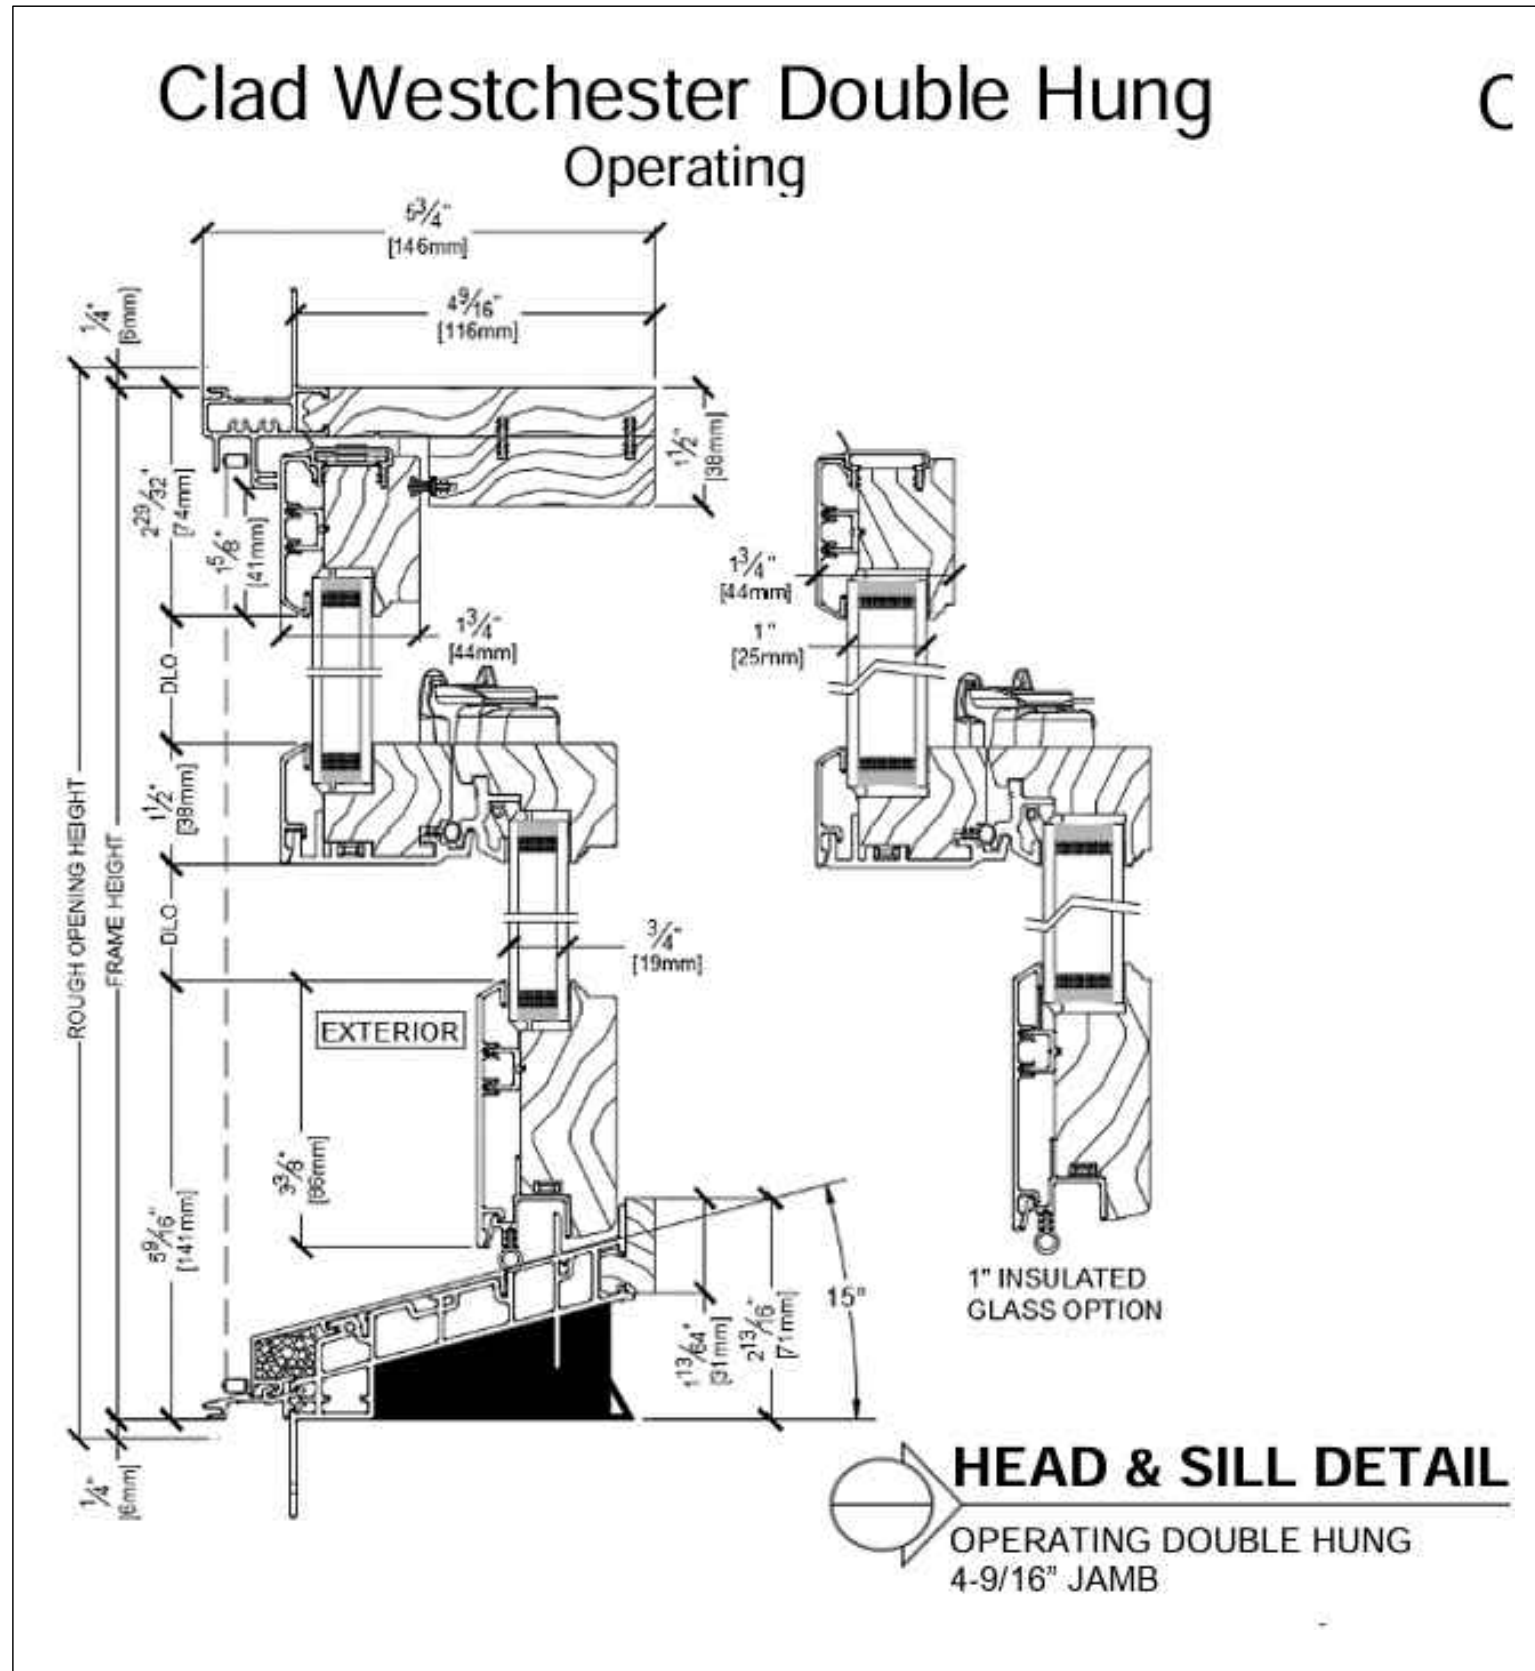


FENCE DETAIL

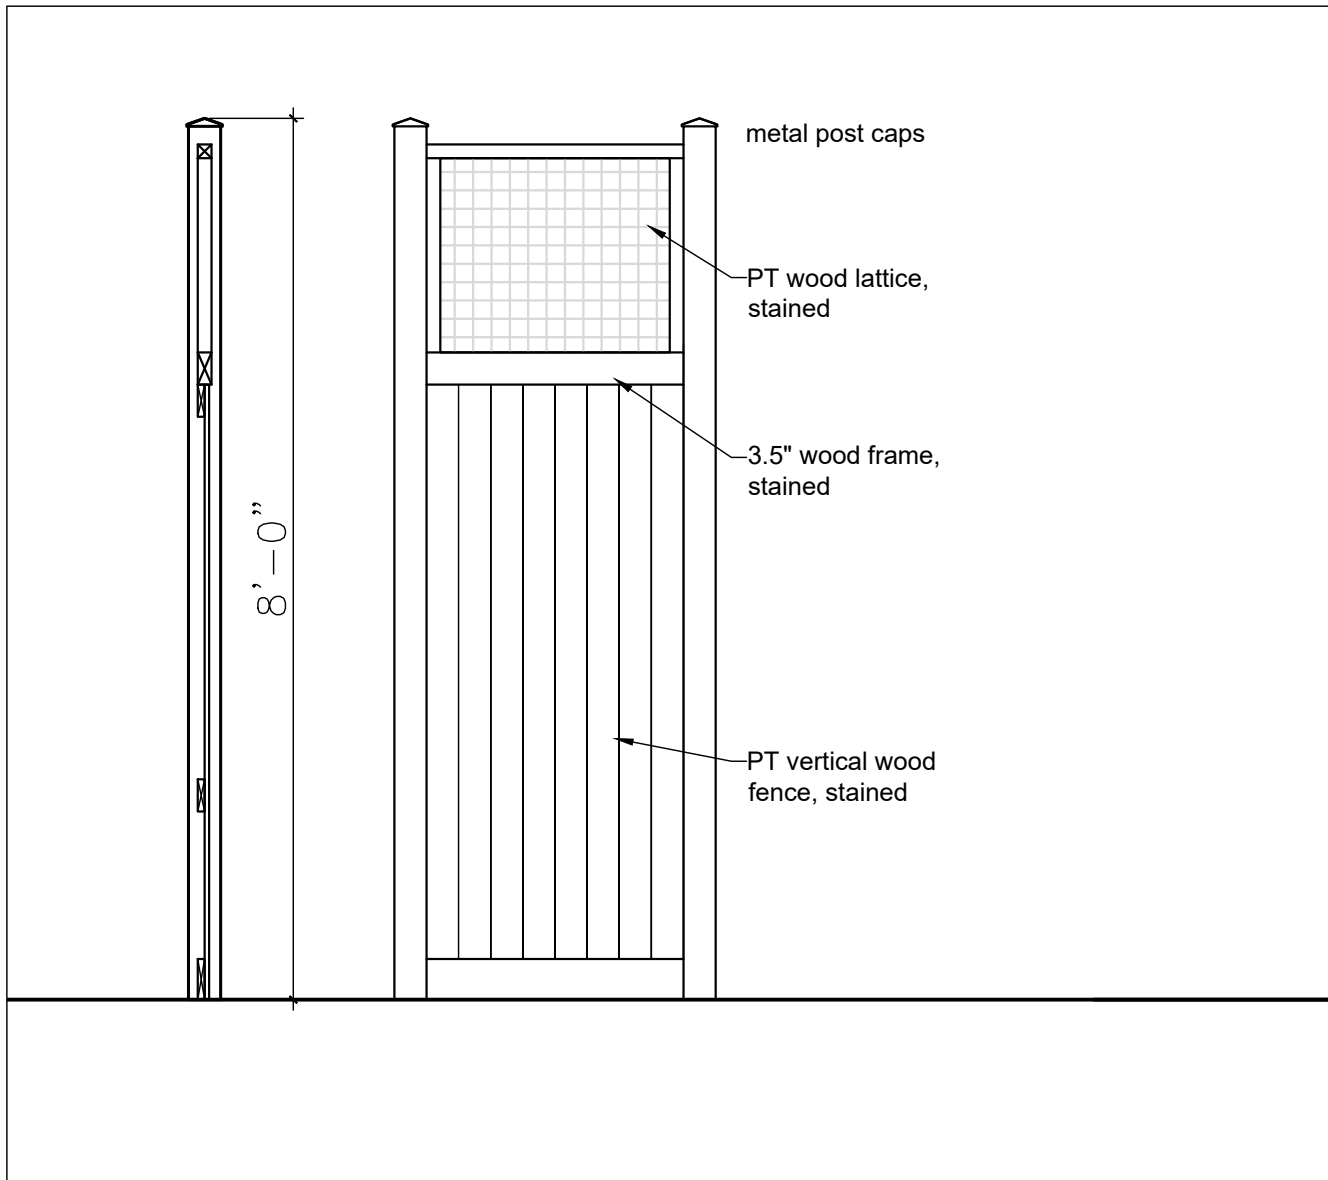

METAL POST CAPS



seal

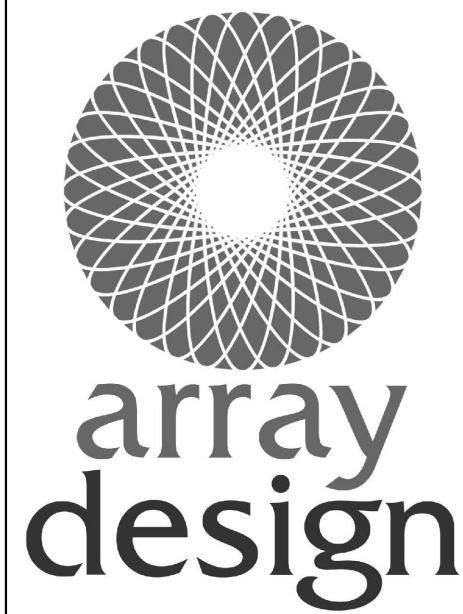

SHAUNA
KUCERA
Registered Architect
912.228.9088

M. DIAB RESIDENCE
625 W. 36TH STREET
SAVANNAH, GEORGIA 31415

Revisions:
27 FEBRUARY 2026

Date: 23 february 2026
Title:
BUILDING
SECTIONS

Drawing No.
A-3.0

NOT RELEASED FOR CONSTRUCTION